

Room Schedule		
Area	Level	Name


Not Enclosed	-01- Basement1	Garage
338 SF	00-Ground	Kitchen
189 SF	00-Ground	Dinning
612 SF	00-Ground	Living
171 SF	00-Ground	Deck
327 SF	00-Ground	Porch
177 SF	00-Ground	Patio
26 SF	00-Ground	Bathroom
507 SF	01-First	Concert Room
333 SF	01-First	Reading Room
28 SF	01-First	Powder

Room Schedule		
Area	Level	Name


24 SF	01-First	Bath 1
36 SF	01-First	Bath 2
424 SF	01-First	Entertainment Room
249 SF	01-First	Open to Below
282 SF	02-Second	Master bedroom
167 SF	02-Second	kid Bedroom
114 SF	02-Second	Kid Bathroom
34 SF	02-Second	Master Powder
47 SF	02-Second	Master Closet
38 SF	02-Second	Master Bath
342 SF	02-Second	Office
152 SF	02-Second	Open to Below




### 1 3D VIEWS FOR COVER SHEET

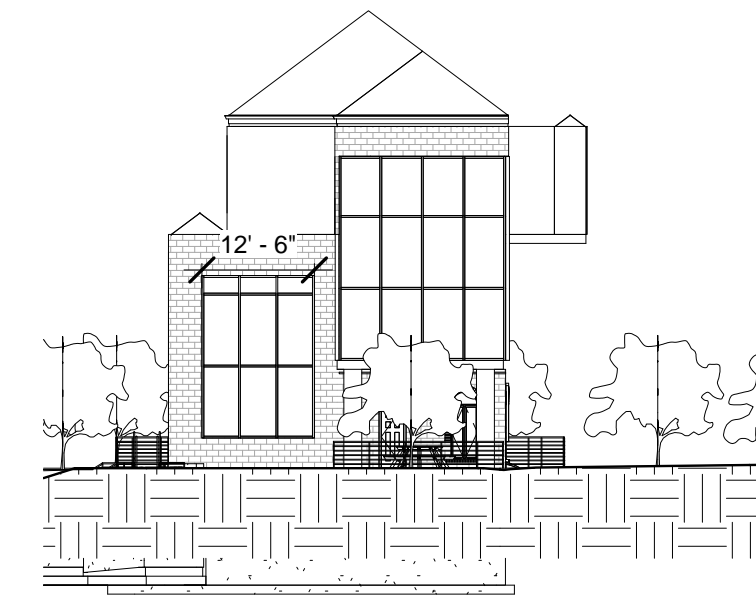


② East -- COVER SHEET  
3/64" = 1'-0"

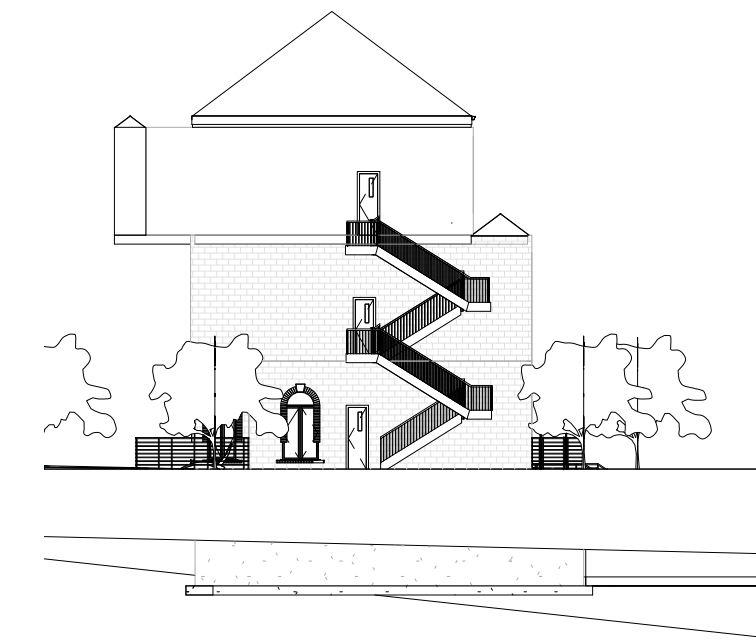

③ West -- COVER SHEET  
3/64" = 1'-0"

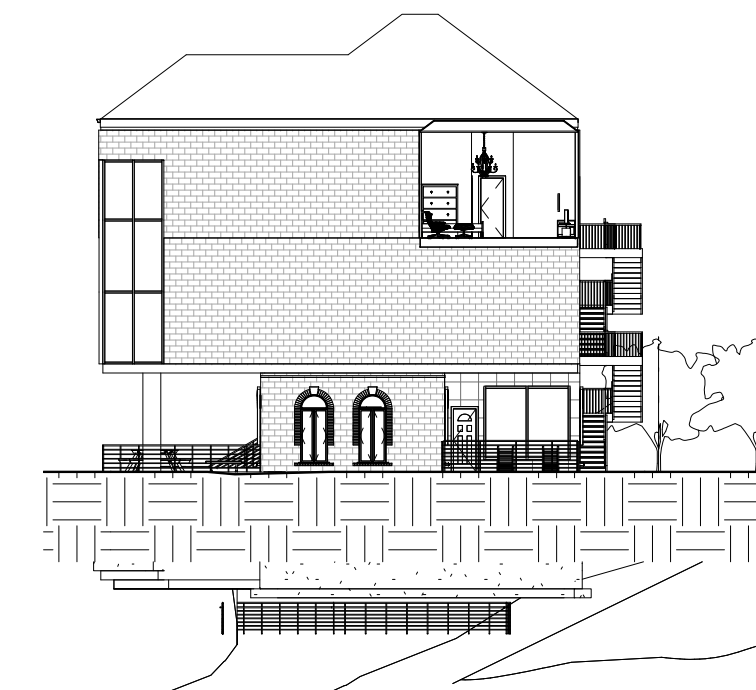

4 North -- COVER SHEET  
3/64" = 1'-0"

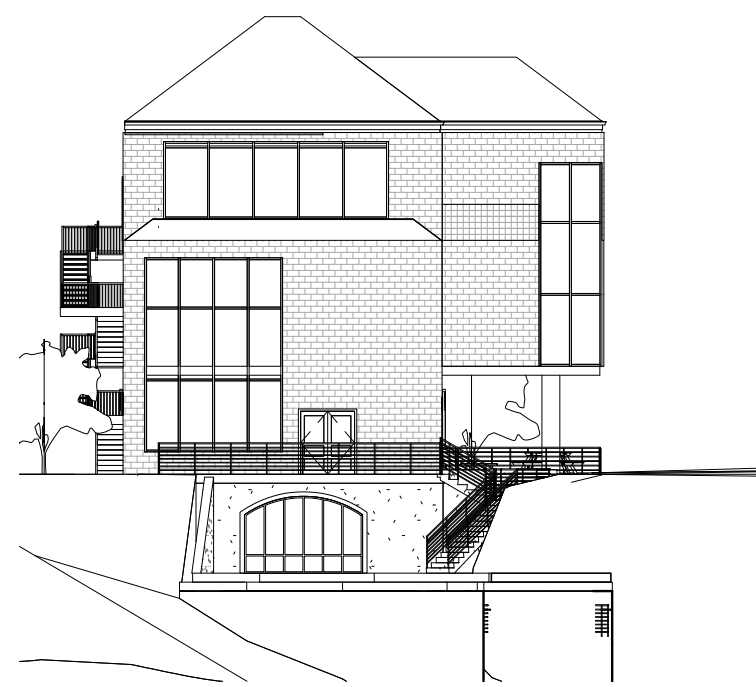

5 South COVER SHEET  
3/64" = 1'-0"

**YH DESIGN**

www.yhdesign.com

Consultant Prof. Chistine Wacta  
Address Eichberg Hall  
Phone 912-228-2696

SCAD  
ELDS - 225-07  
FINAL

No.	Description	Date
HW 2B	house by the water	04/15/2013
HW 3	Pre-Final	04/24/2013
HW 4	Pre-Final	05/06/2013
HW 5	Pre- Final	05/13/2013

## House by Water

# Cover Sheet

Project Number	Project Number
Date	May 1st, 2013
Drawn By	Yun Huang
Checked By	Prof. Wacta

A 000

Scale	$3/64" = 1'-0"$
-------	-----------------

5/30/2013 11:31:53 AM





www.yhdesign.com

Consultant Prof. Christine Wacta

Address Eichberg Hall

Phone 912-228-2696

SCAD

ELDS - 225-07

FINAL

No.	Description	Date
HW 2B	house by the water	04/15/2013
HW 3	Pre-Final	04/24/2013
HW 4	Pre-Final	05/06/2013
HW 5	Pre- Final	05/13/2013

House by Water

Project Data

Project Number Project Number

Date May 1st, 2013

Drawn By Author


Checked By Prof. Wacta

A 001

Scale 1/4" = 1'-0"

5/30/2013 11:31:54 AM



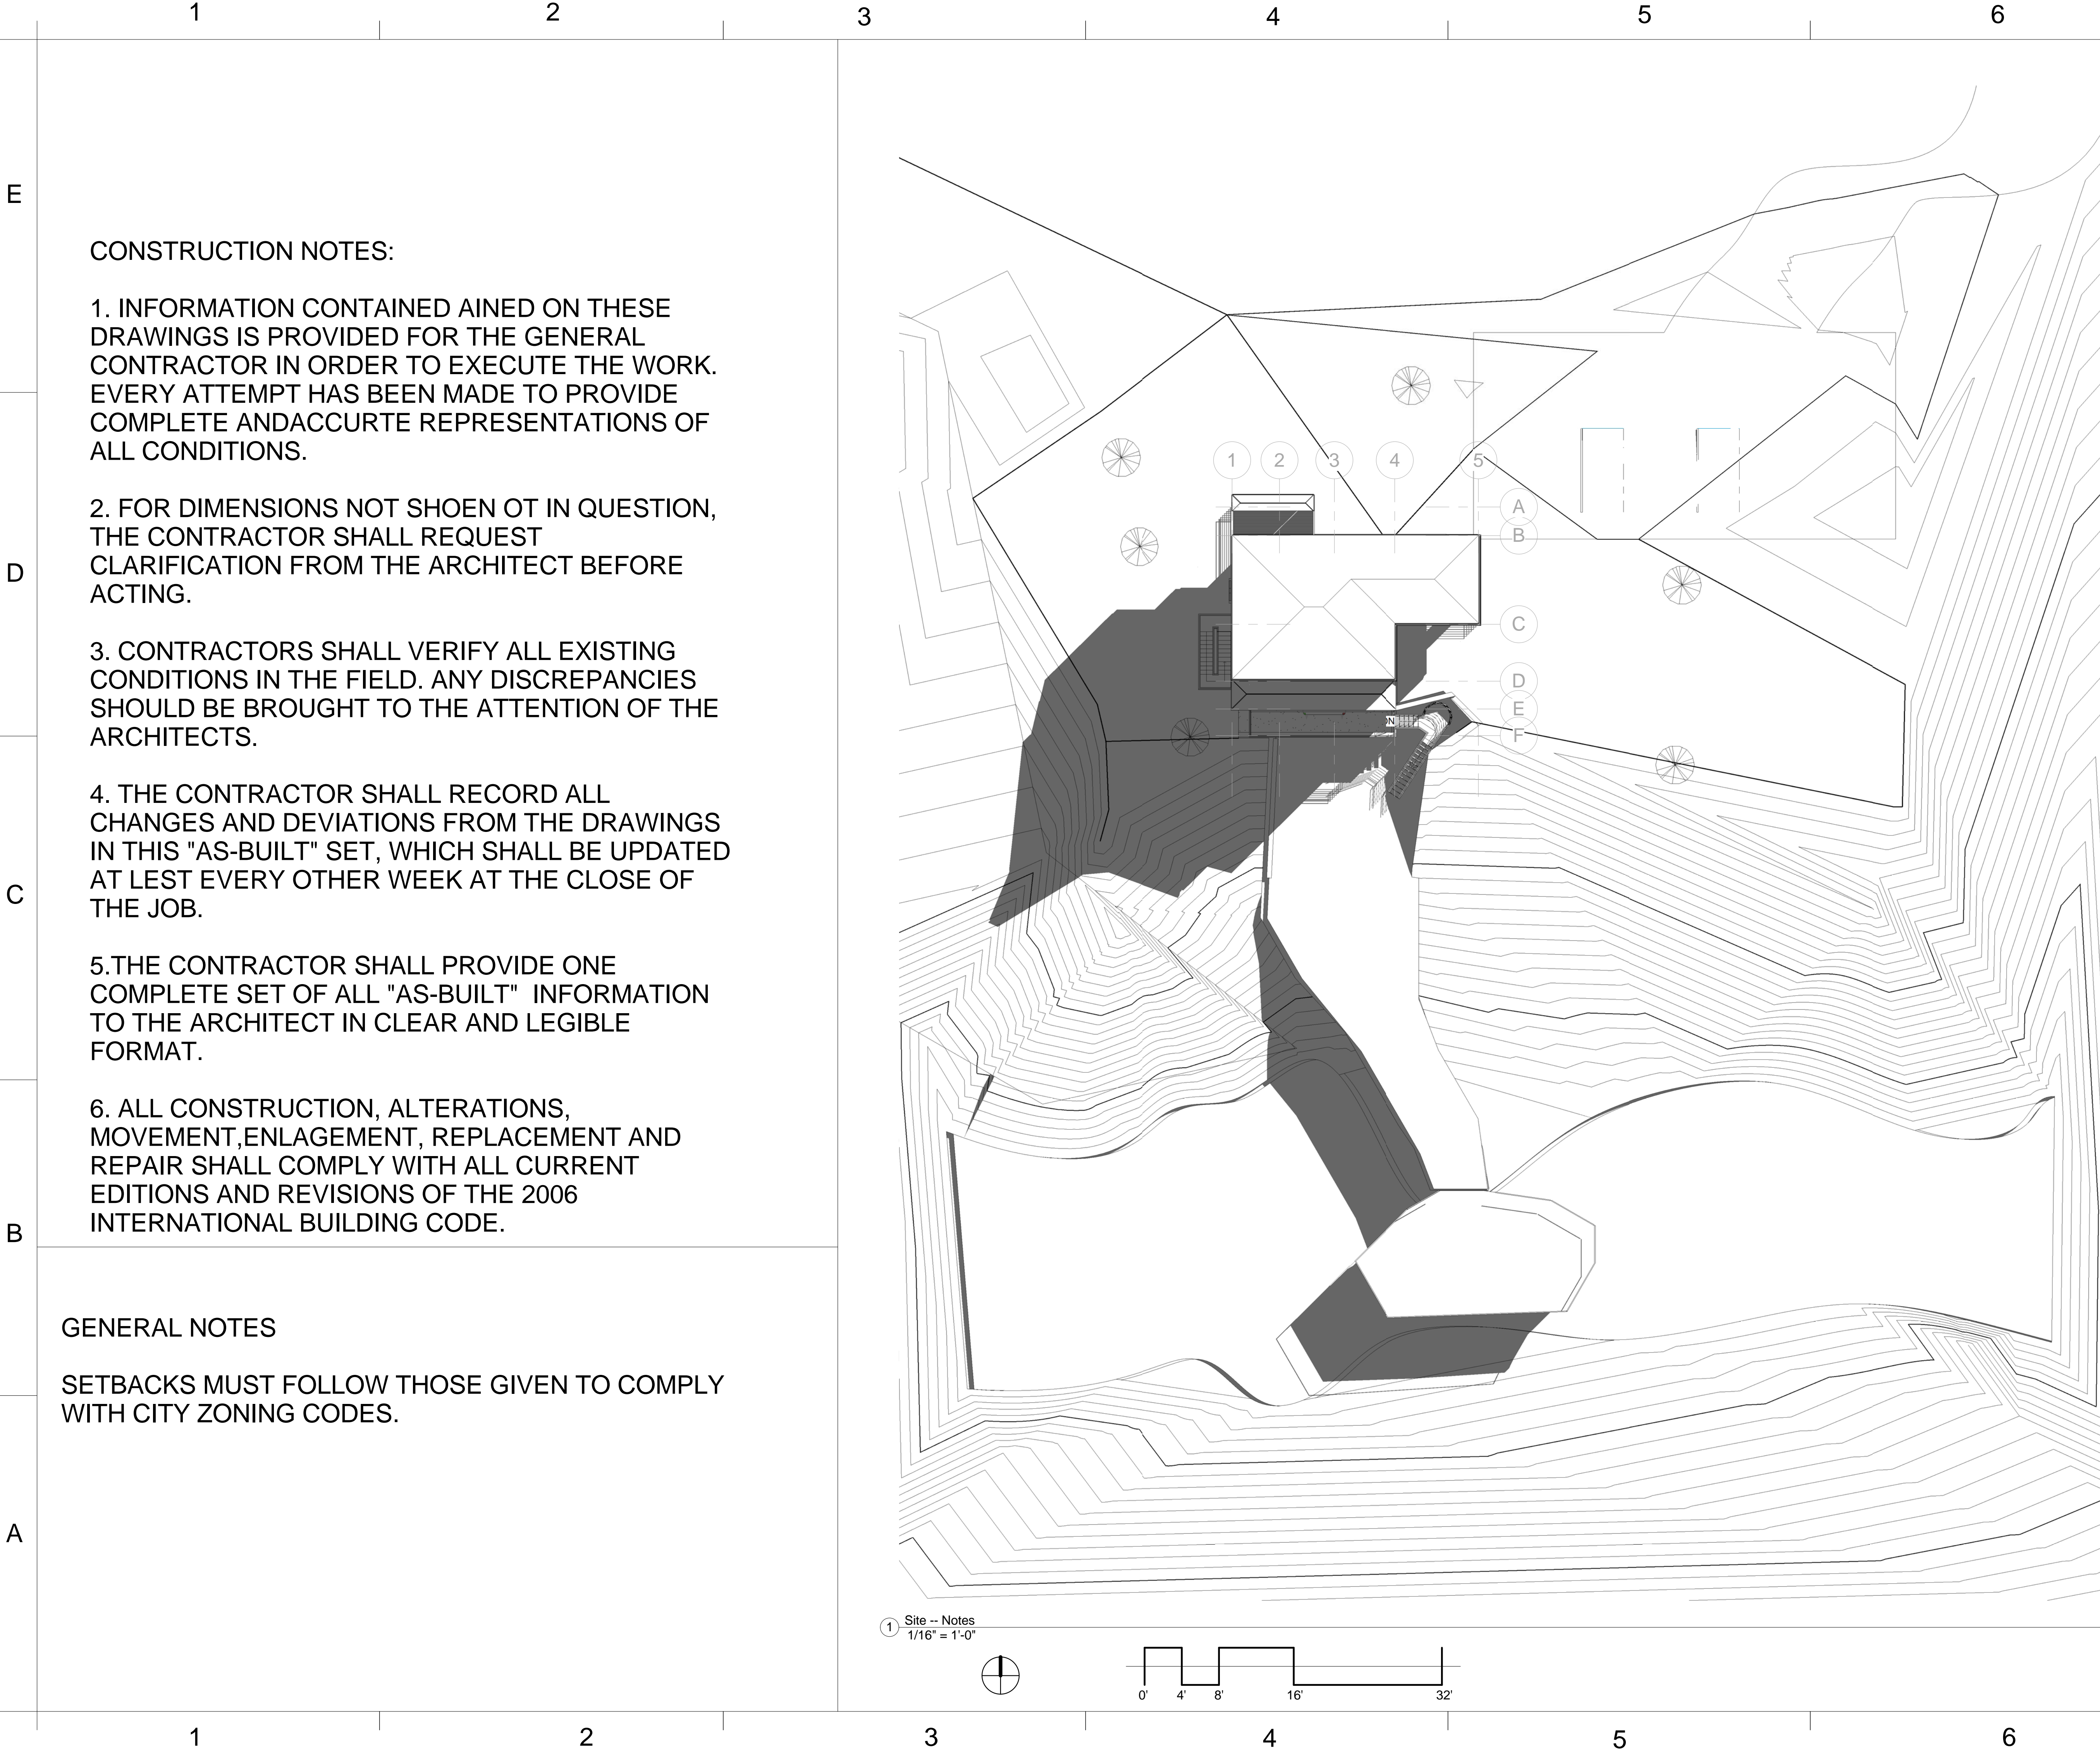

CONSTRUCTION NOTES:

- 1. INFORMATION CONTAINED AINED ON THESE DRAWINGS IS PROVIDED FOR THE GENERAL CONTRACTOR IN ORDER TO EXECUTE THE WORK. EVERY ATTEMPT HAS BEEN MADE TO PROVIDE COMPLETE ANDACCURTE REPRESENTATIONS OF ALL CONDITIONS.
- 2. FOR DIMENSIONS NOT SHOEN OT IN QUESTION, THE CONTRACTOR SHALL REQUEST CLARIFICATION FROM THE ARCHITECT BEFORE ACTING.
- 3. CONTRACTORS SHALL VERIFY ALL EXISTING CONDITIONS IN THE FIELD. ANY DISCREPANCIES SHOULD BE BROUGHT TO THE ATTENTION OF THE ARCHITECTS.
- 4. THE CONTRACTOR SHALL RECORD ALL CHANGES AND DEVIATIONS FROM THE DRAWINGS IN THIS "AS-BUILT" SET, WHICH SHALL BE UPDATED AT LEAST EVERY OTHER WEEK AT THE CLOSE OF THE JOB.
- 5.THE CONTRACTOR SHALL PROVIDE ONE COMPLETE SET OF ALL "AS-BUILT" INFORMATION TO THE ARCHITECT IN CLEAR AND LEGIBLE FORMAT.
- 6. ALL CONSTRUCTION, ALTERATIONS, MOVEMENT,ENLAGEMENT, REPLACEMENT AND REPAIR SHALL COMPLY WITH ALL CURRENT EDITIONS AND REVISIONS OF THE 2006 INTERNATIONAL BUILDING CODE.


GENERAL NOTES

SETBACKS MUST FOLLOW THOSE GIVEN TO COMPLY WITH CITY ZONING CODES.

YH DESIGN

www.yhdesign.com

Consultant Prof. Christine Wacta  
Address Eichberg Hall  
Phone 912-228-2696

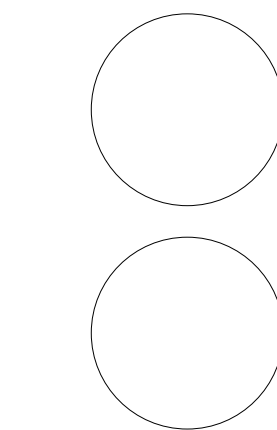

SCAD  
ELDS - 225-07  
FINAL

No.	Description	Date
HW 2B	house by the water	04/15/2013
HW 3	Pre-Final	04/24/2013
HW 4	Pre-Final	05/06/2013
HW 5	Pre- Final	05/13/2013

House by Water


Notes

Project Number	Project Number
Date	May 1st, 2013
Drawn By	Author
Checked By	Checker

A 002

Scale 1/16" = 1'-0"



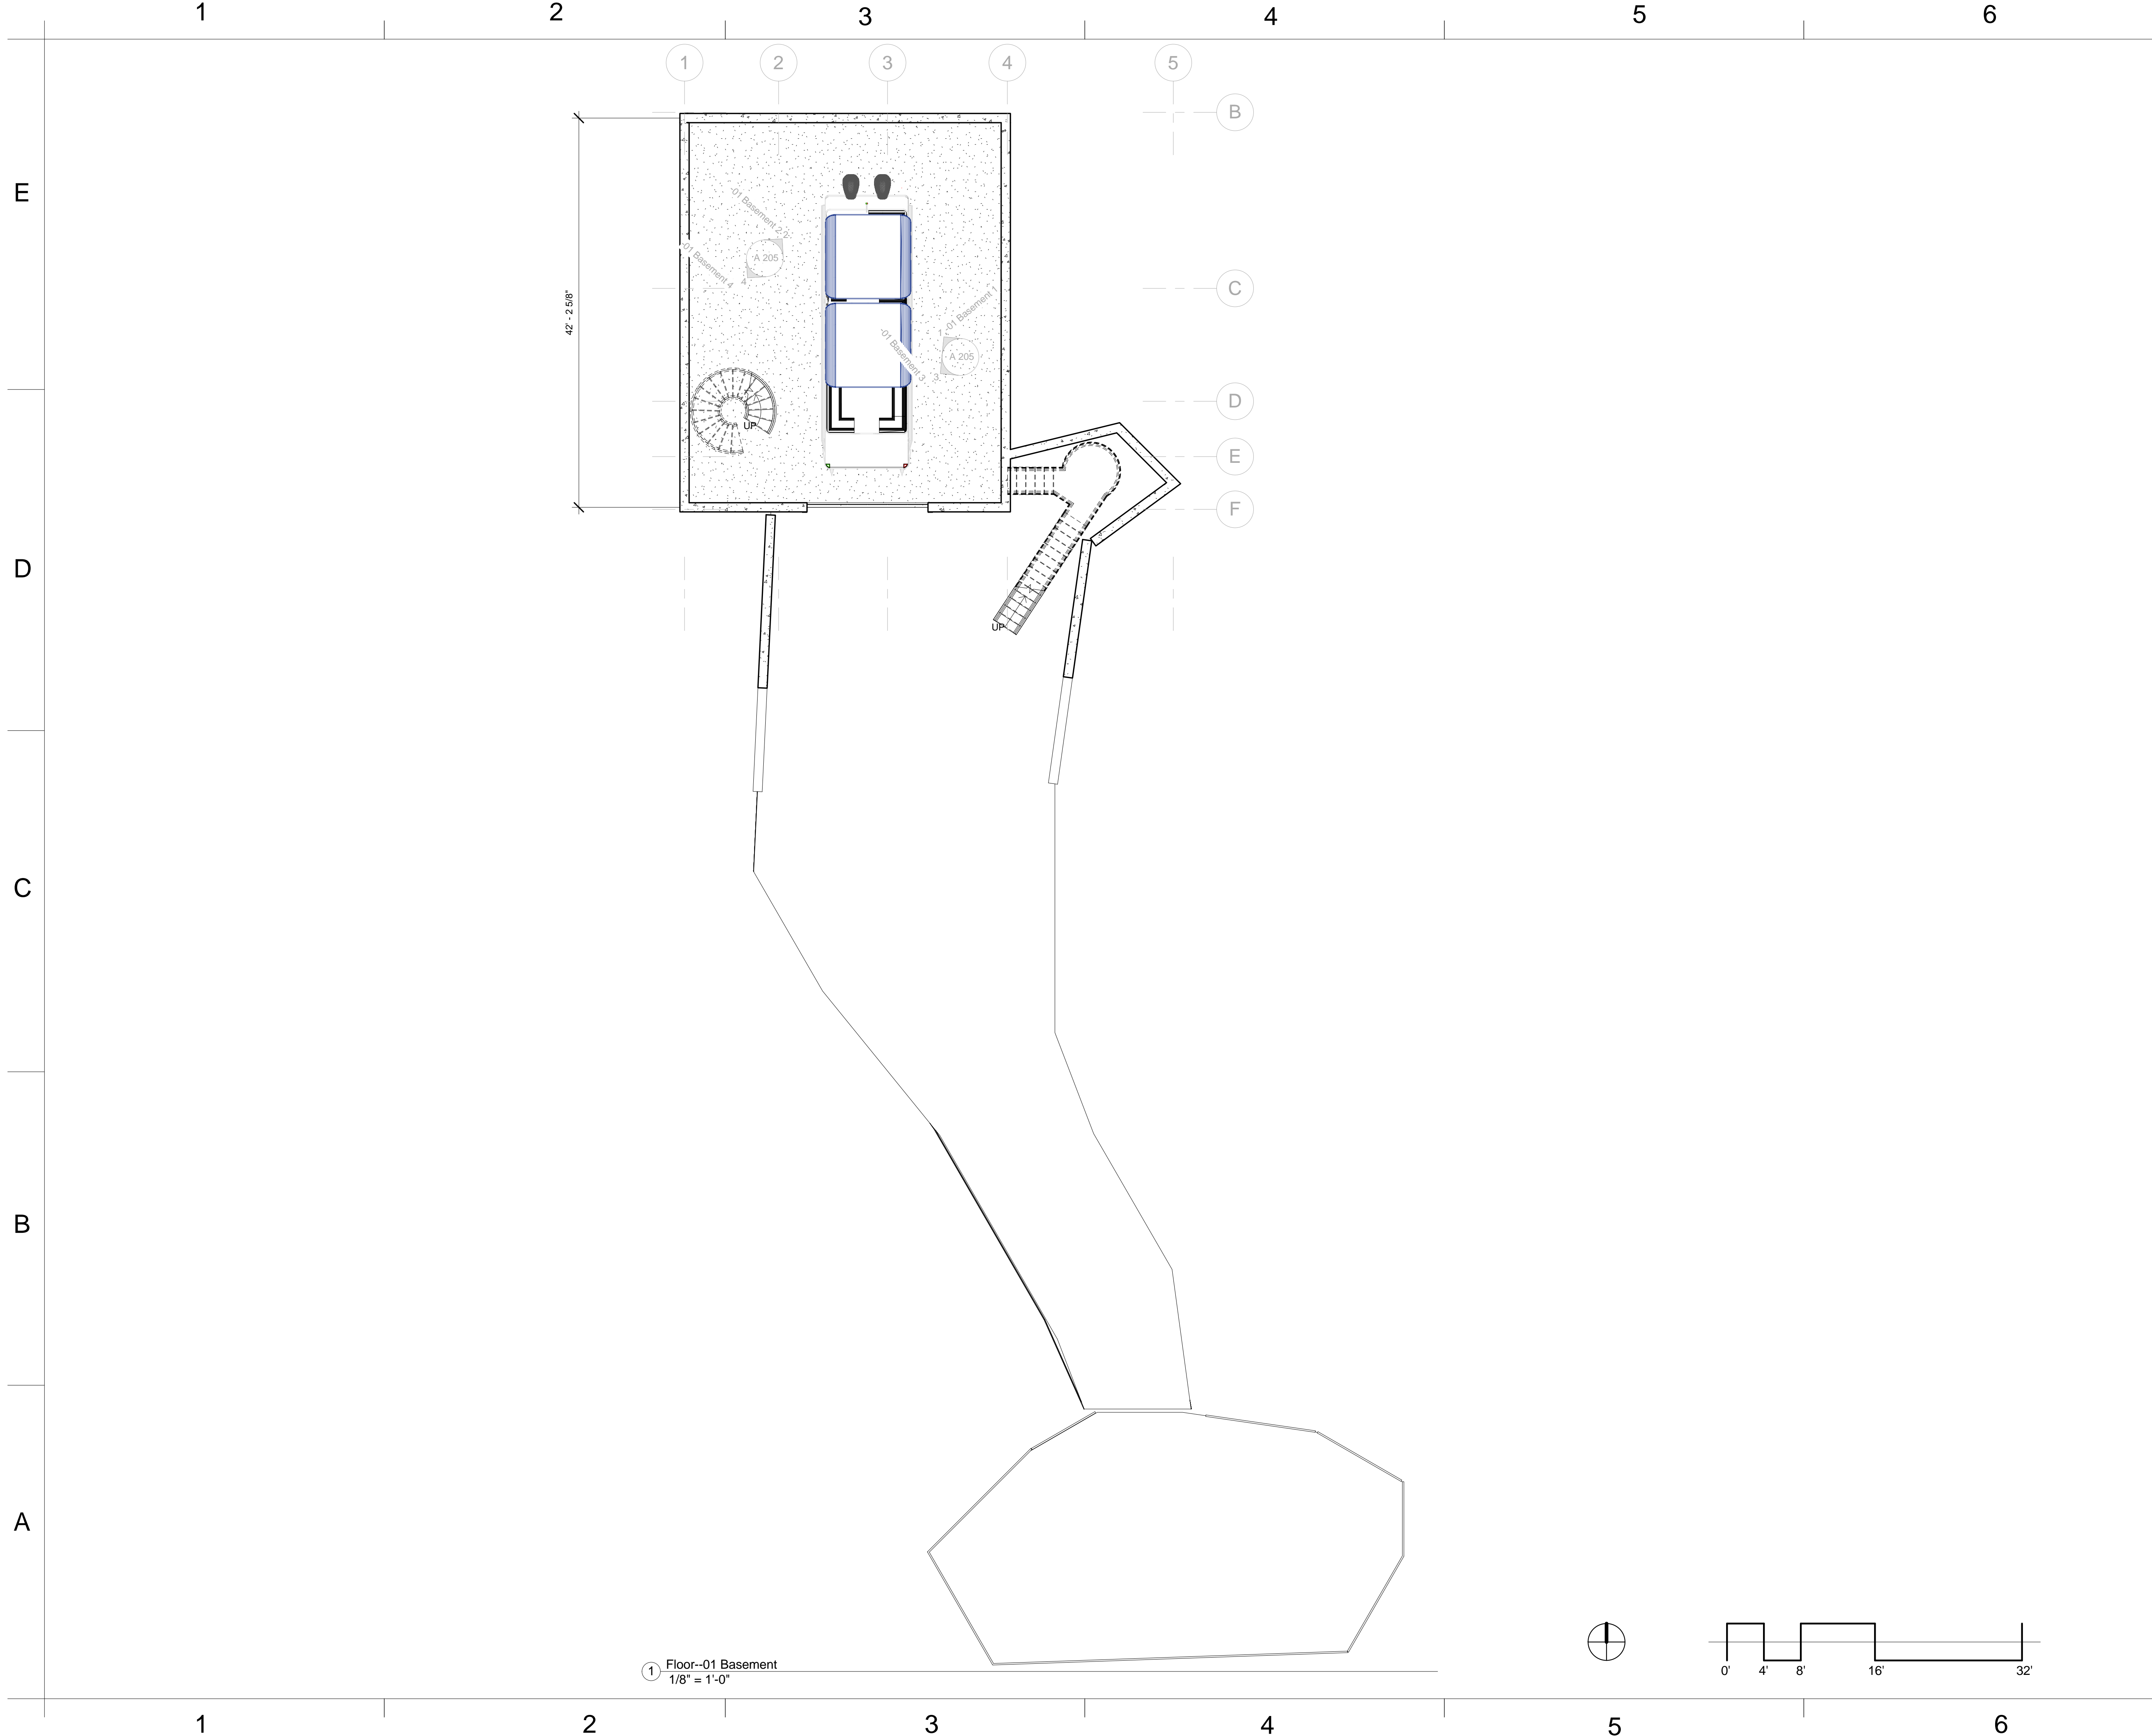

**YH DESIGN**

www.yhdesign.com

Consultant Prof. Christine Wacta  
Address Eichberg Hall  
Phone 912-228-2696

SCAD  
ELDS - 225-07  
FINAL

No.	Description	Date
HW 2B	house by the water	04/15/2013
HW 3	Pre-Final	04/24/2013
HW 4	Pre-Final	05/06/2013
HW 5	Pre- Final	05/13/2013

House by Water

FLOOR PLAN --  
BASEMENT 1


Project Number  
Date  
Drawn By  
Checked By

Project Number  
May 1st, 2013  
Author  
Prof. Wacta

A 102

Scale1/8" = 1'-0"



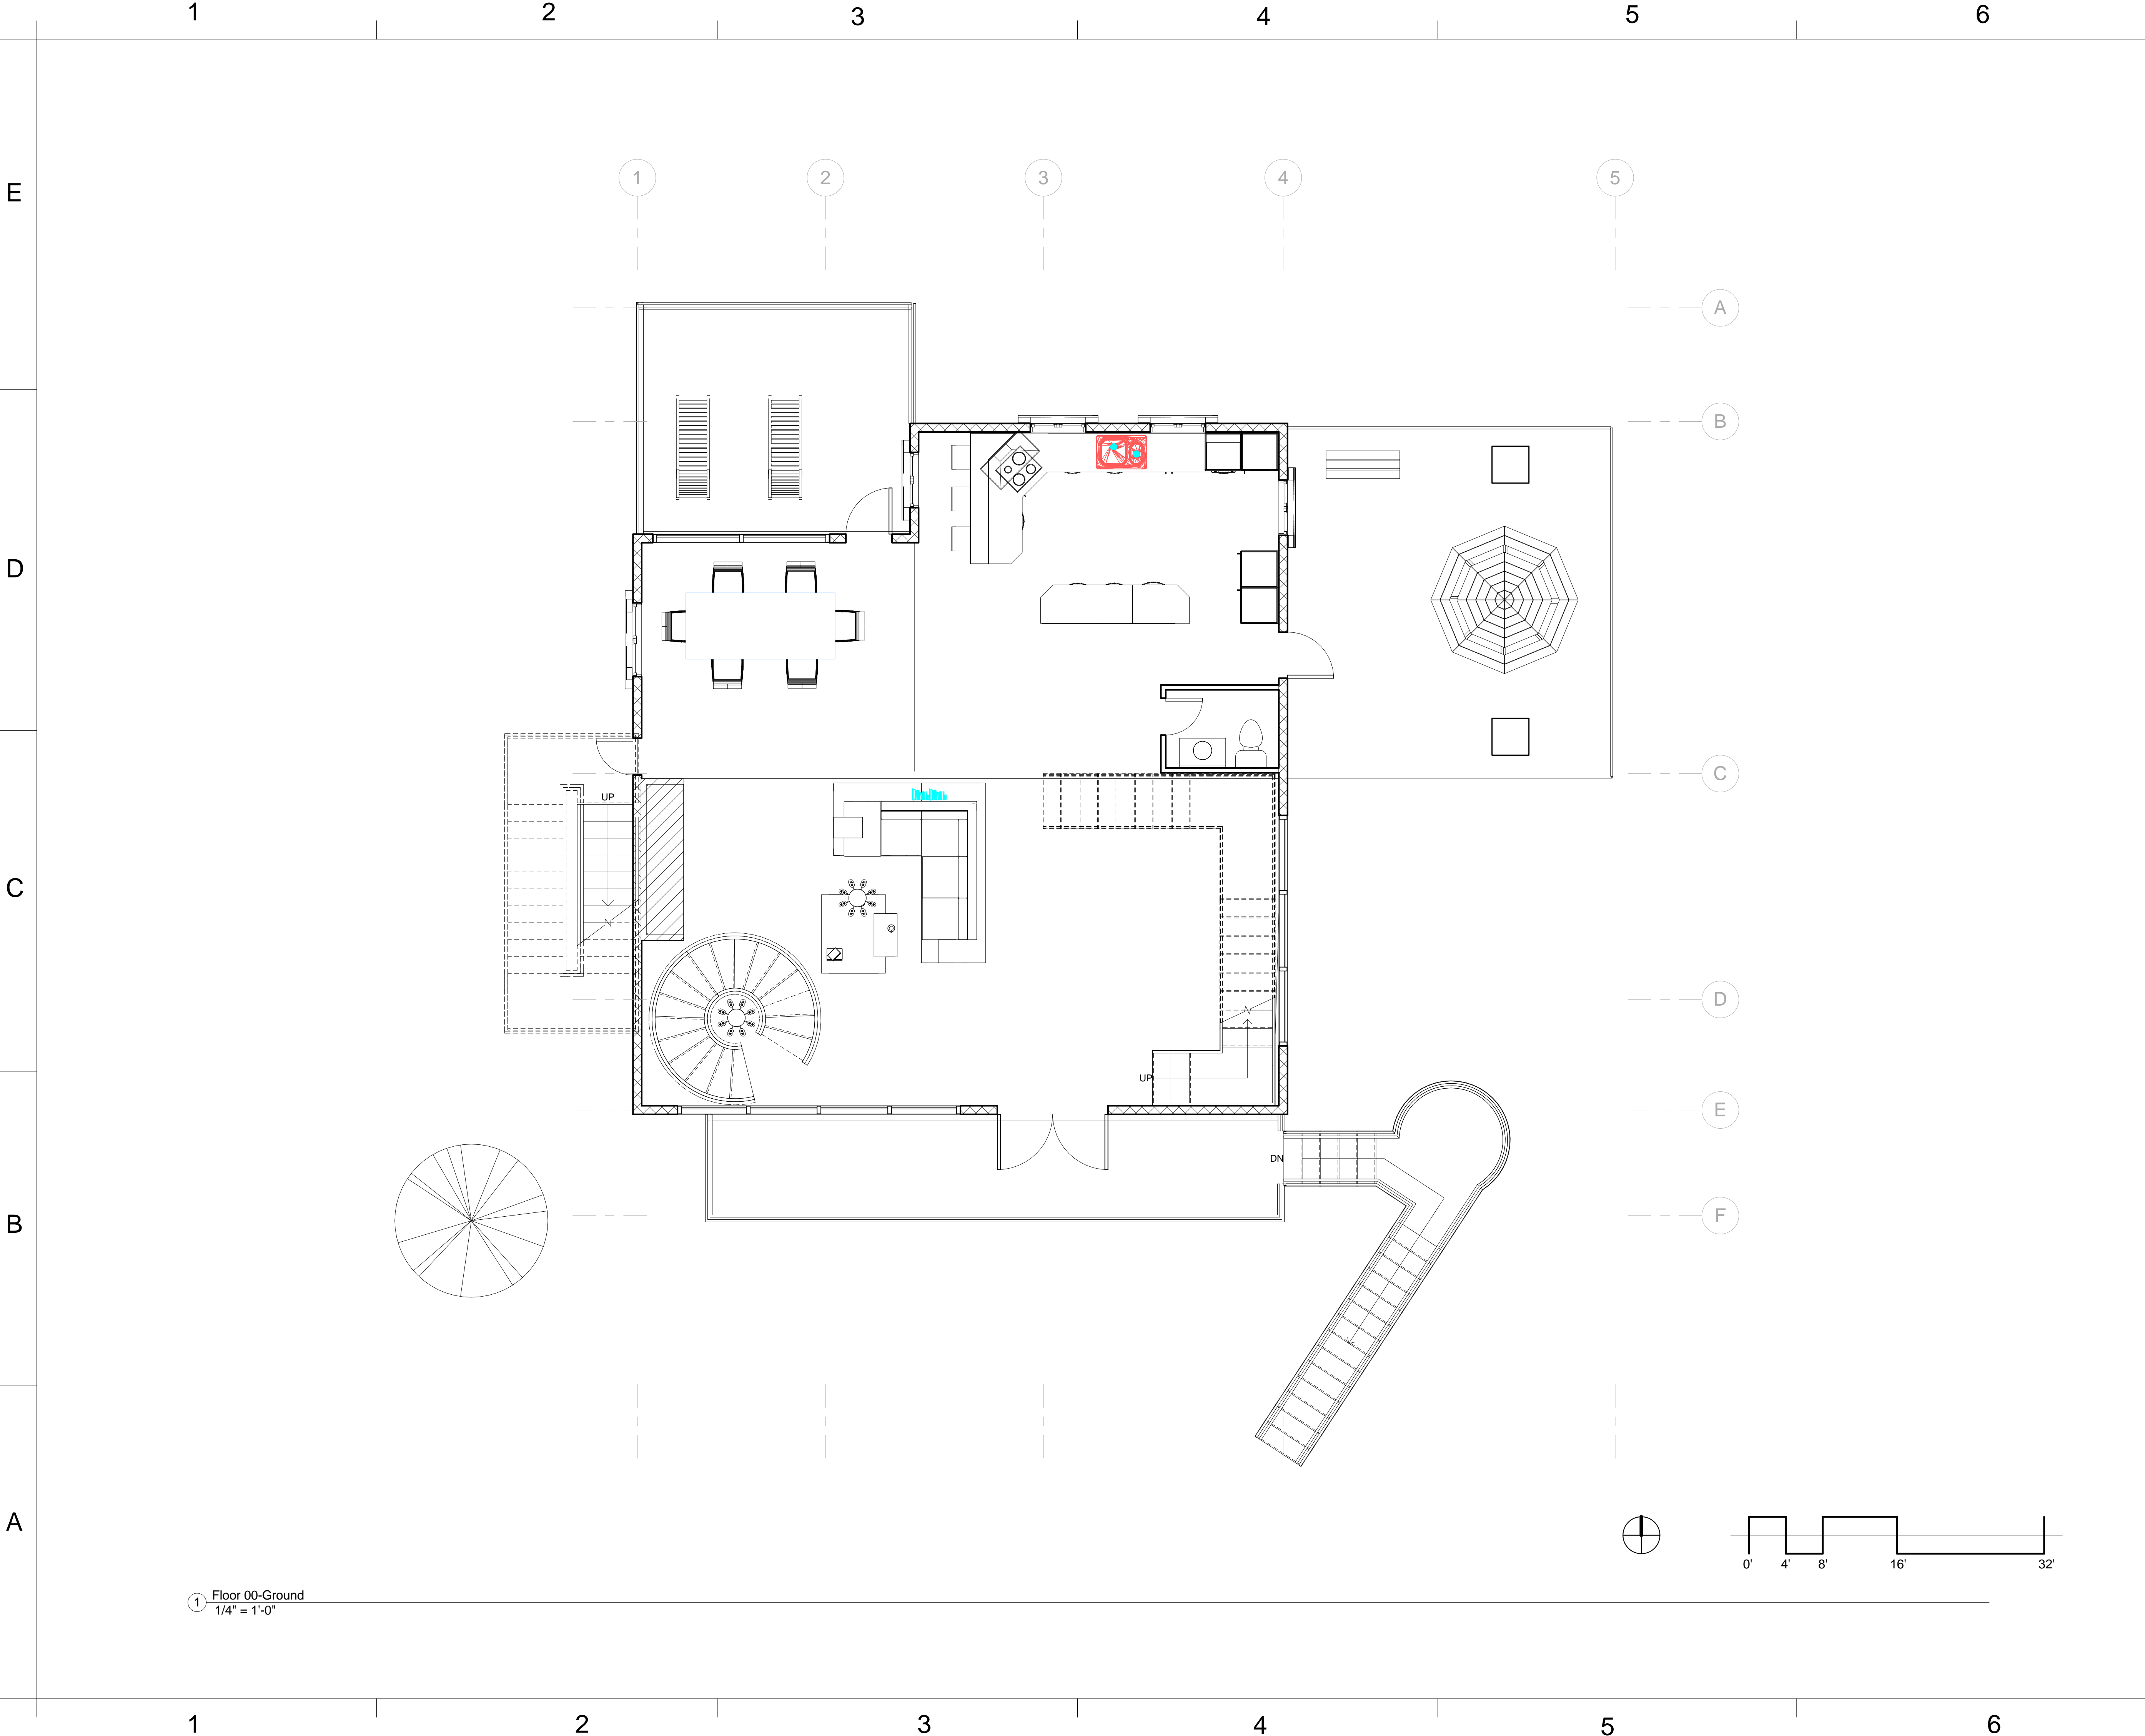

① Floor 00-Ground  
1/4" = 1'-0"

**YH DESIGN**

www.yhdesign.com

Consultant Prof. Christine Wacta  
Address Eichberg Hall  
Phone 912-228-2696

SCAD  
ELDS - 225-07  
FINAL

No.	Description	Date
HW 2B	house by the water	04/15/2013
HW 3	Pre-Final	04/24/2013
HW 4	Pre-Final	05/06/2013
HW 5	Pre-Final	05/13/2013

House by Water


FLOOR PLAN --  
GROUND FLOOR

Project Number	Project Number
Date	May 1st, 2013
Drawn By	Author
Checked By	Prof. Wacta

A 103

Scale	1/4" = 1'-0"
-------	--------------




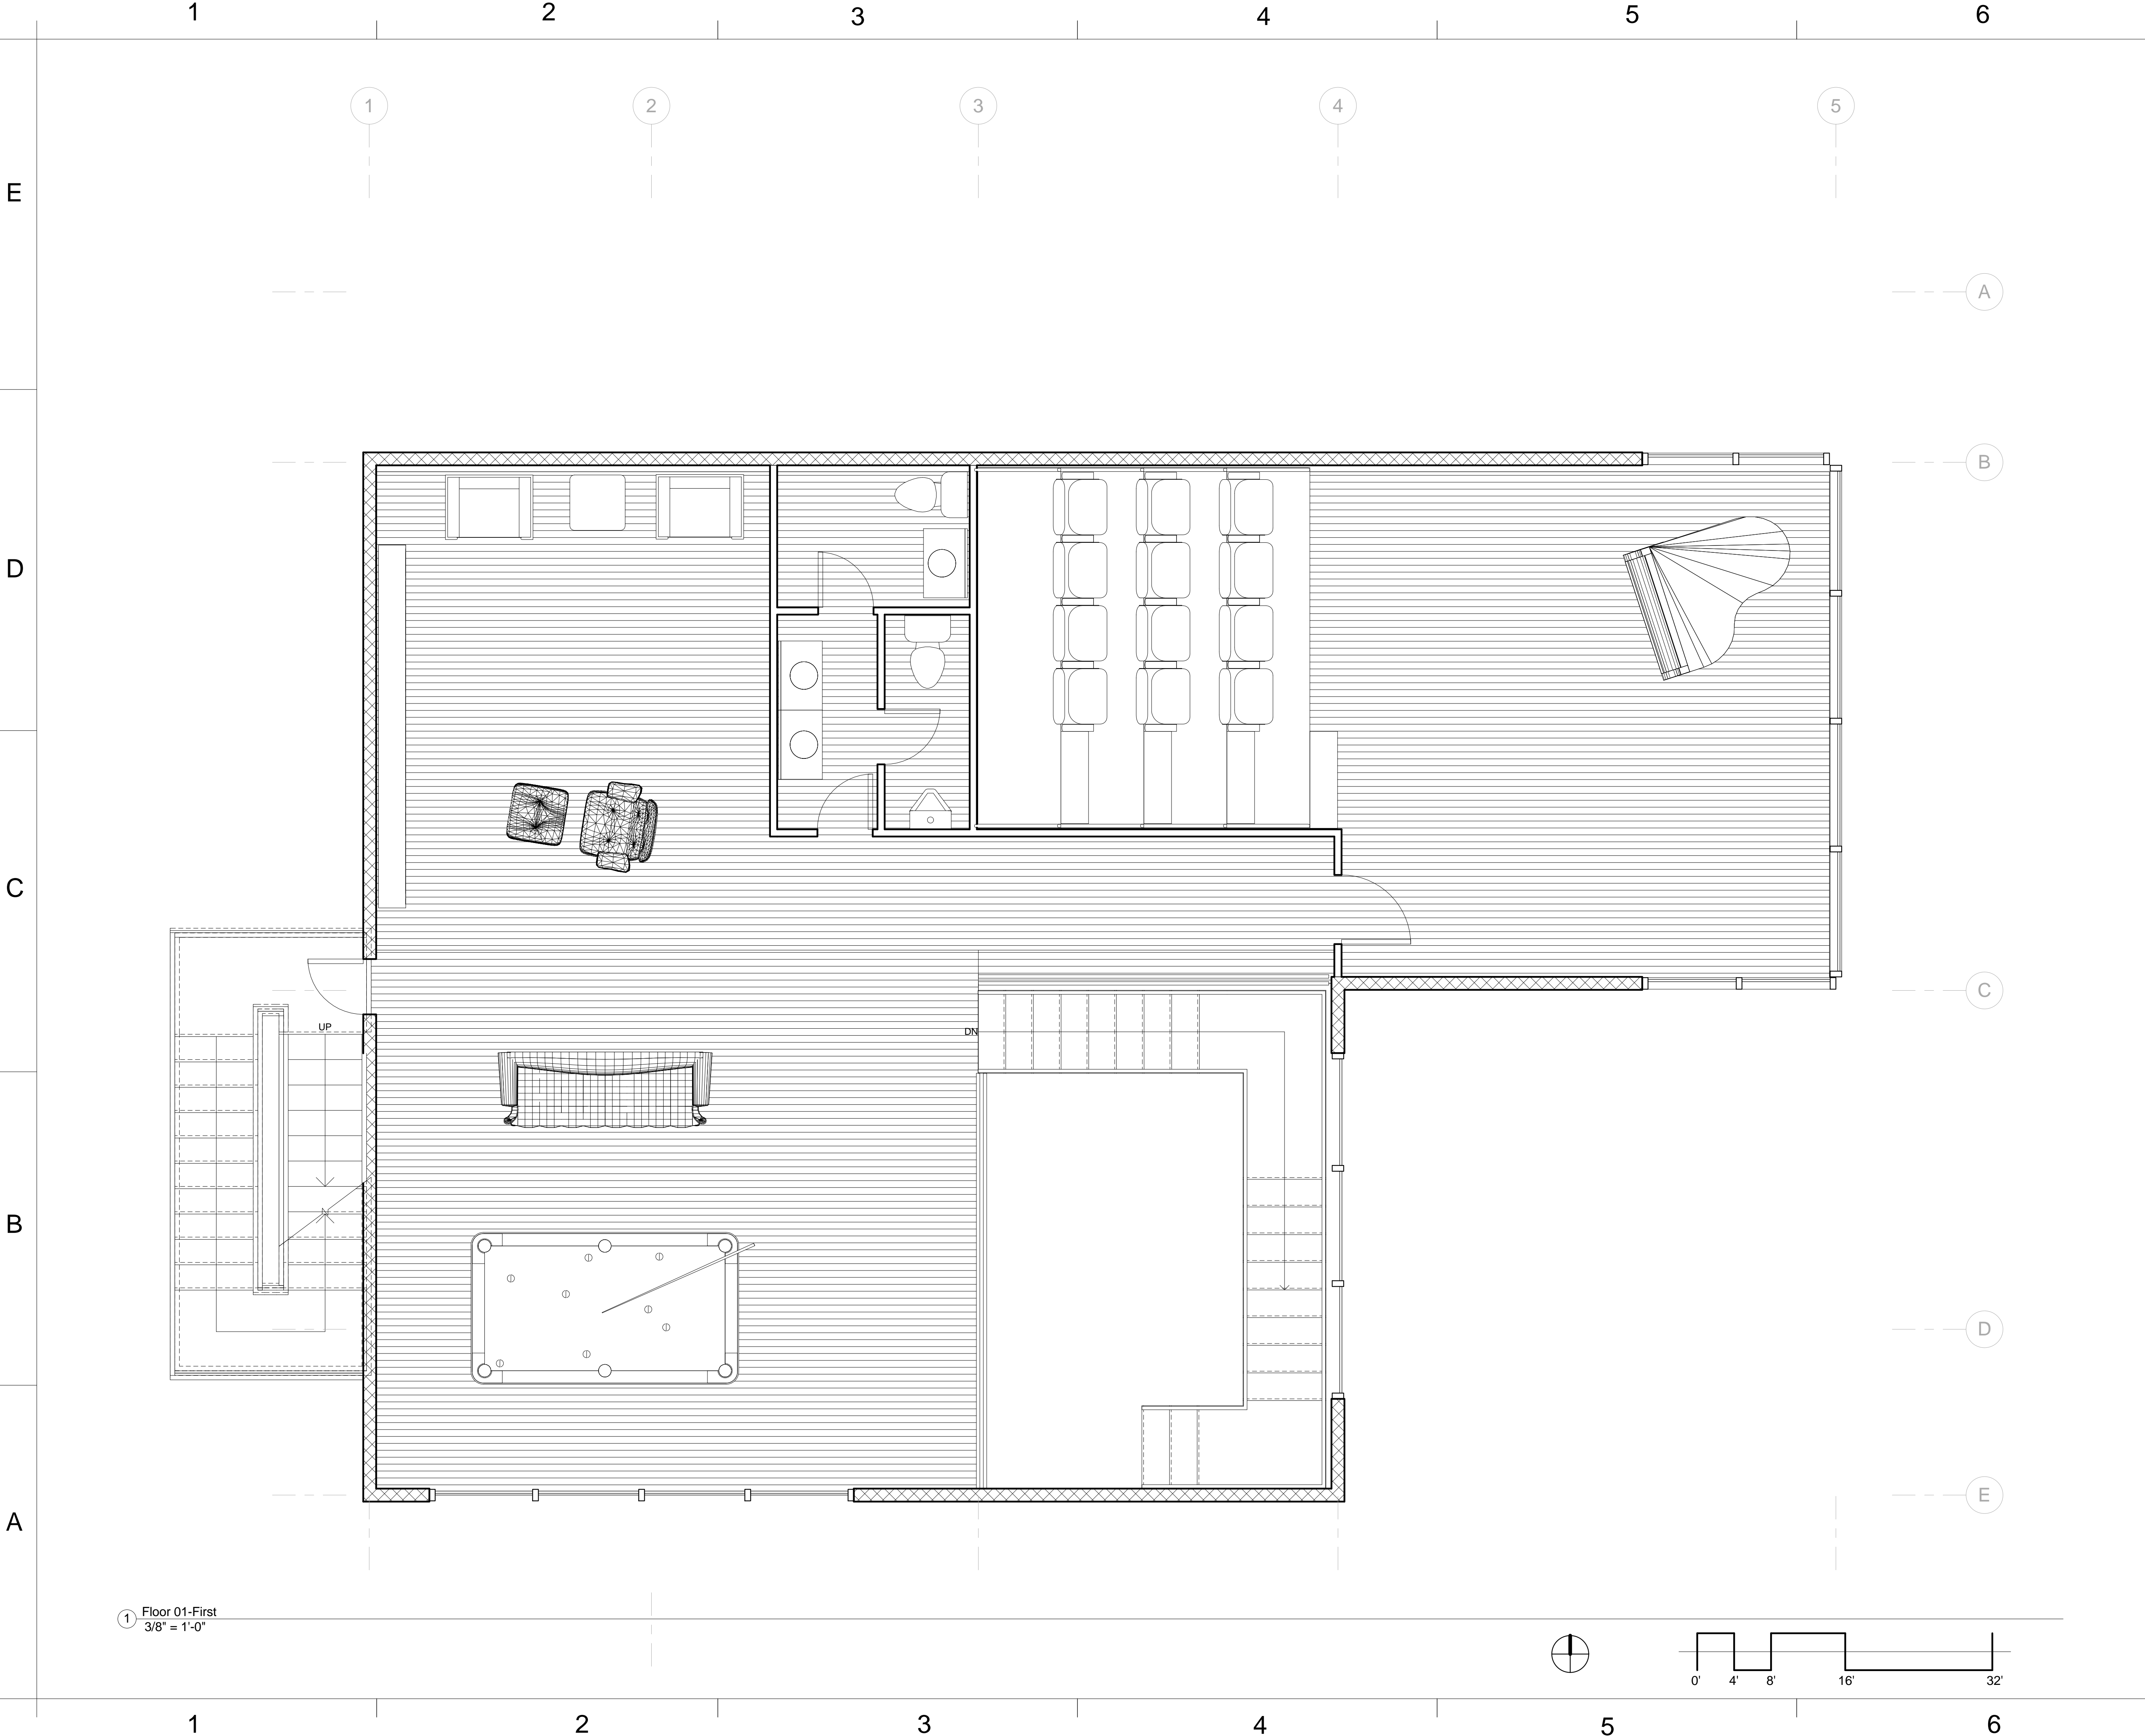

**YH DESIGN**

www.yhdesign.com

Consultant Prof. Christine Wacta  
Address Eichberg Hall  
Phone 912-228-2696

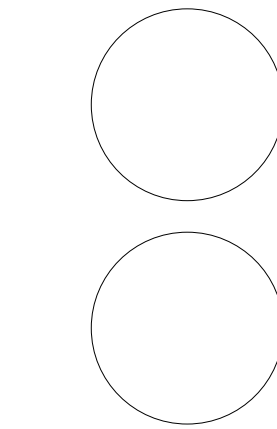

**SCAD  
ELDS - 225-07  
FINAL**

No.	Description	Date
HW 2B	house by the water	04/15/2013
HW 3	Pre-Final	04/24/2013
HW 4	Pre-Final	05/06/2013
HW 5	Pre- Final	05/13/2013

House by Water


**FLOOR PLAN --  
FIRST FLOOR**

Project Number	Project Number
Date	May 1st, 2013
Drawn By	Yun Huang
Checked By	Prof. Wacta

**A 104**

Scale 3/8" = 1'-0"



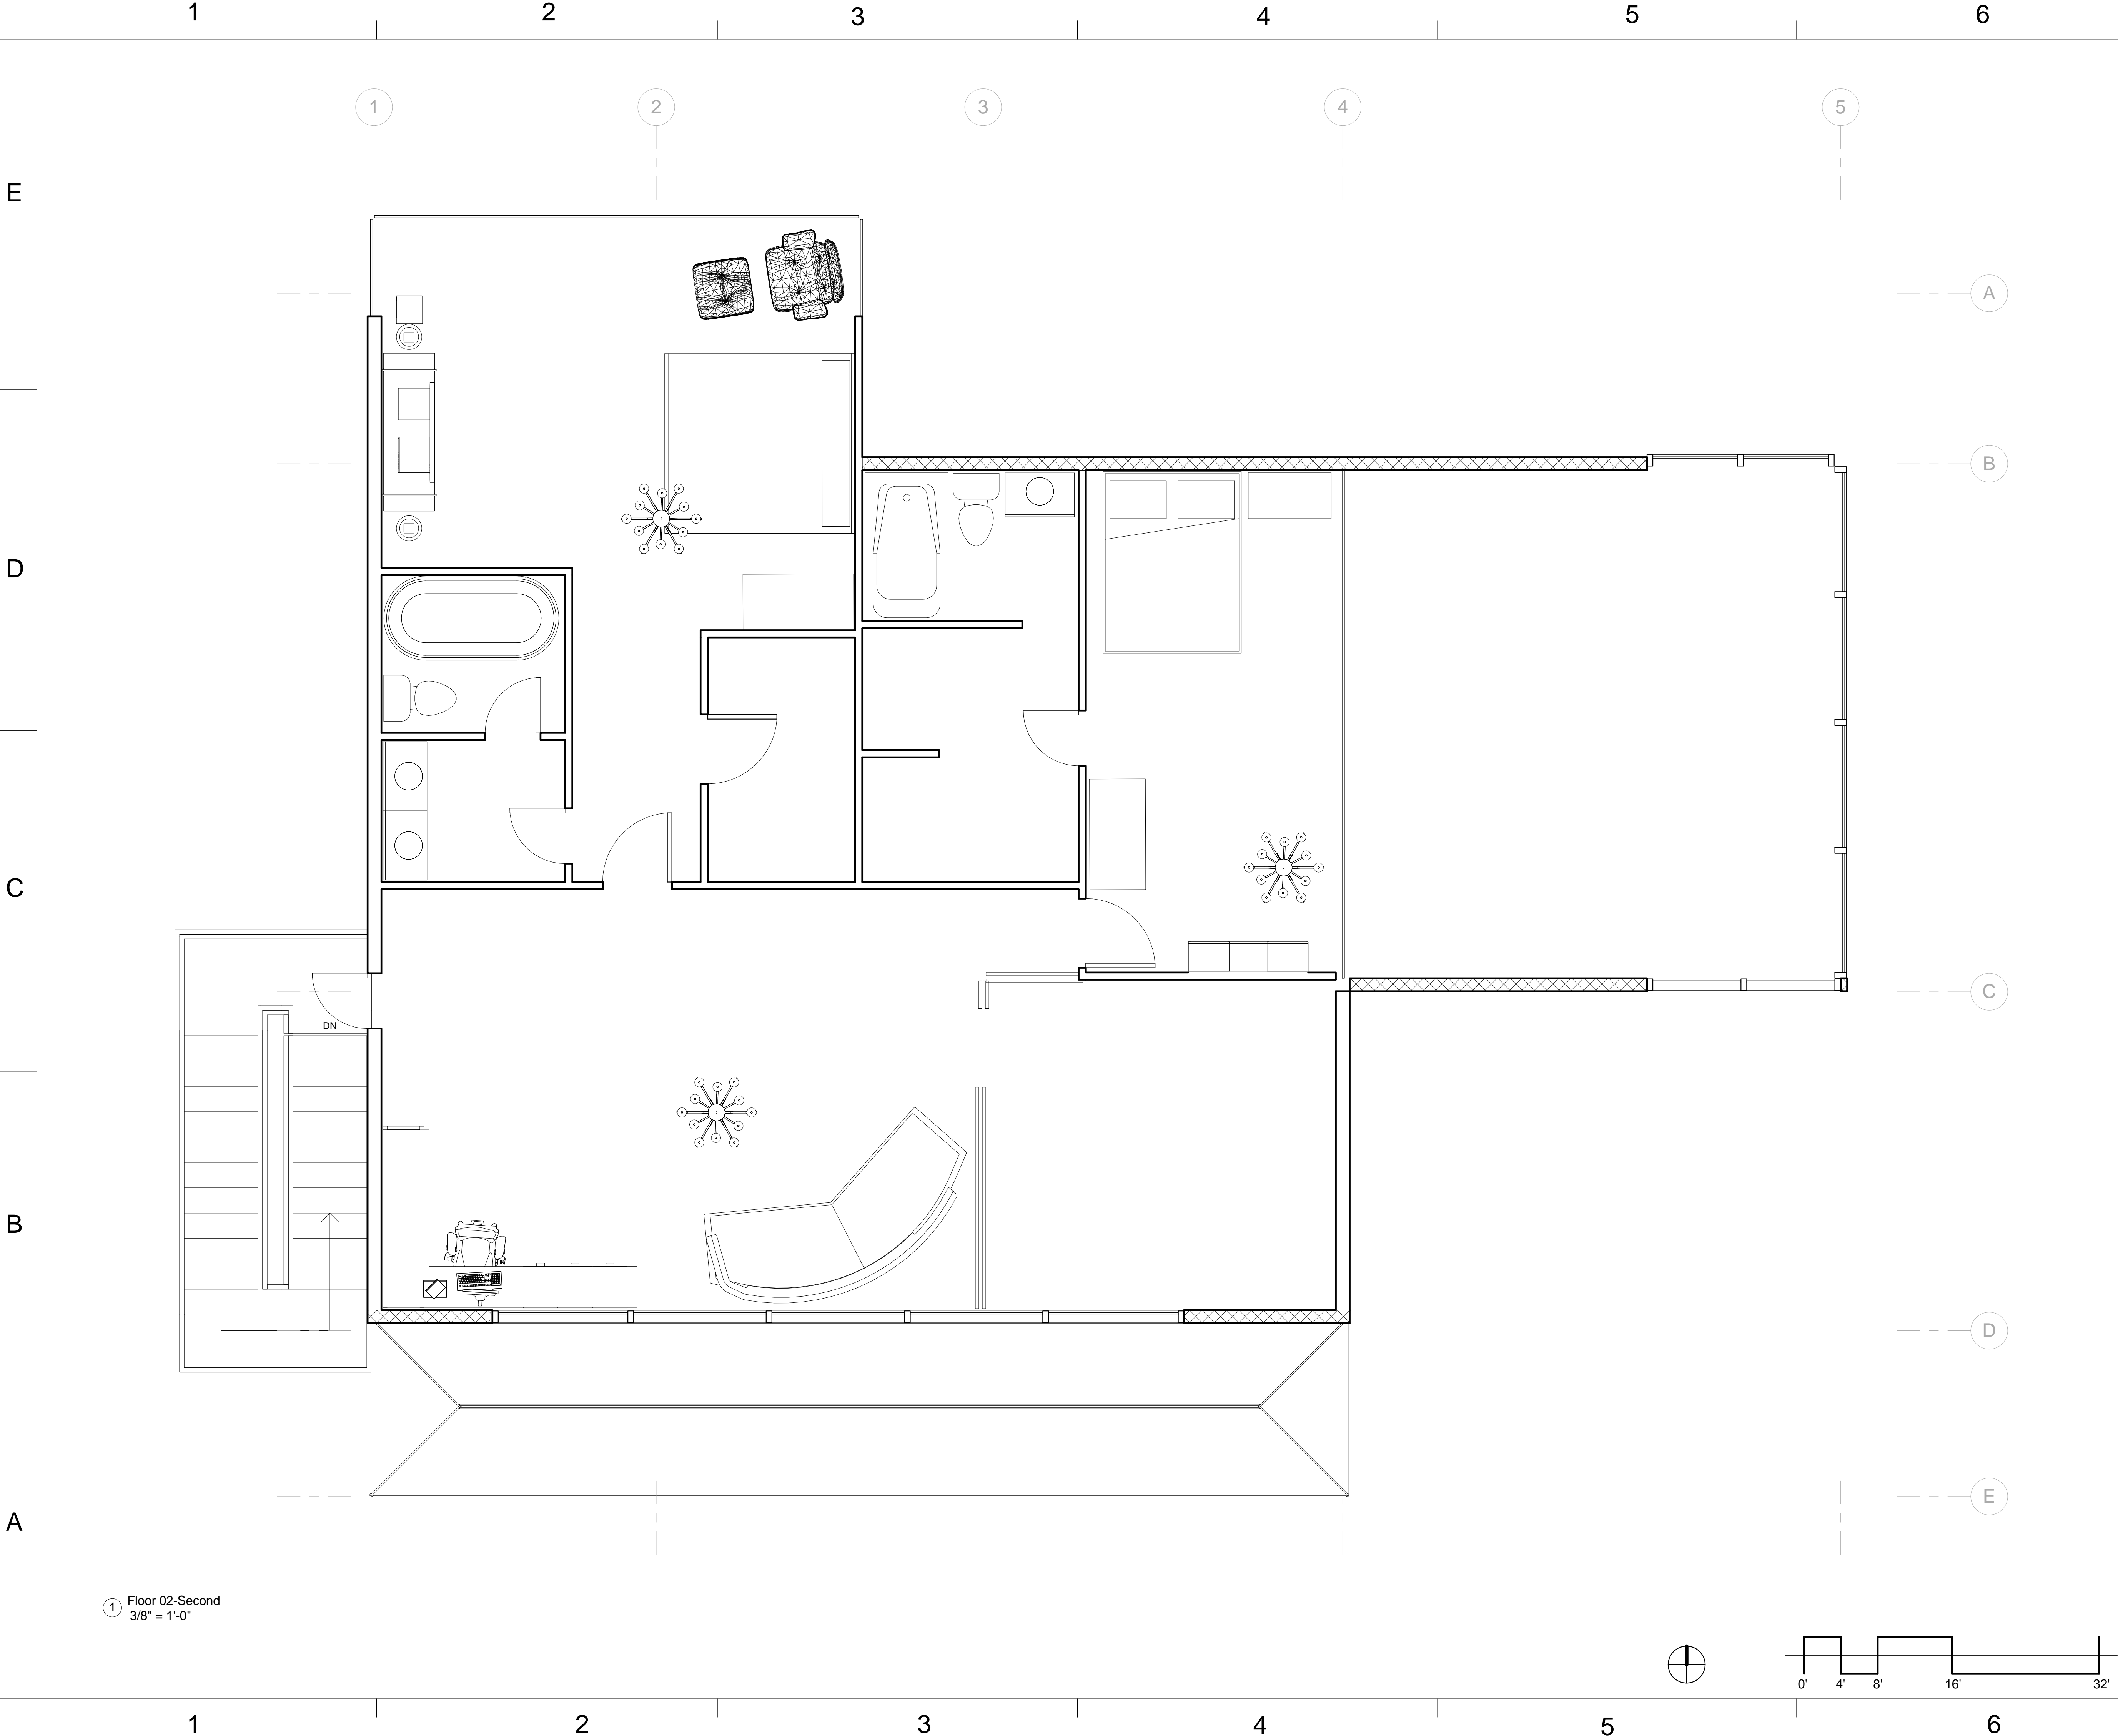

① Floor 02-Second  
3/8" = 1'-0"

**YH DESIGN**

www.yhdesign.com

Consultant Prof. Christine Wacta  
Address Eichberg Hall  
Phone 912-228-2696

**SCAD  
ELDS - 225-07  
FINAL**

No.	Description	Date
HW 2B	house by the water	04/15/2013
HW 3	Pre-Final	04/24/2013
HW 4	Pre-Final	05/06/2013
HW 5	Pre- Final	05/13/2013

**House by Water**

**FLLOR PLAN --  
SECOND FLOOR**

Project Number	Project Number
Date	May 1st, 2013
Drawn By	Yun Huang
Checked By	Checker

**A 105**

Scale 3/8" = 1'-0"





 
Lighting Legend




5 Light Bell Glass Chandelier



Downlight - Sport




Artichoke Pendant Light Copper

 


Tri - Color Pendant Light Fixxture



Bubble Chandelier Light

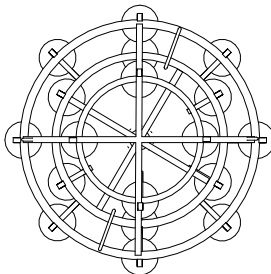



Wrough Iron Lighting Fixture

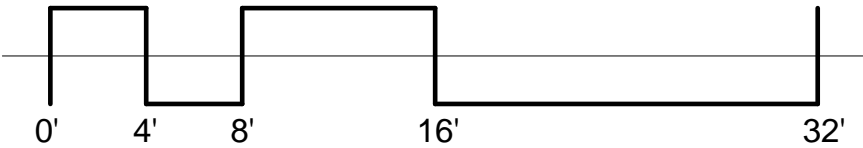

**YH DESIGN**

www.yhdesign.com

Consultant Prof. Christine Wacta  
Address Eichberg Hall  
Phone 912-228-2696

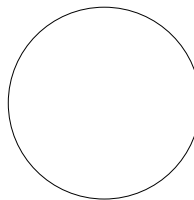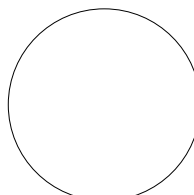

SCAD  
ELDS - 225-07  
FINAL

No.	Description	Date
HW 2B	house by the water	04/15/2013
HW 3	Pre-Final	04/24/2013
HW 4	Pre-Final	05/06/2013
HW 5	Pre- Final	05/13/2013

House by Water


CEILING PLANS

Project Number	Project Number
Date	May 1st, 2013
Drawn By	Author
Checked By	Prof. Wacta

A 106

Scale	As indicated
-------	--------------




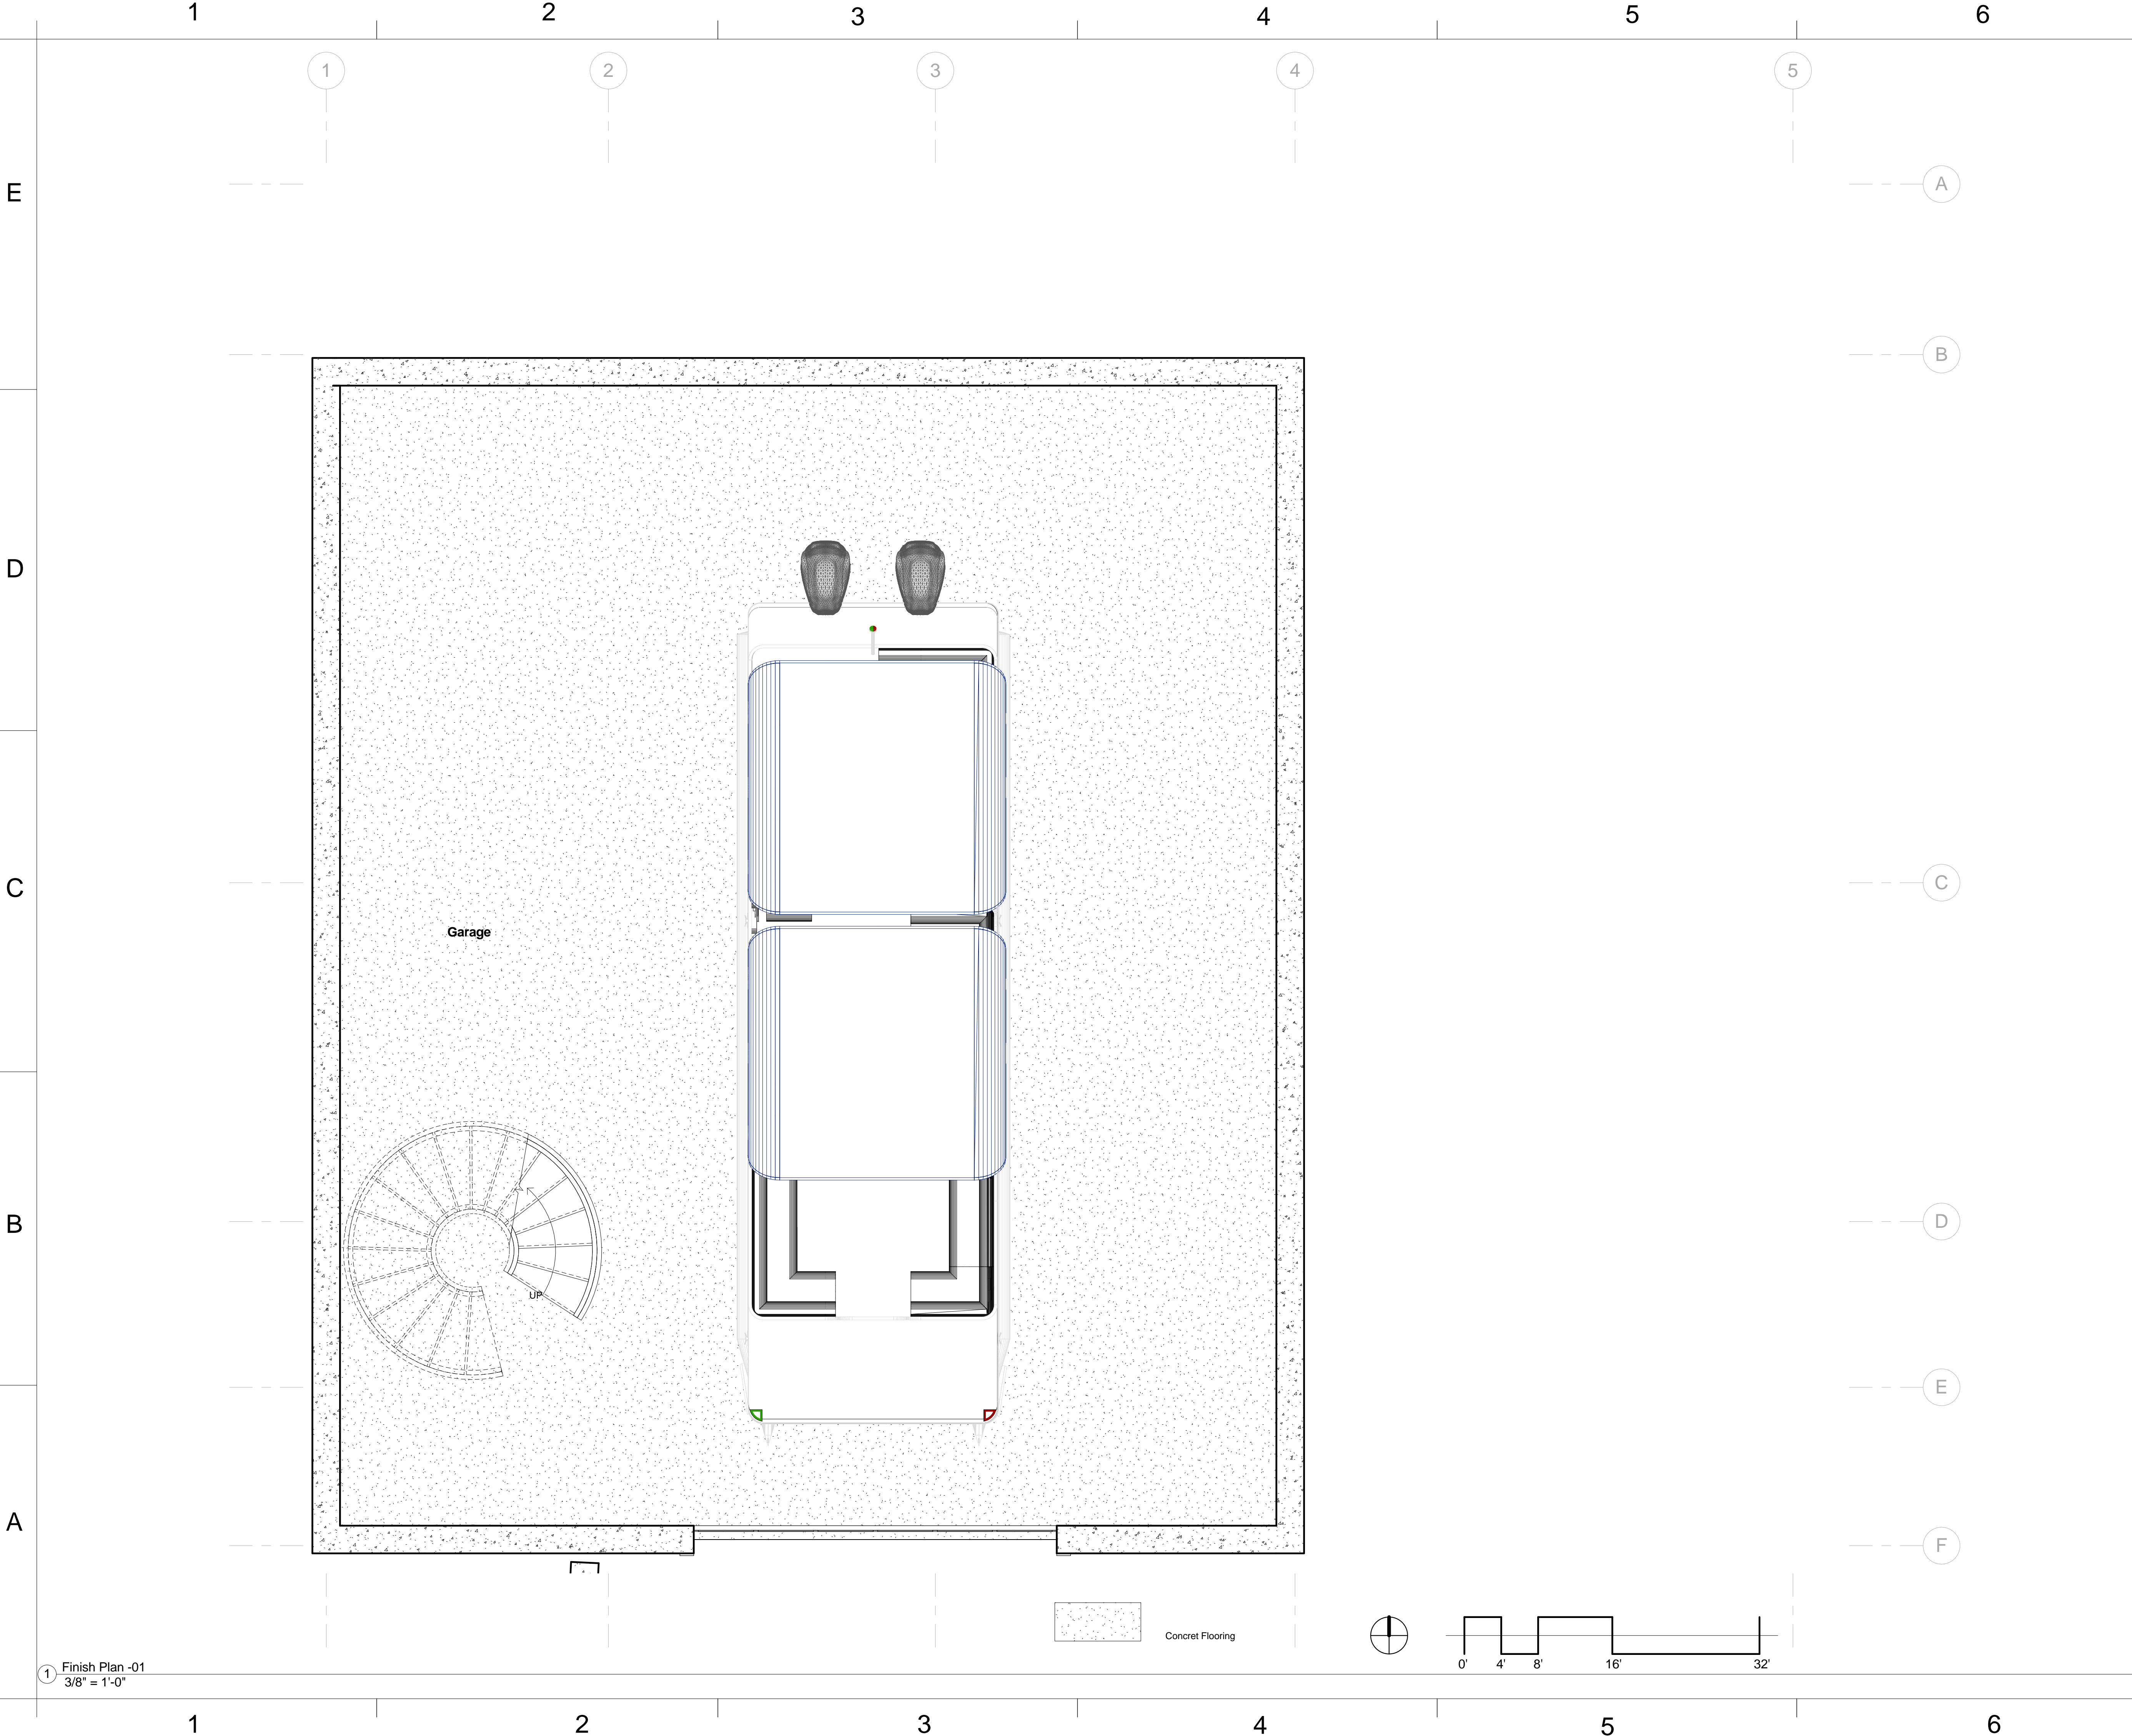

**YH DESIGN**

www.yhdesign.com

Consultant Prof. Christine Wacta  
Address Eichberg Hall  
Phone 912-228-2696

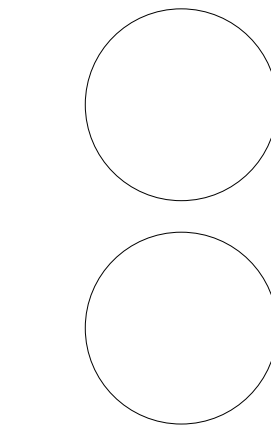

**SCAD  
ELDS - 225-07  
FINAL**

No.	Description	Date
HW 2B	house by the water	04/15/2013
HW 3	Pre-Final	04/24/2013
HW 4	Pre-Final	05/06/2013
HW 5	Pre- Final	05/13/2013

House by Water


**FINISH FLOOR  
PLAN --  
BASEMENT 1**

Project Number	Project Number
Date	May 1st, 2013
Drawn By	Author
Checked By	Prof. Wacta

**A 107**

Scale	As indicated
-------	--------------




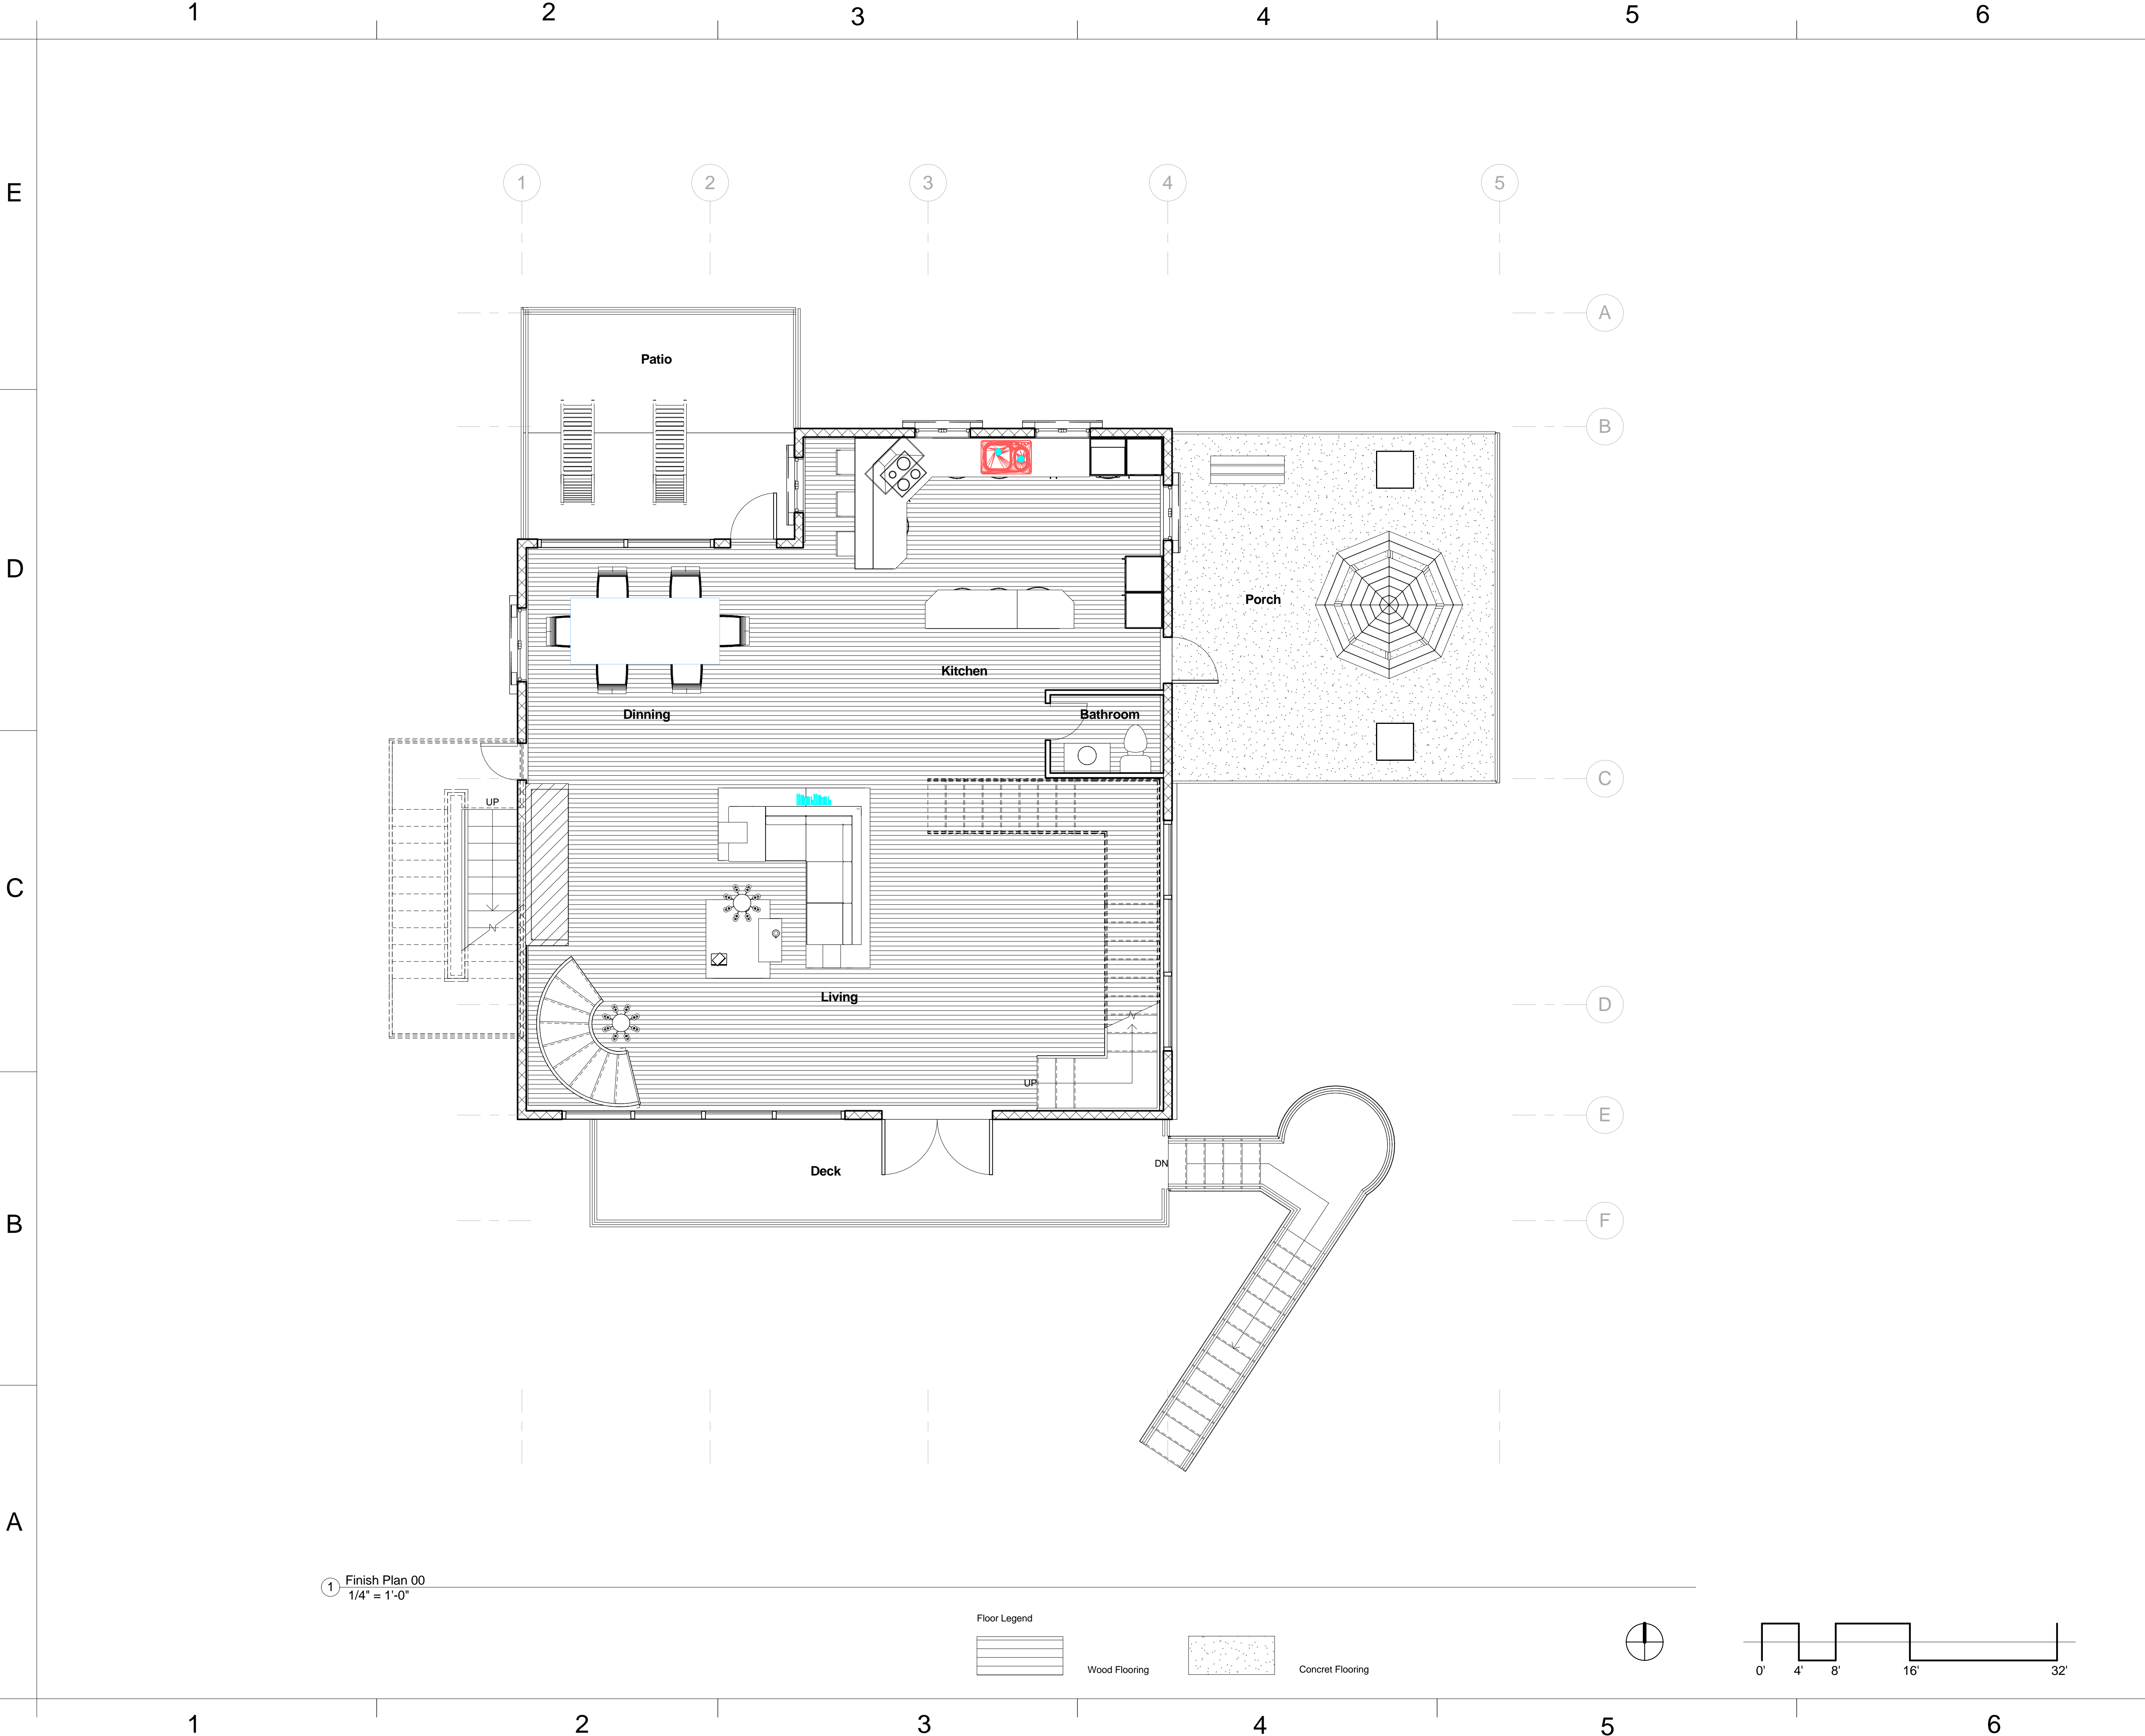


① Finish Plan 00  
1/4" = 1'-0"

Floor Legend

Wood Flooring

 
Concrete Flooring

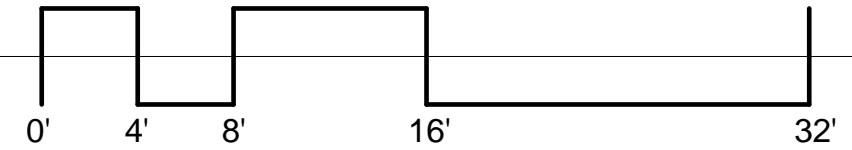

**YH DESIGN**

www.yhdesign.com

Consultant Prof. Christine Wacta  
Address Eichberg Hall  
Phone 912-228-2696

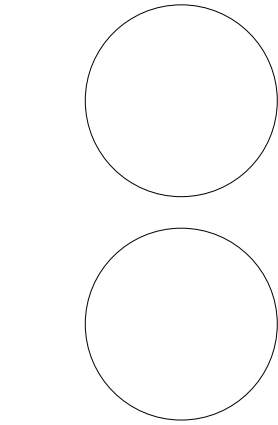

SCAD  
ELDS - 225-07  
FINAL

No.	Description	Date
HW 2B	house by the water	04/15/2013
HW 3	Pre-Final	04/24/2013
HW 4	Pre-Final	05/06/2013
HW 5	Pre- Final	05/13/2013

House by Water


FINISH FLOOR  
PLAN -- GROUND  
FLOOR

Project Number	Project Number
Date	May 1st, 2013
Drawn By	Yun Huang
Checked By	Prof. Wacta

A 108

Scale 1/4" = 1'-0"



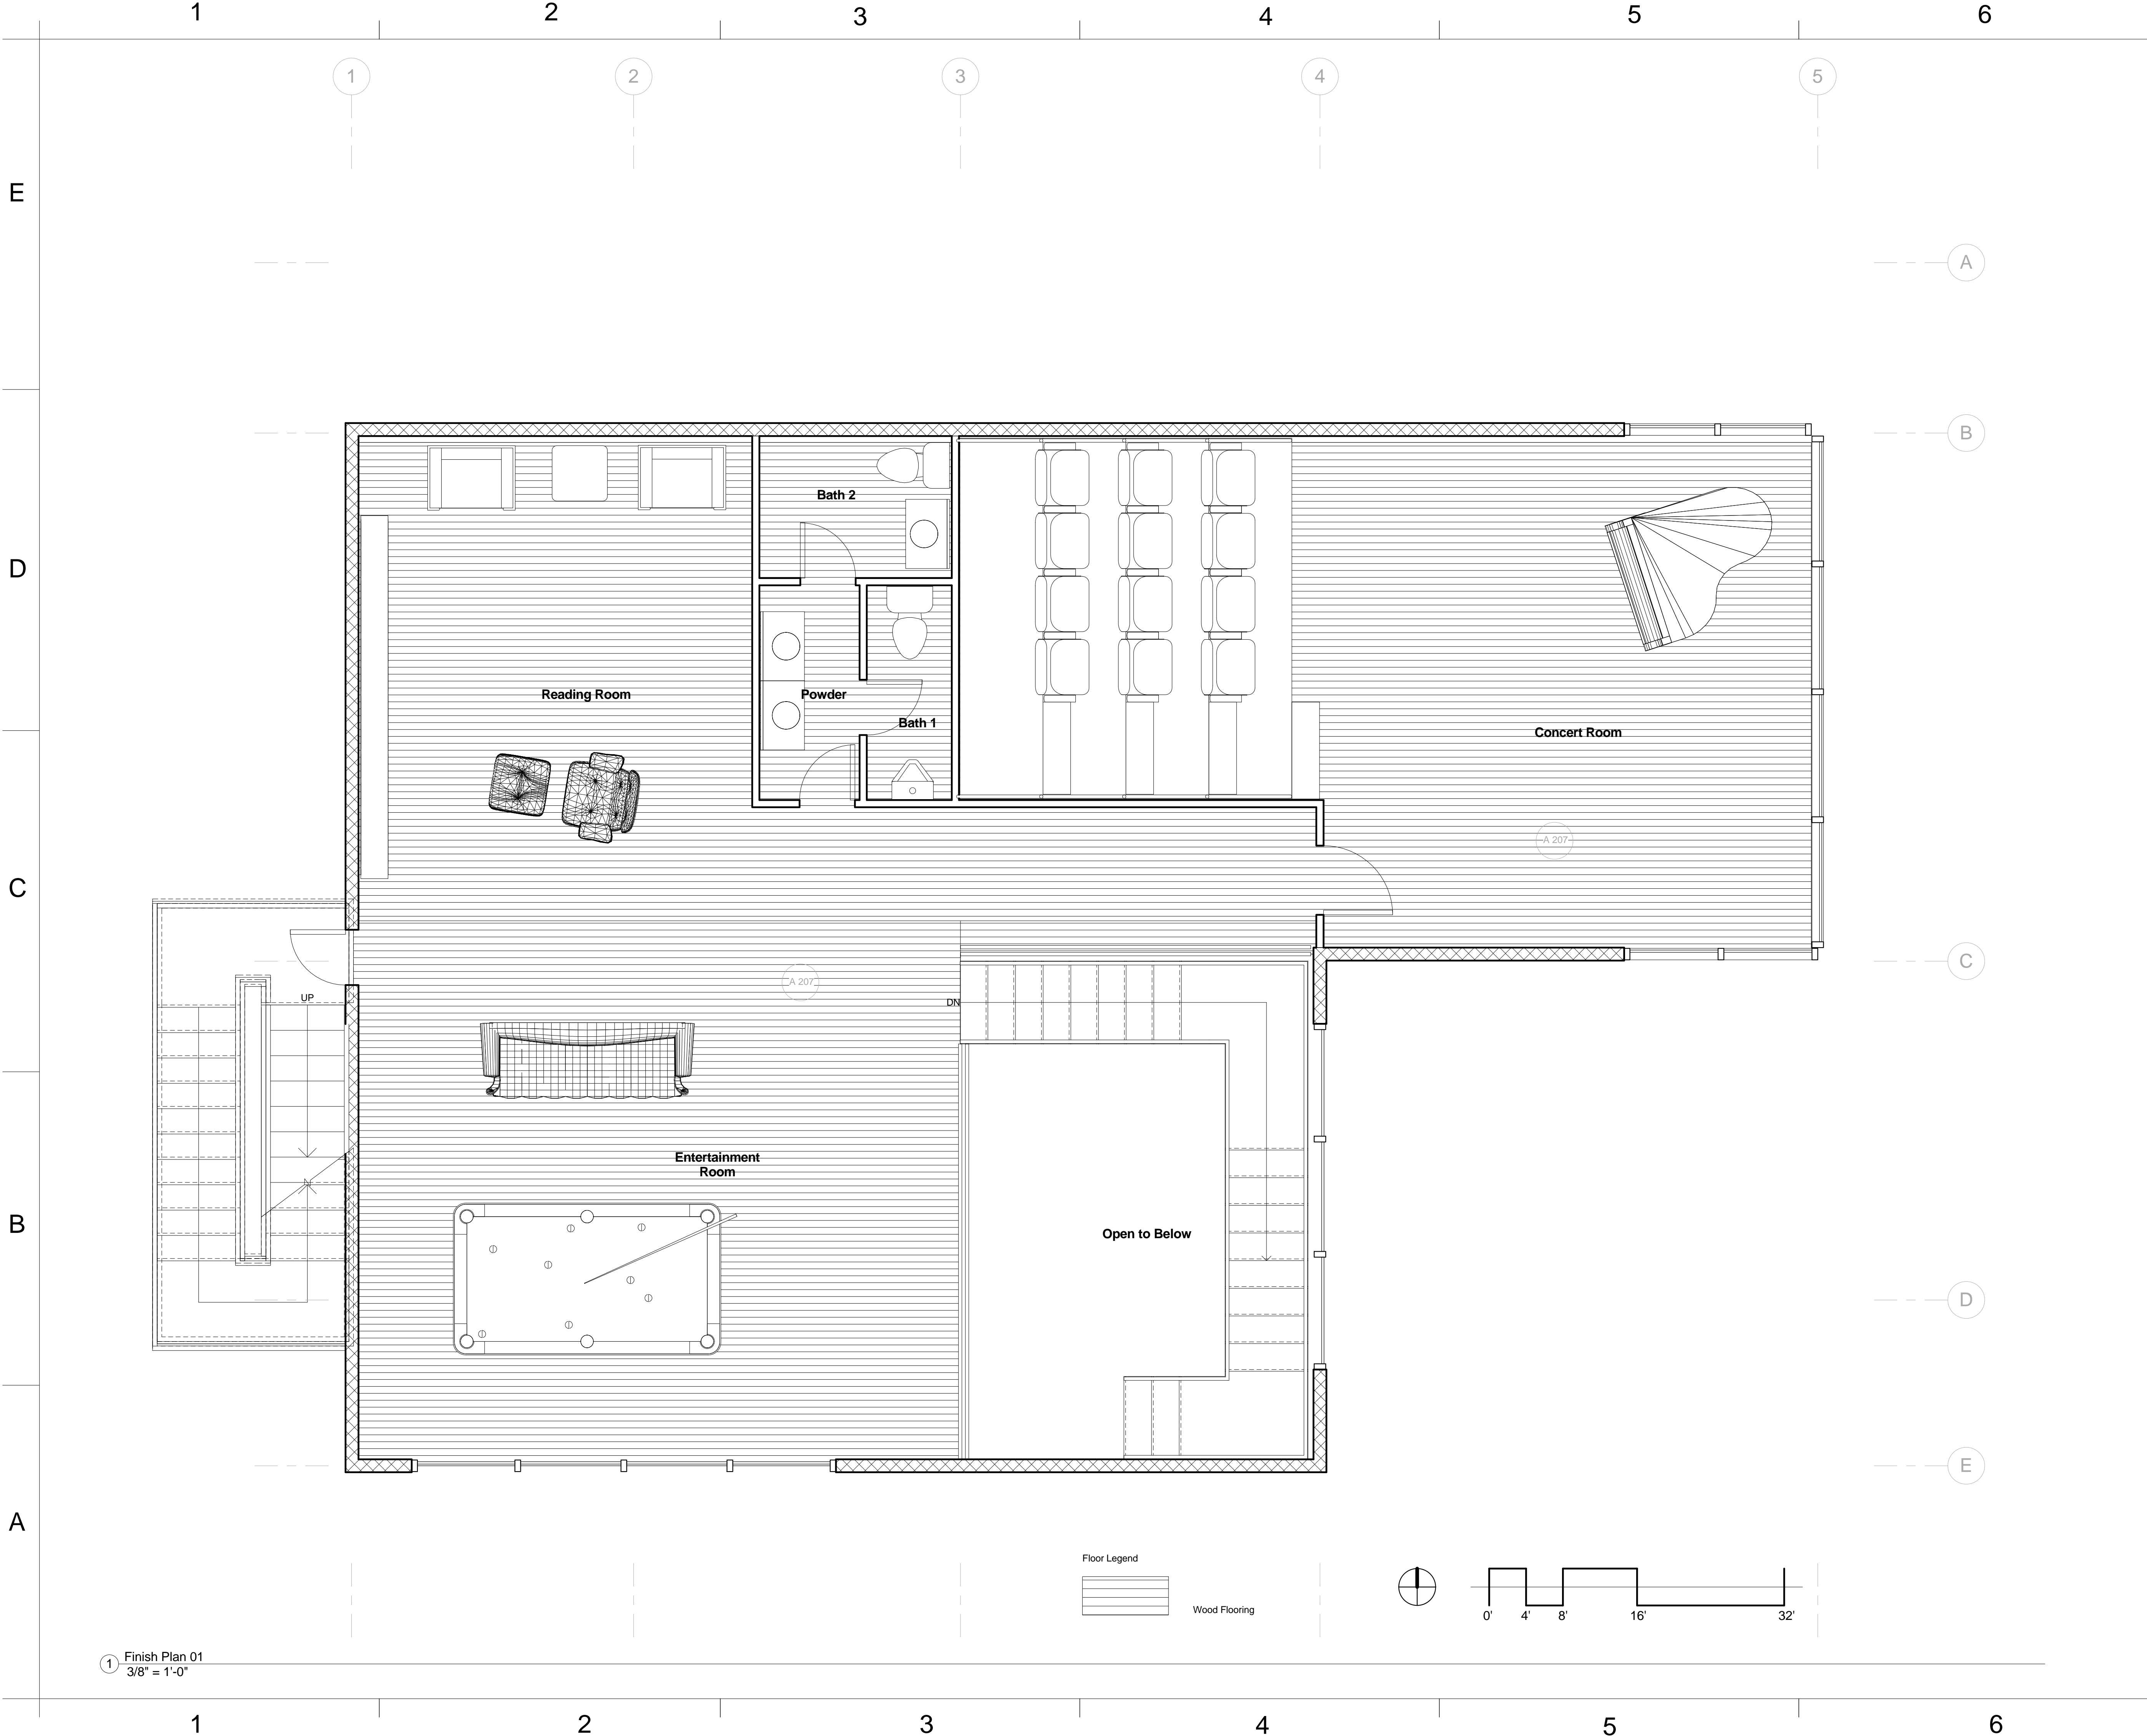

① Finish Plan 01  
3/8" = 1'-0"

**YH DESIGN**

www.yhdesign.com

Consultant Prof. Christine Wacta  
Address Eichberg Hall  
Phone 912-228-2696

**SCAD  
ELDS - 225-07  
FINAL**

No.	Description	Date
HW 2B	house by the water	04/15/2013
HW 3	Pre-Final	04/24/2013
HW 4	Pre-Final	05/06/2013
HW 5	Pre- Final	05/13/2013

**House by Water**


**FINISH FLOOR  
PLAN -- FIRST  
FLOOR**

Project Number	Project Number
Date	May 1st, 2013
Drawn By	Yun Huang
Checked By	Prof. Wacta

**A 109**

Scale	As indicated
-------	--------------



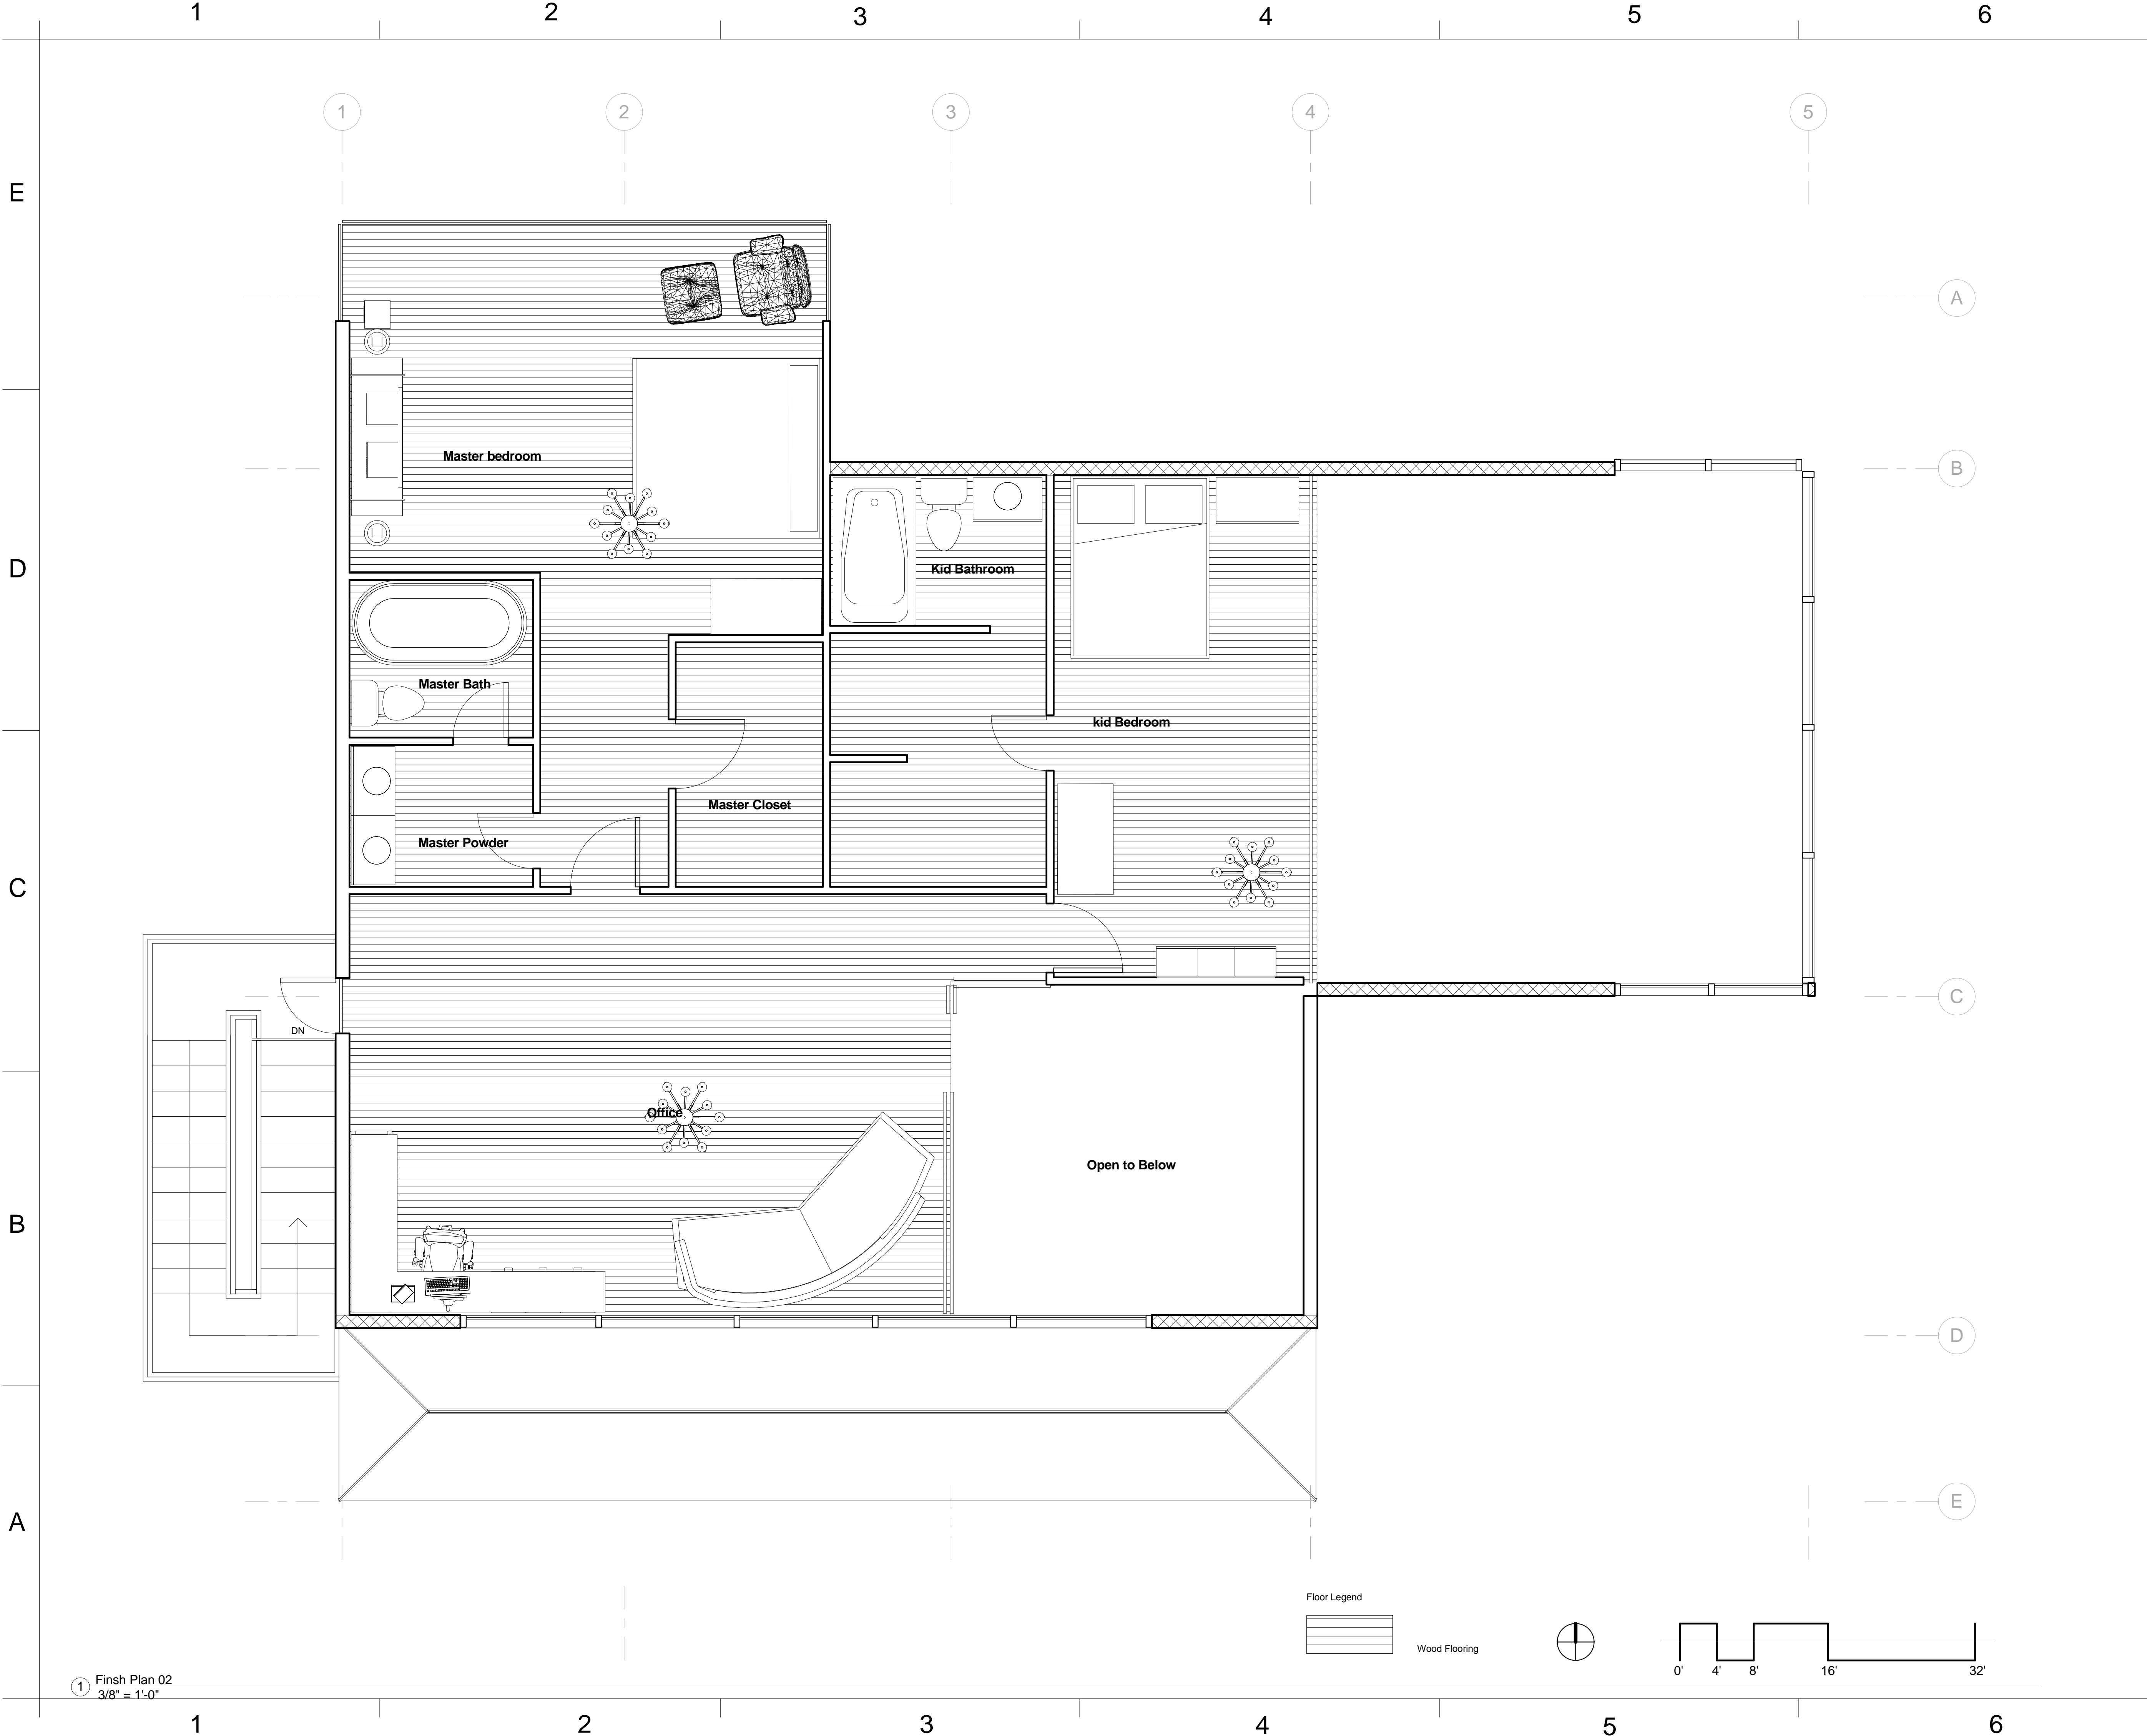

① Finish Plan 02  
3/8" = 1'-0"

**YH DESIGN**

www.yhdesign.com

Consultant Prof. Christine Wacta  
Address Eichberg Hall  
Phone 912-228-2696

**SCAD  
ELDS - 225-07  
FINAL**

No.	Description	Date
HW 2B	house by the water	04/15/2013
HW 3	Pre-Final	04/24/2013
HW 4	Pre-Final	05/06/2013
HW 5	Pre-Final	05/13/2013

House by Water


**FINISH FLOOR  
PLAN -- SECOND  
FLOOR**

Project Number	Project Number
Date	May 1st, 2013
Drawn By	Yun Huang
Checked By	Prof. Wacta

**A 110**

Scale As indicated




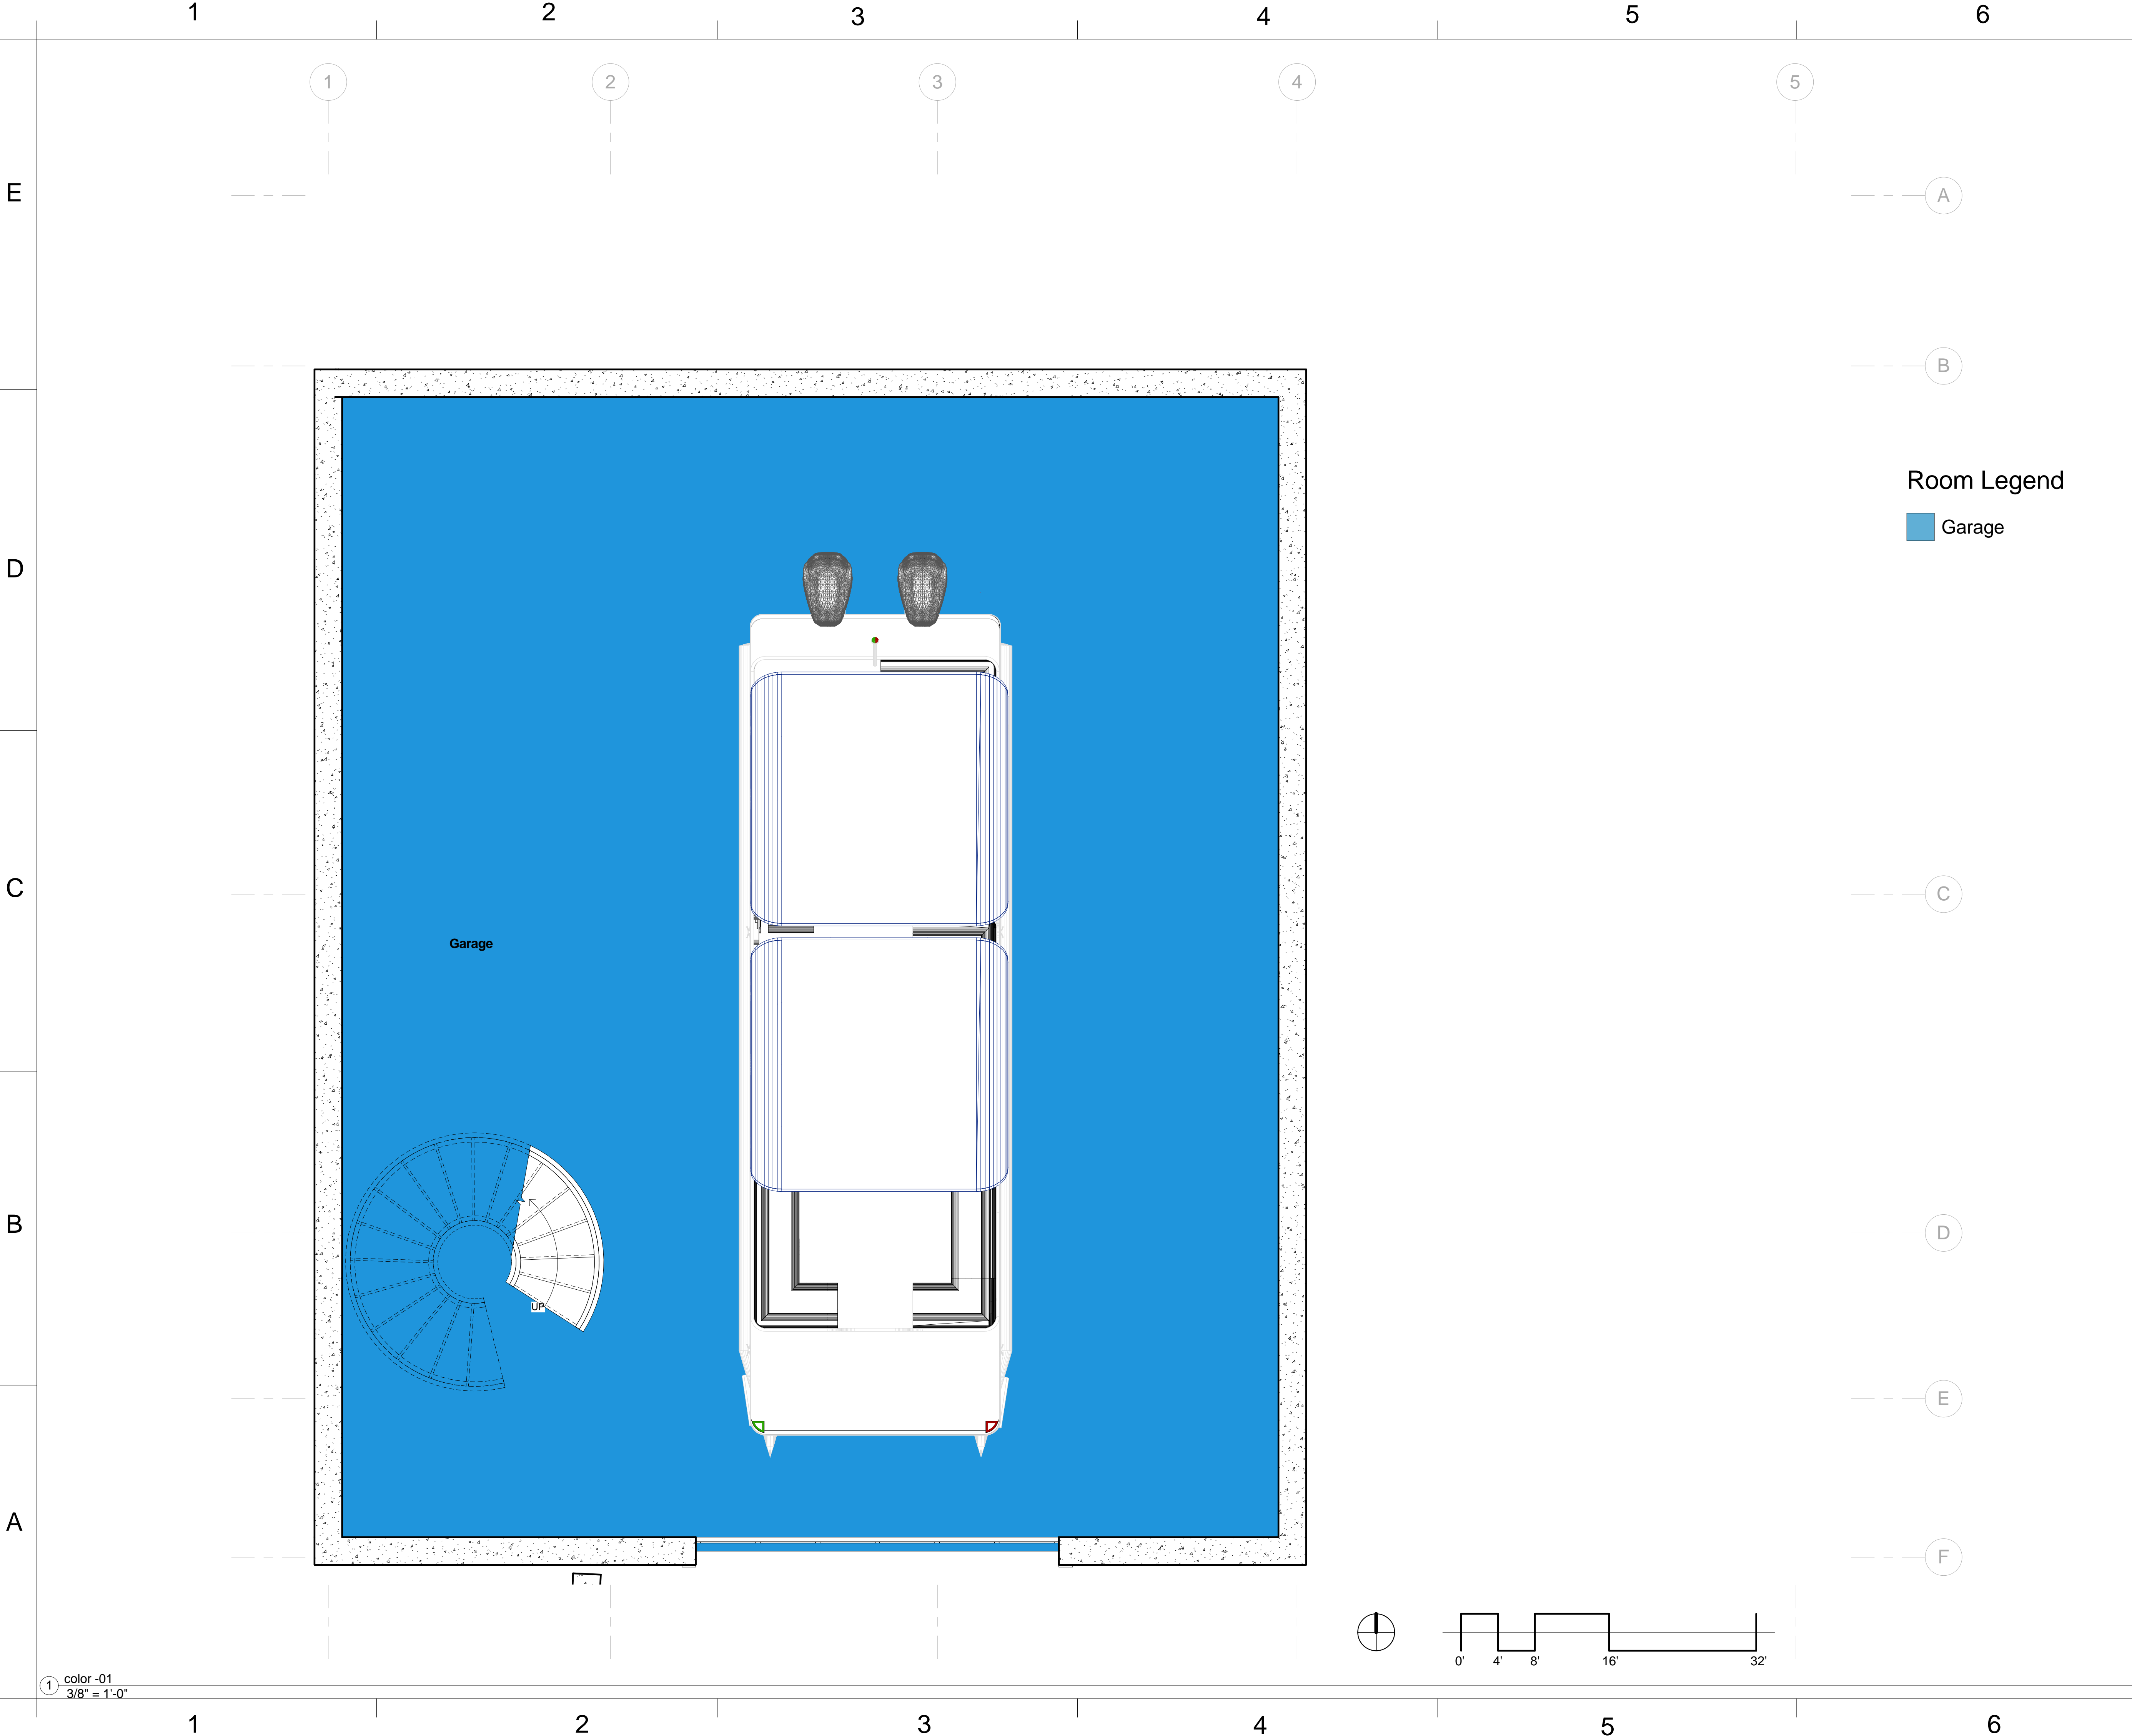

**YH DESIGN**

www.yhdesign.com

Consultant Prof. Christine Wacta  
Address Eichberg Hall  
Phone 912-228-2696

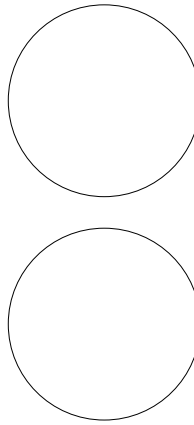

**SCAD  
ELDS - 225-07  
FINAL**

No.	Description	Date
HW 2B	house by the water	04/15/2013
HW 3	Pre-Final	04/24/2013
HW 4	Pre-Final	05/06/2013
HW 5	Pre- Final	05/13/2013

House by Water


**COLORED  
BASEMENT**

Project Number	Project Number
Date	May 1st, 2013
Drawn By	Yun Huang
Checked By	Prof. Wacta

**A 111**

Scale	3/8" = 1'-0"
-------	--------------



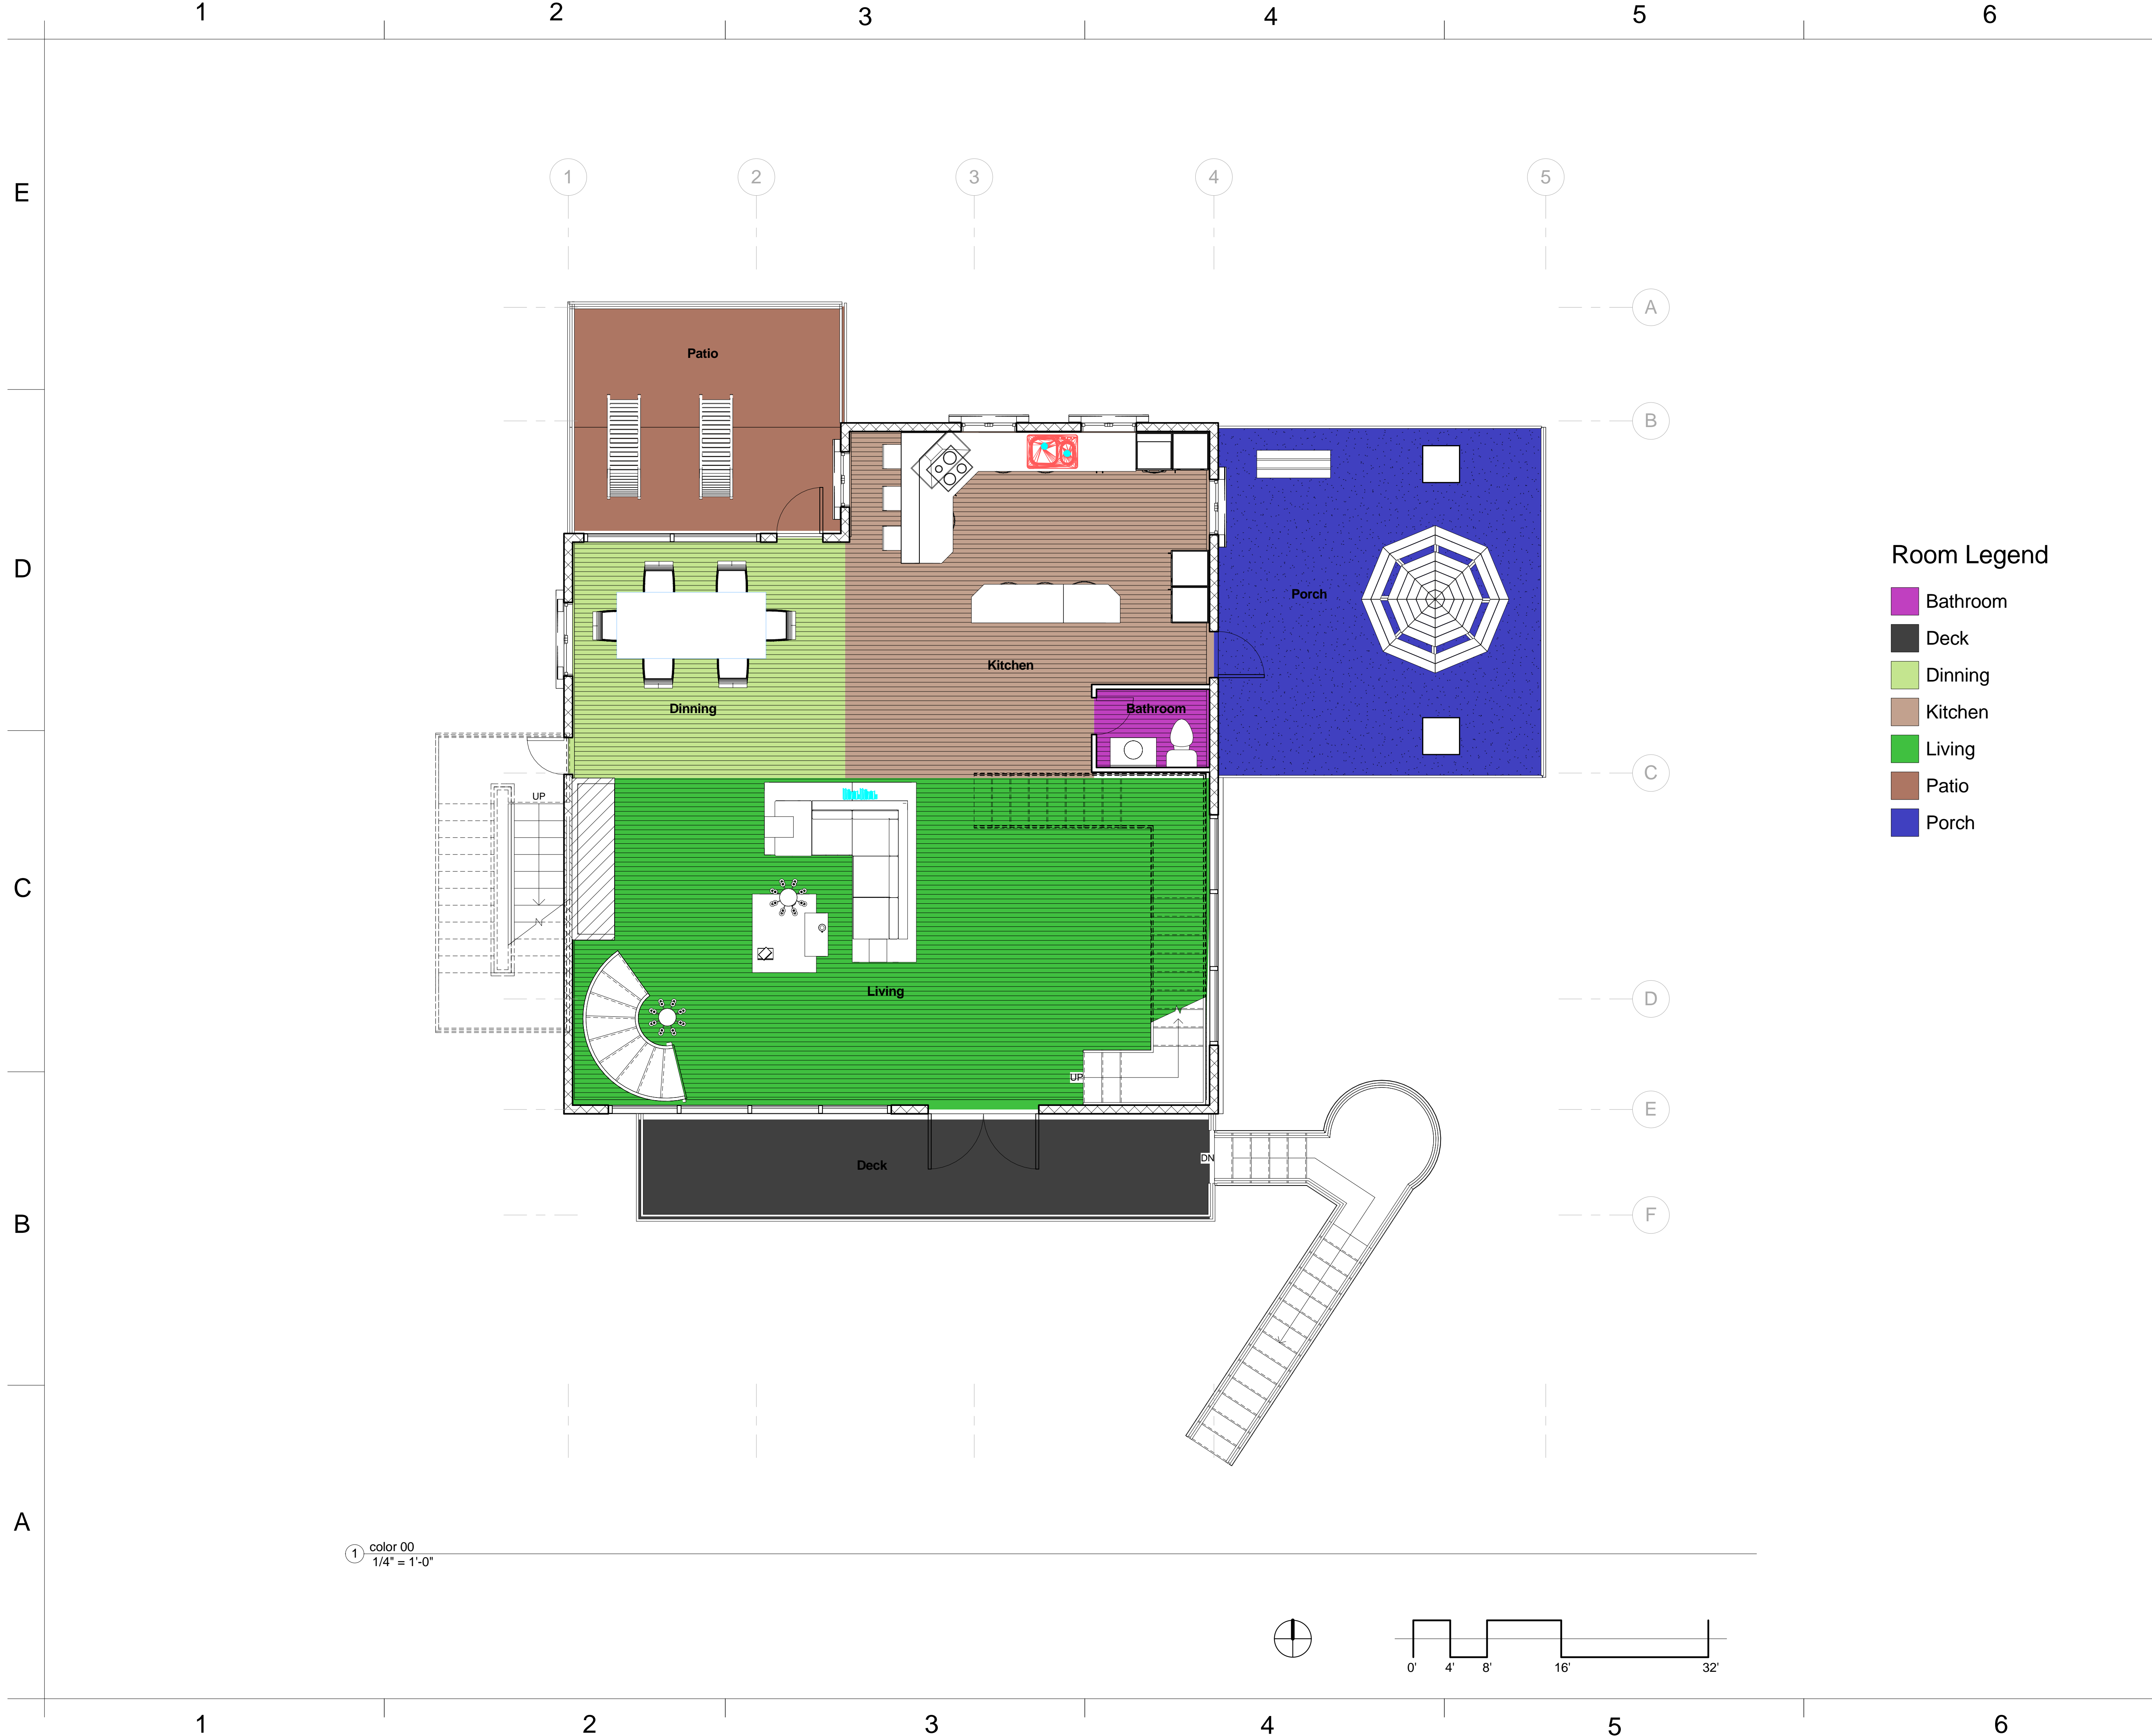

**YH DESIGN**

www.yhdesign.com

Consultant Prof. Christine Wacta  
Address Eichberg Hall  
Phone 912-228-2696

SCAD  
ELDS - 225-07  
FINAL

No.	Description	Date
HW 2B	house by the water	04/15/2013
HW 3	Pre-Final	04/24/2013
HW 4	Pre-Final	05/06/2013
HW 5	Pre-Final	05/13/2013

House by Water

COLORED  
GROUND

Project Number  
Date  
Drawn By  
Checked By

Project Number  
May 1st, 2013  
Yun Huang  
Prof. Wacta

A 112

Scale1/4" = 1'-0"





① color 01  
3/8" = 1'-0"

**YH DESIGN**  
[www.yhdesign.com](http://www.yhdesign.com)

Consultant Prof. Christine Wacta  
Address Eichberg Hall  
Phone 912-228-2696

SCAD  
ELDS - 225-07  
FINAL

No.	Description	Date
HW 2B	house by the water	04/15/2013
HW 3	Pre-Final	04/24/2013
HW 4	Pre-Final	05/06/2013
HW 5	Pre- Final	05/13/2013

House by Water

COLORED FIRST FLOOR


Project Number  
Date  
Drawn By  
Checked By

Project Number  
May 1st, 2013  
Yun Huang  
Prof. Wacta


A 113

Scale  
3/8" = 1'-0"



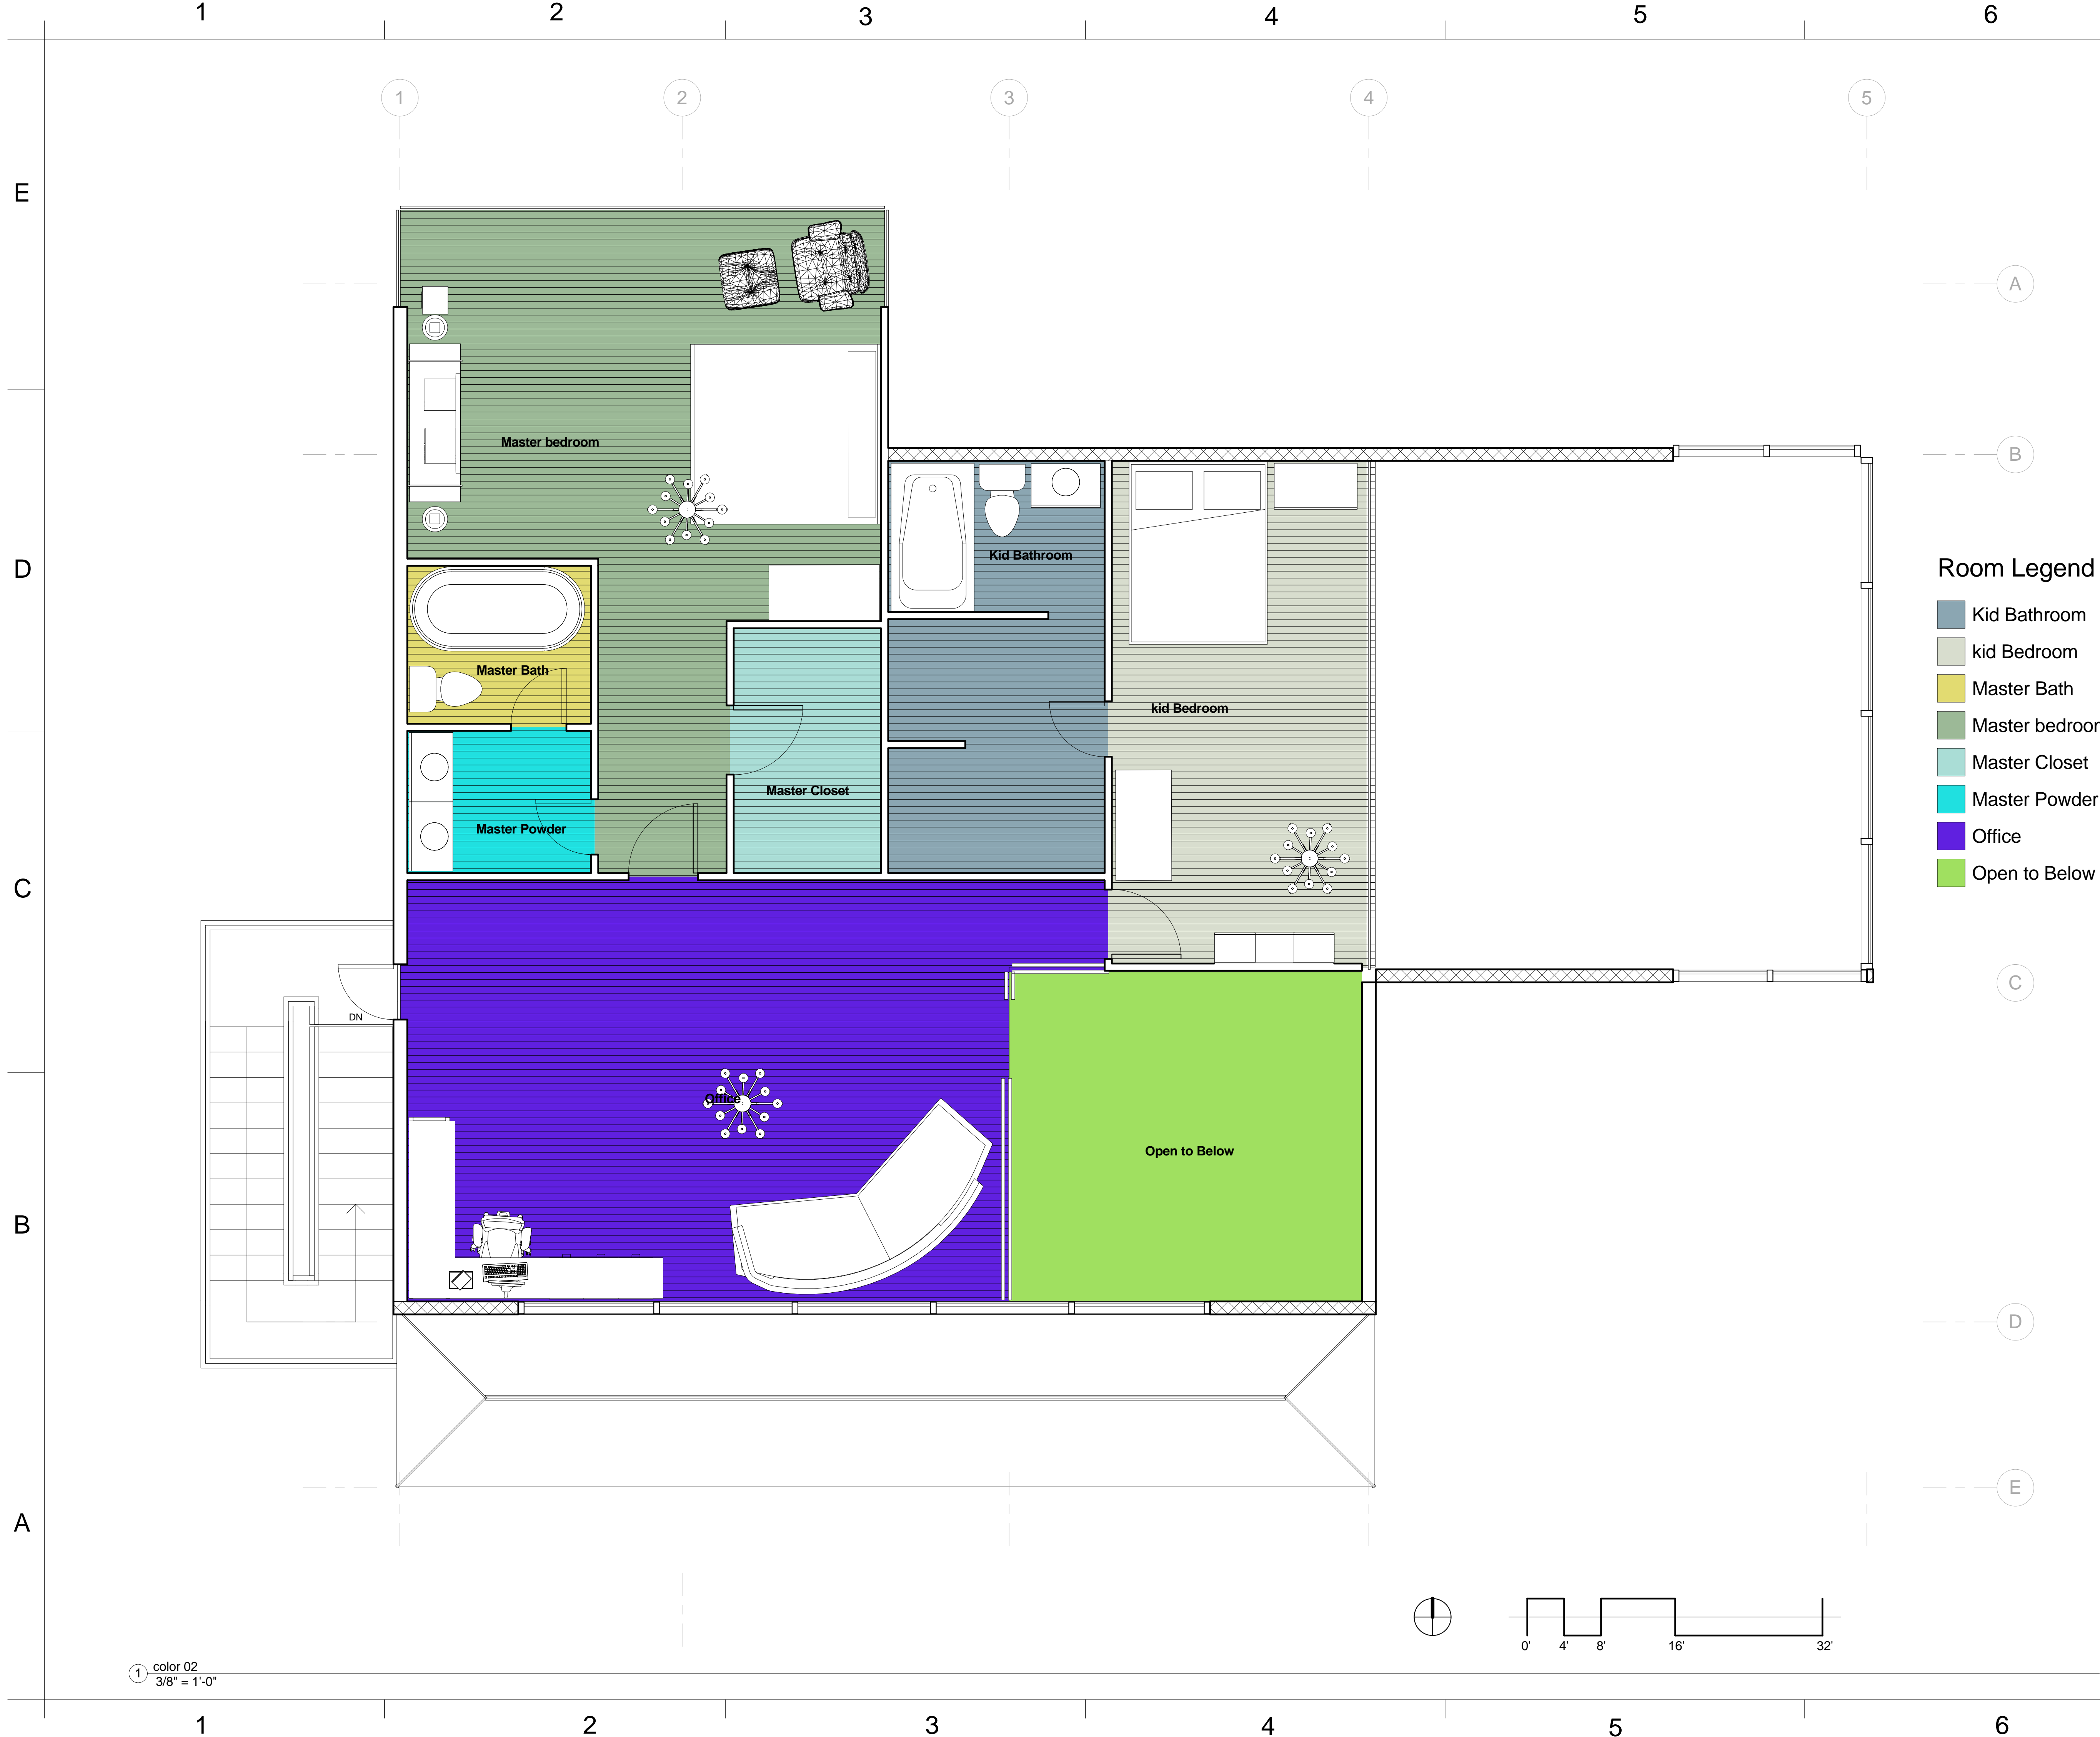

① color 02  
3/8" = 1'-0"

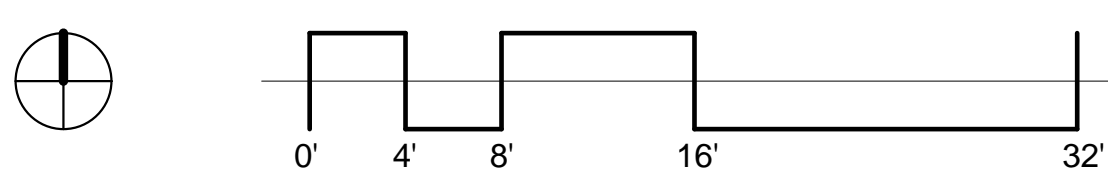

**YH DESIGN**

www.yhdesign.com

Consultant Prof. Christine Wacta  
Address Eichberg Hall  
Phone 912-228-2696

SCAD  
ELDS - 225-07  
FINAL

No.	Description	Date
HW 2B	house by the water	04/15/2013
HW 3	Pre-Final	04/24/2013
HW 4	Pre-Final	05/06/2013
HW 5	Pre-Final	05/13/2013

House by Water


COLORED  
SECOND FLOOR

Project Number	Project Number
Date	May 1st, 2013
Drawn By	Yun Huang
Checked By	Prof. Wacta

A 114

Scale 3/8" = 1'-0"



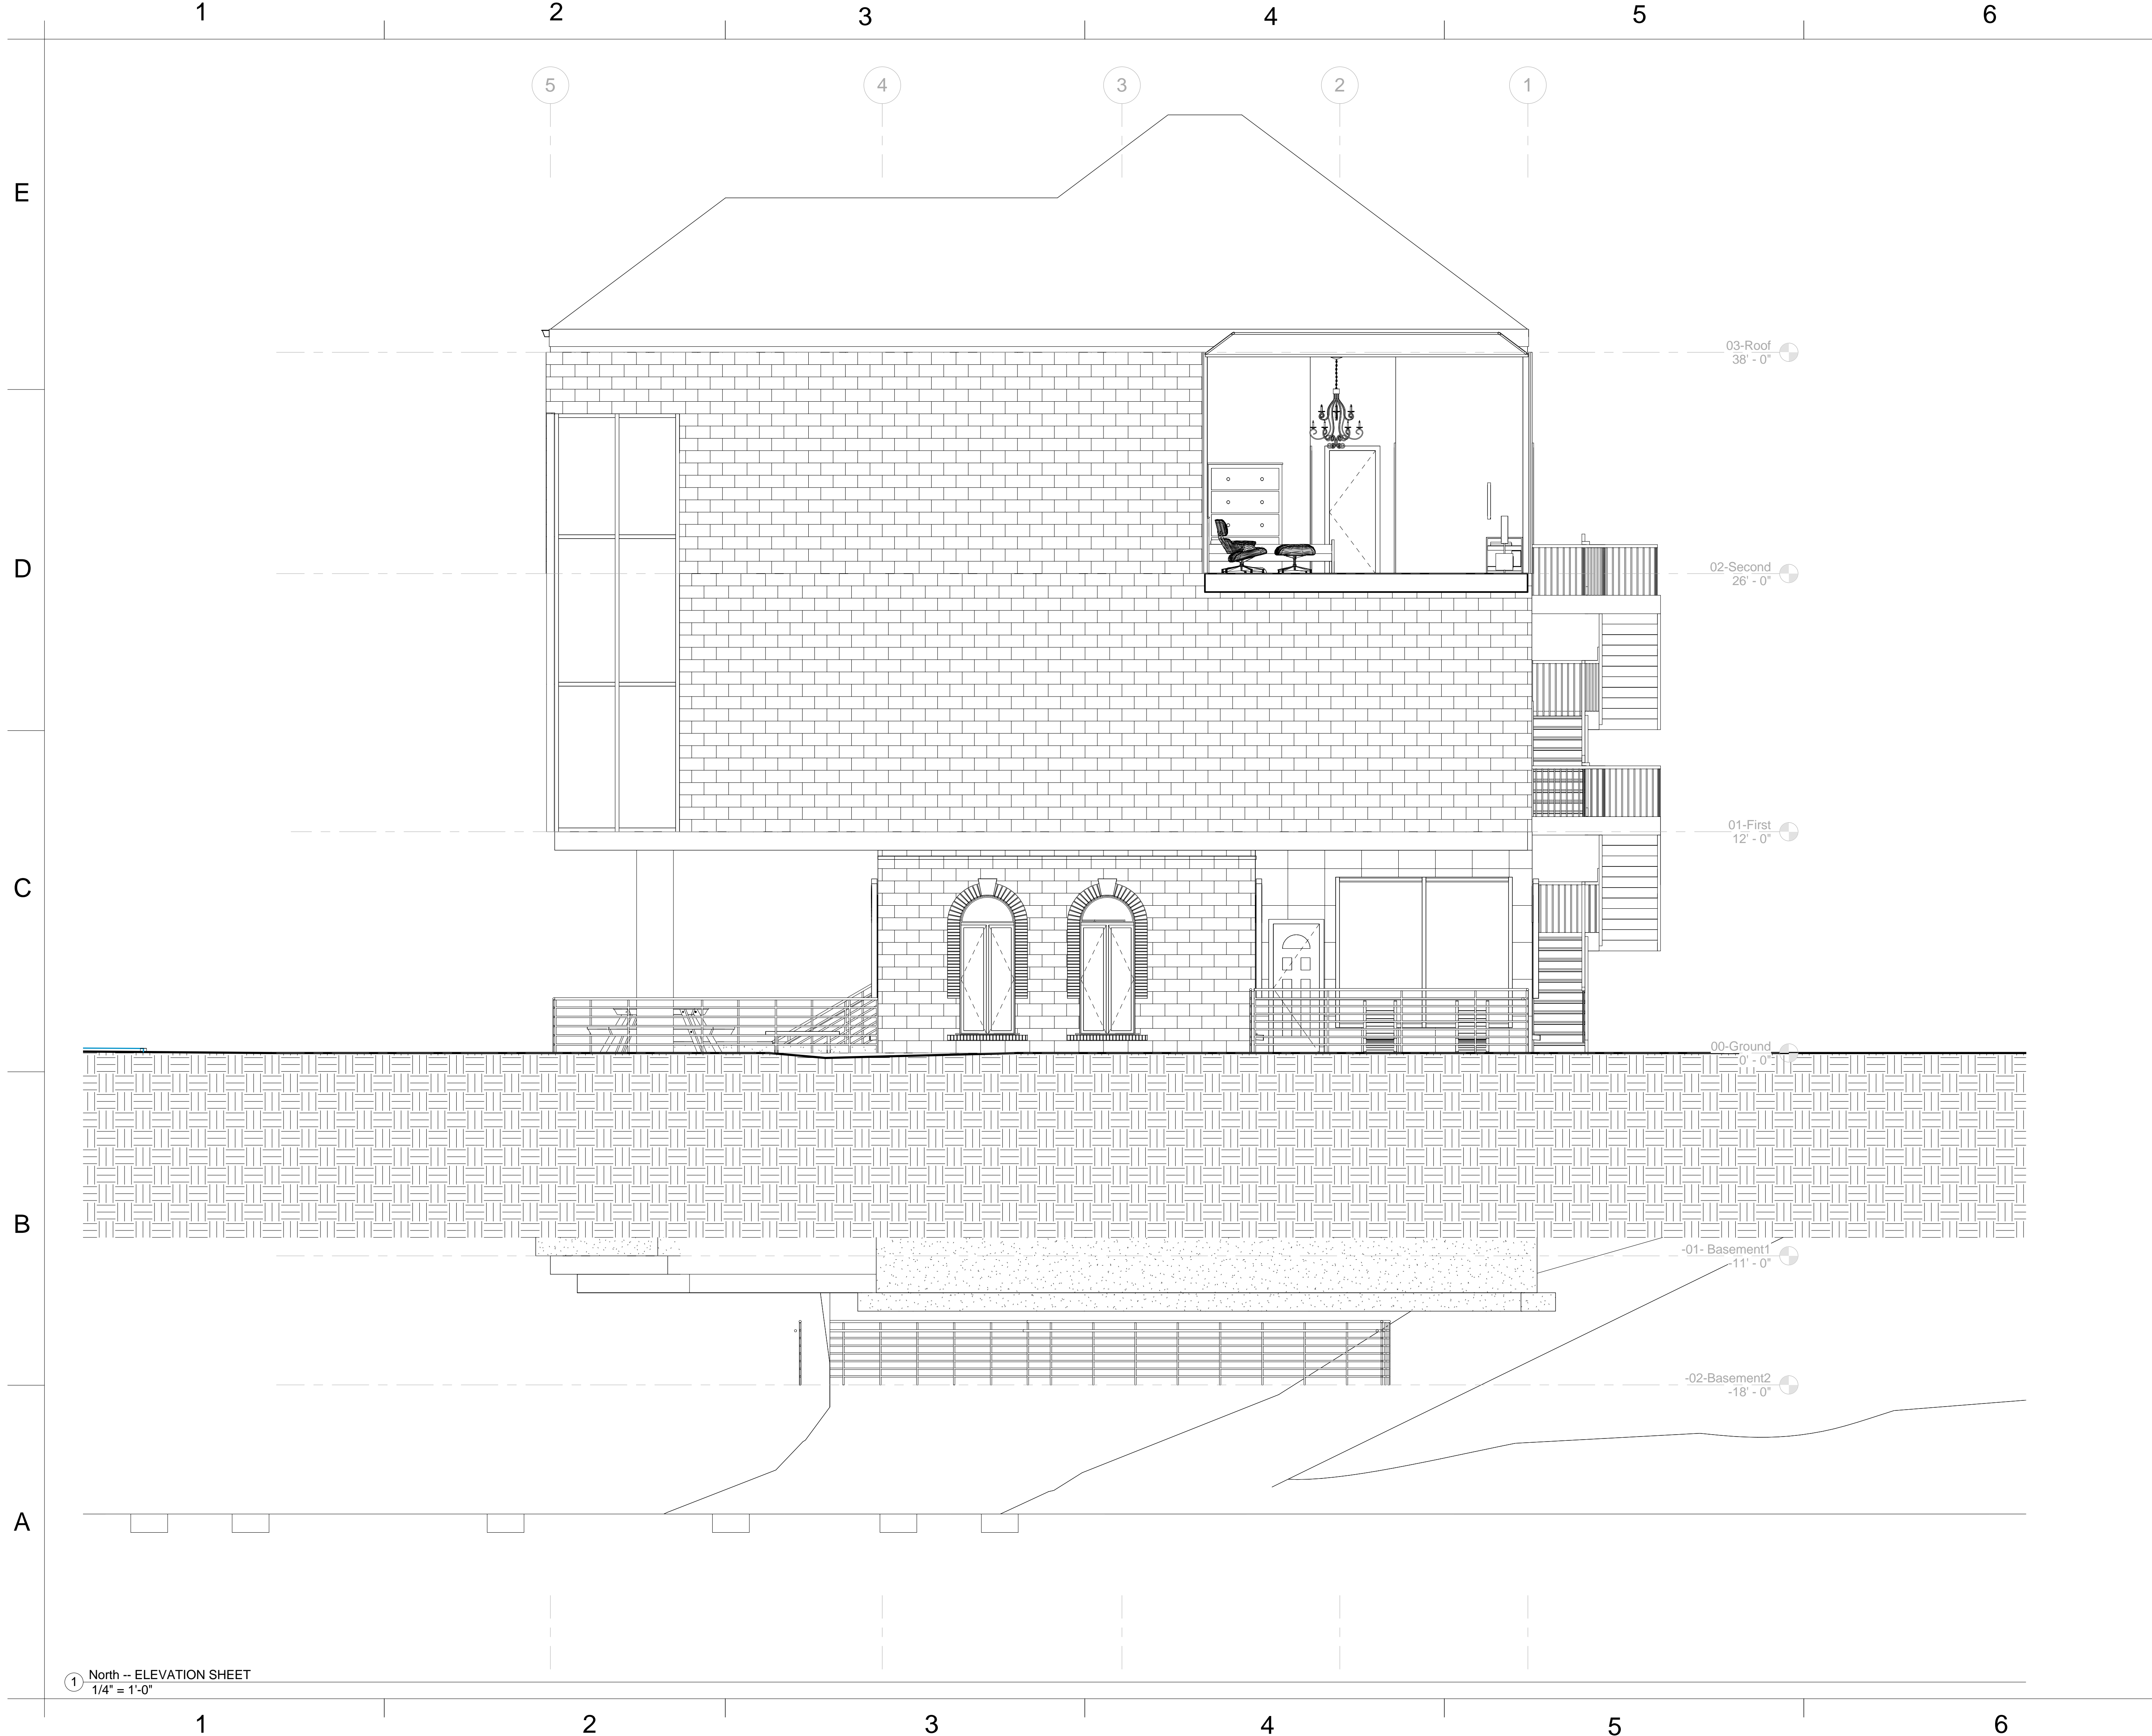

**YH DESIGN**

www.yhdesign.com

Consultant Prof. Christine Wacta  
Address Eichberg Hall  
Phone 912-228-2696

SCAD  
ELDS - 225-07  
FINAL

No.	Description	Date
HW 2B	house by the water	04/15/2013
HW 3	Pre-Final	04/24/2013
HW 4	Pre-Final	05/06/2013
HW 5	Pre-Final	05/13/2013

House by Water

EXTERIOR  
ELEVATIONS --  
NORTH

Project Number  
Date  
Drawn By  
Checked By


Project Number  
May 1st, 2013  
Yun Huang  
Prof. Wacta

A 201

Scale1/4" = 1'-0"

1 North -- ELEVATION SHEET  
1/4" = 1'-0"




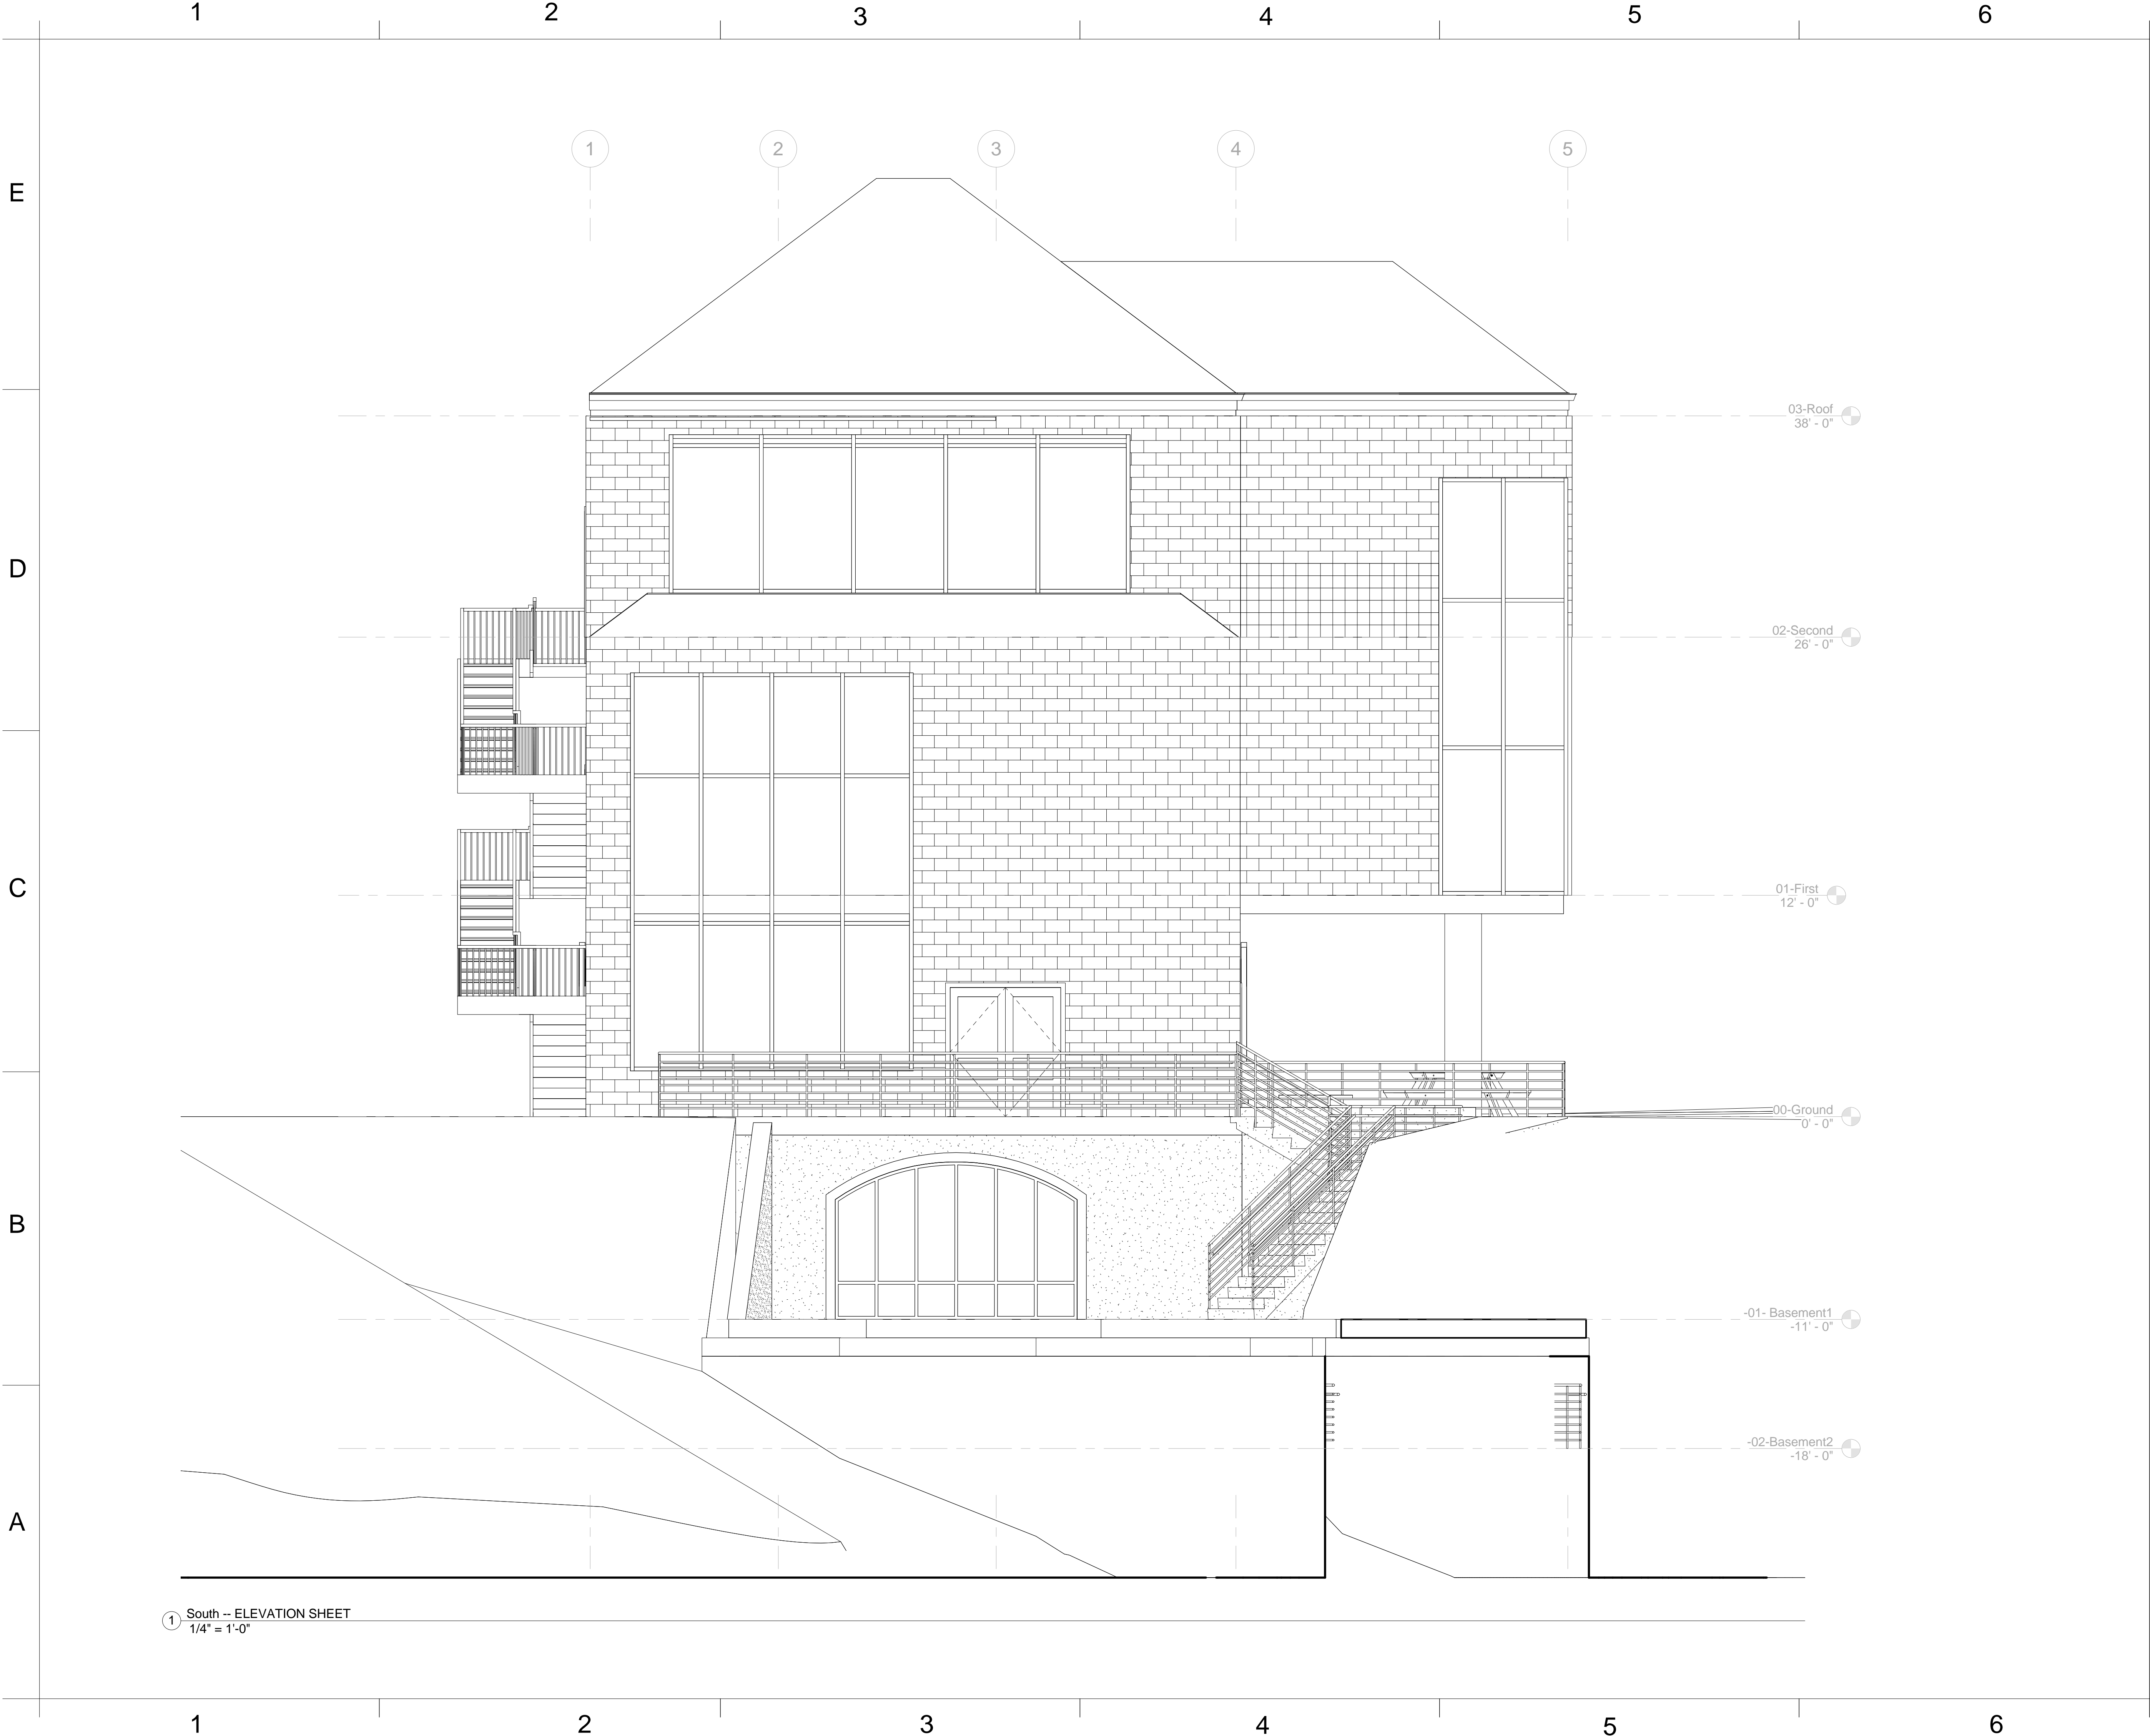

**YH DESIGN**

www.yhdesign.com

Consultant Prof. Christine Wacta  
Address Eichberg Hall  
Phone 912-228-2696

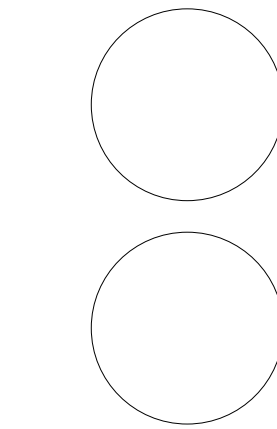

**SCAD  
ELDS - 225-07  
FINAL**

No.	Description	Date
HW 2B	house by the water	04/15/2013
HW 3	Pre-Final	04/24/2013
HW 4	Pre-Final	05/06/2013
HW 5	Pre- Final	05/13/2013

House by Water


**EXTERIOR  
ELEVATION --  
SOUTH**

Project Number	Project Number
Date	May 1st, 2013
Drawn By	Yun Huang
Checked By	Prof. Wacta

**A 202**

Scale	1/4" = 1'-0"
-------	--------------


① South -- ELEVATION SHEET  
1/4" = 1'-0"

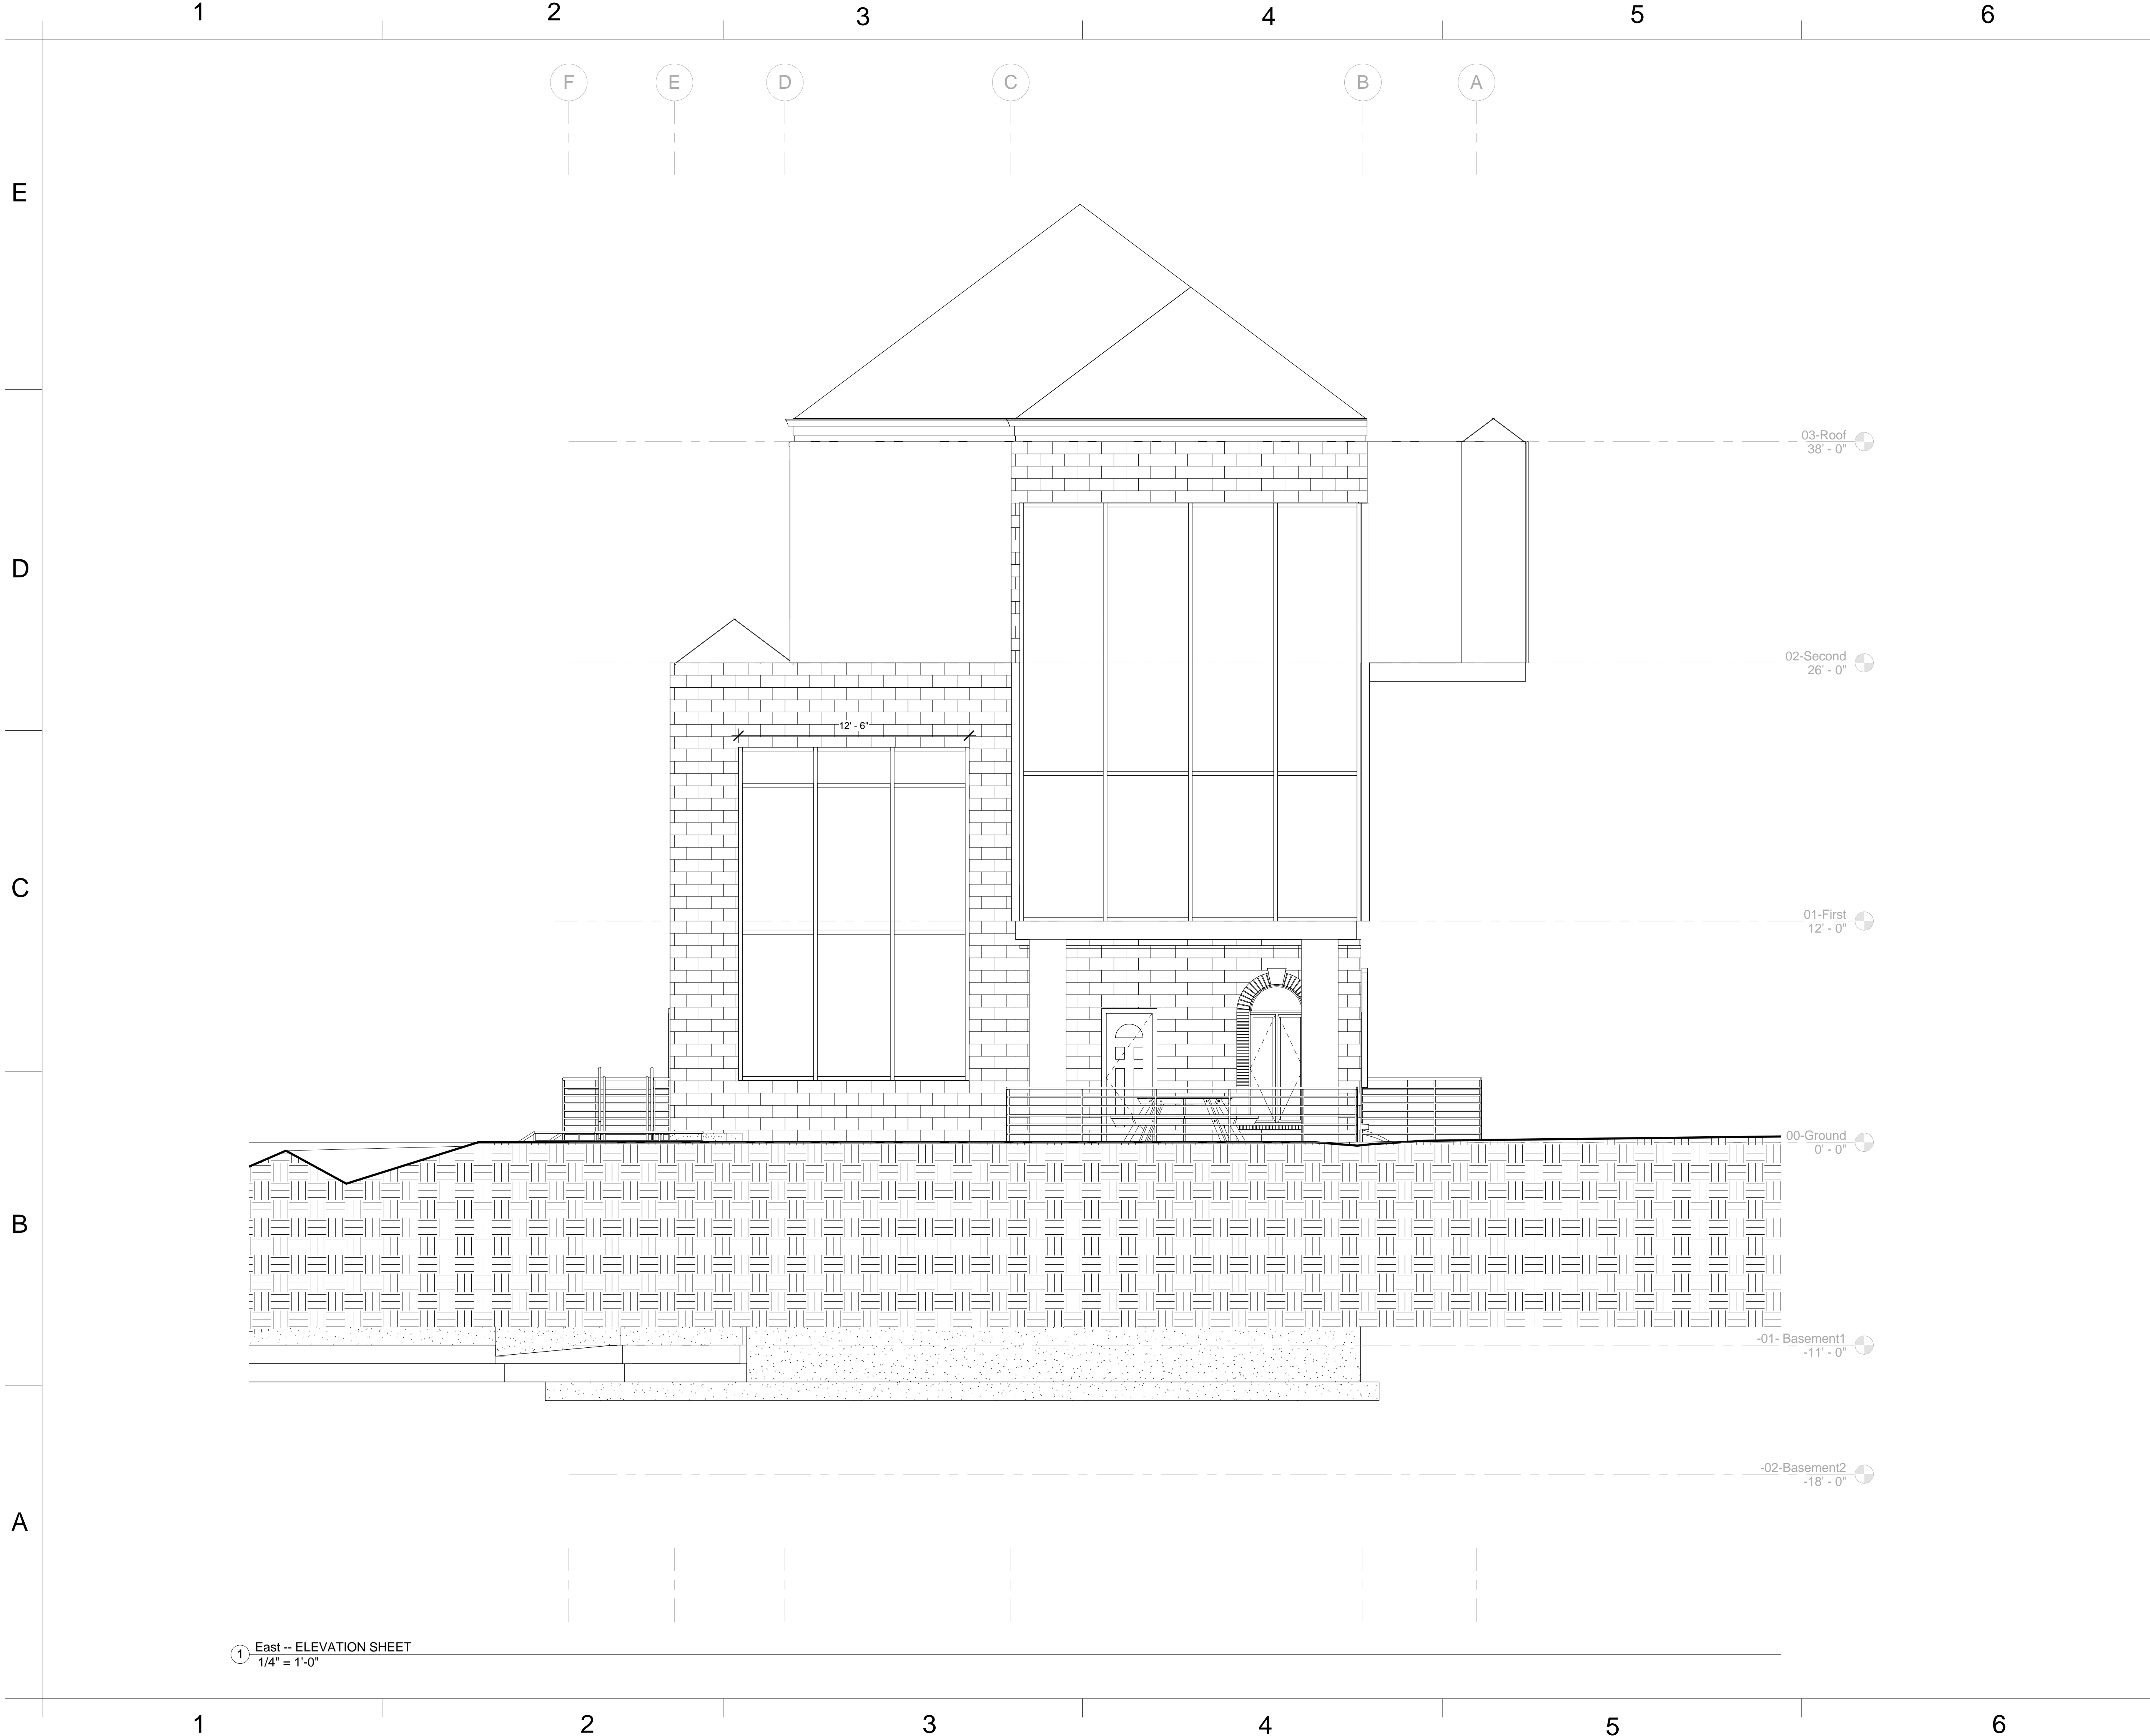

**YH DESIGN**

www.yhdesign.com

Consultant Prof. Christine Wacta  
Address Eichberg Hall  
Phone 912-228-2696

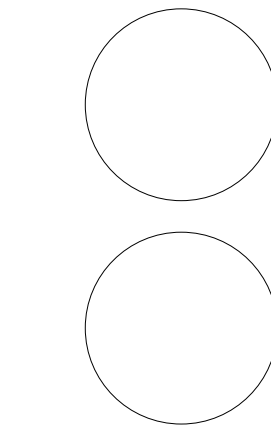

**SCAD  
ELDS - 225-07  
FINAL**

No.	Description	Date
HW 2B	house by the water	04/15/2013
HW 3	Pre-Final	04/24/2013
HW 4	Pre-Final	05/06/2013
HW 5	Pre- Final	05/13/2013

House by Water

**EXTERIOR  
ELEVATION --  
EAST**


Project Number	Project Number
Date	May 1st, 2013
Drawn By	Yun Huang
Checked By	Prof. Wacta

**A 203**

Scale	1/4" = 1'-0"
-------	--------------

① East -- ELEVATION SHEET  
1/4" = 1'-0"




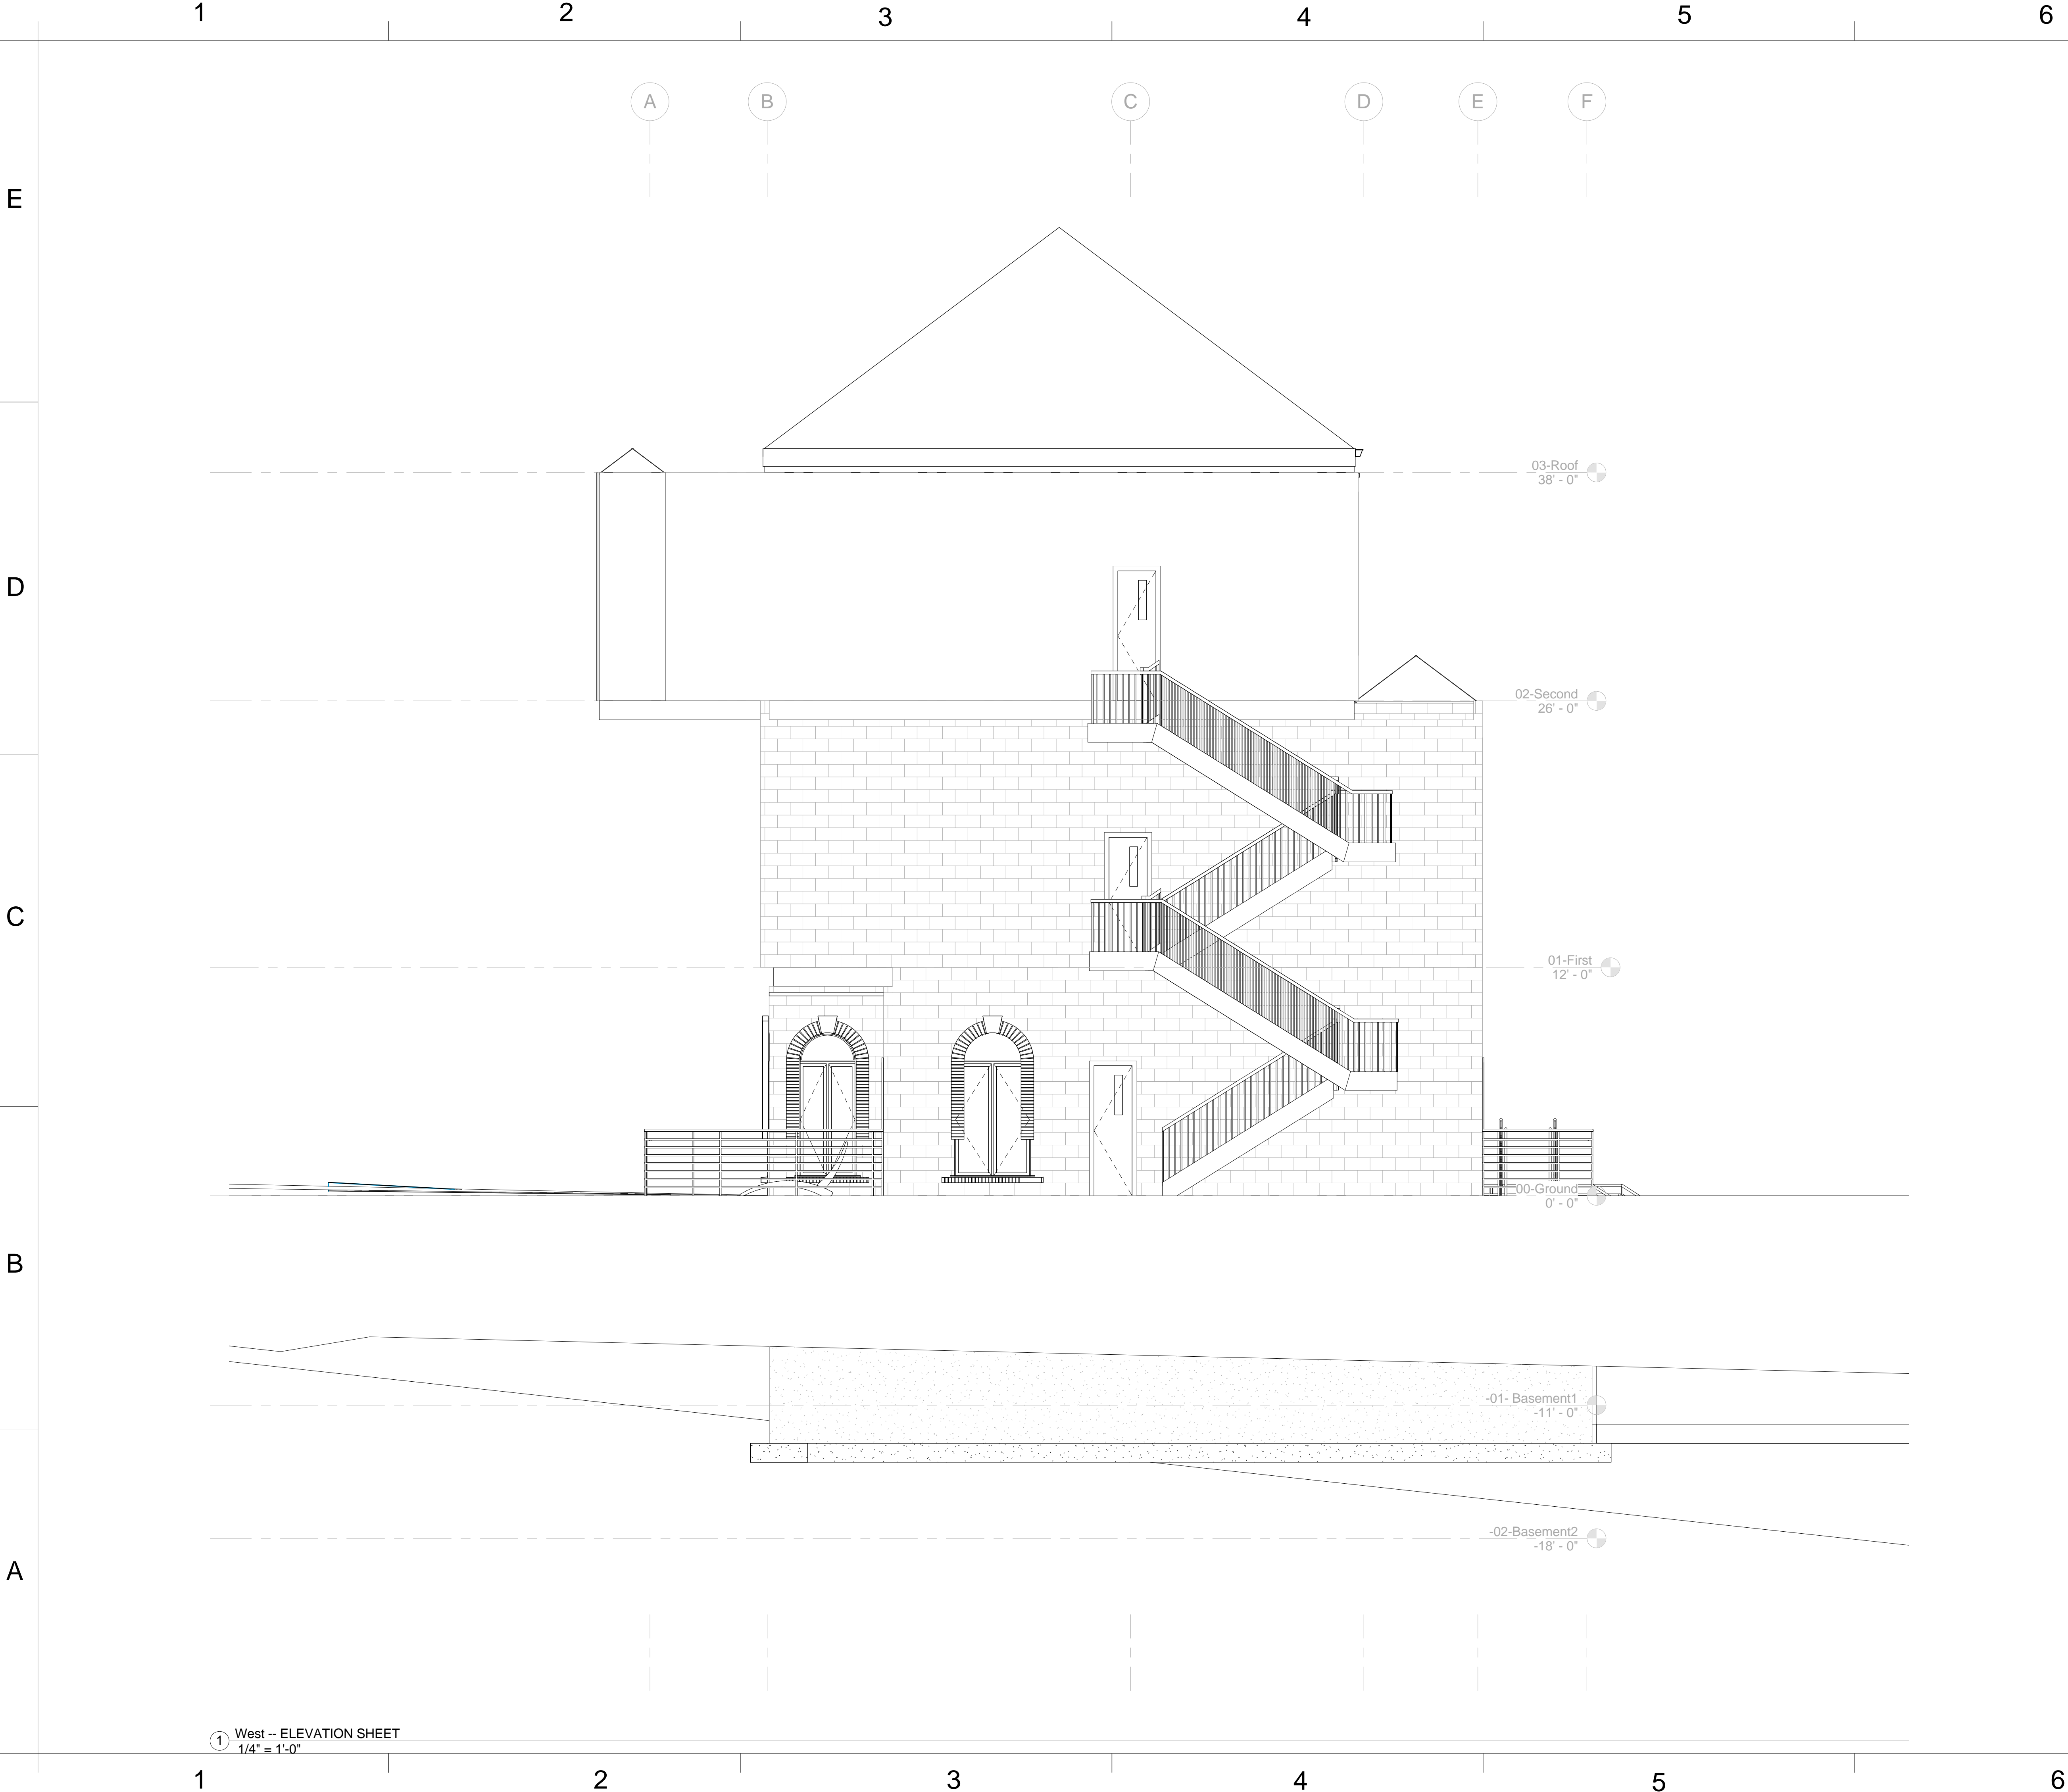

**YH DESIGN**

www.yhdesign.com

Consultant Prof. Christine Wacta  
Address Eichberg Hall  
Phone 912-228-2696

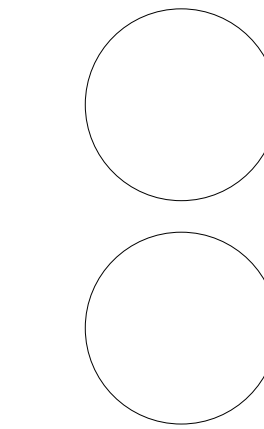

**SCAD  
ELDS - 225-07  
FINAL**

No.	Description	Date
HW 2B	house by the water	04/15/2013
HW 3	Pre-Final	04/24/2013
HW 4	Pre-Final	05/06/2013
HW 5	Pre-Final	05/13/2013


House by Water

**EXTERIOR  
ELEVATION --  
WEST**

Project Number	Project Number
Date	May 1st, 2013
Drawn By	Yun Huang
Checked By	Prof. Wacta

**A 204**


Scale	1/4" = 1'-0"
-------	--------------

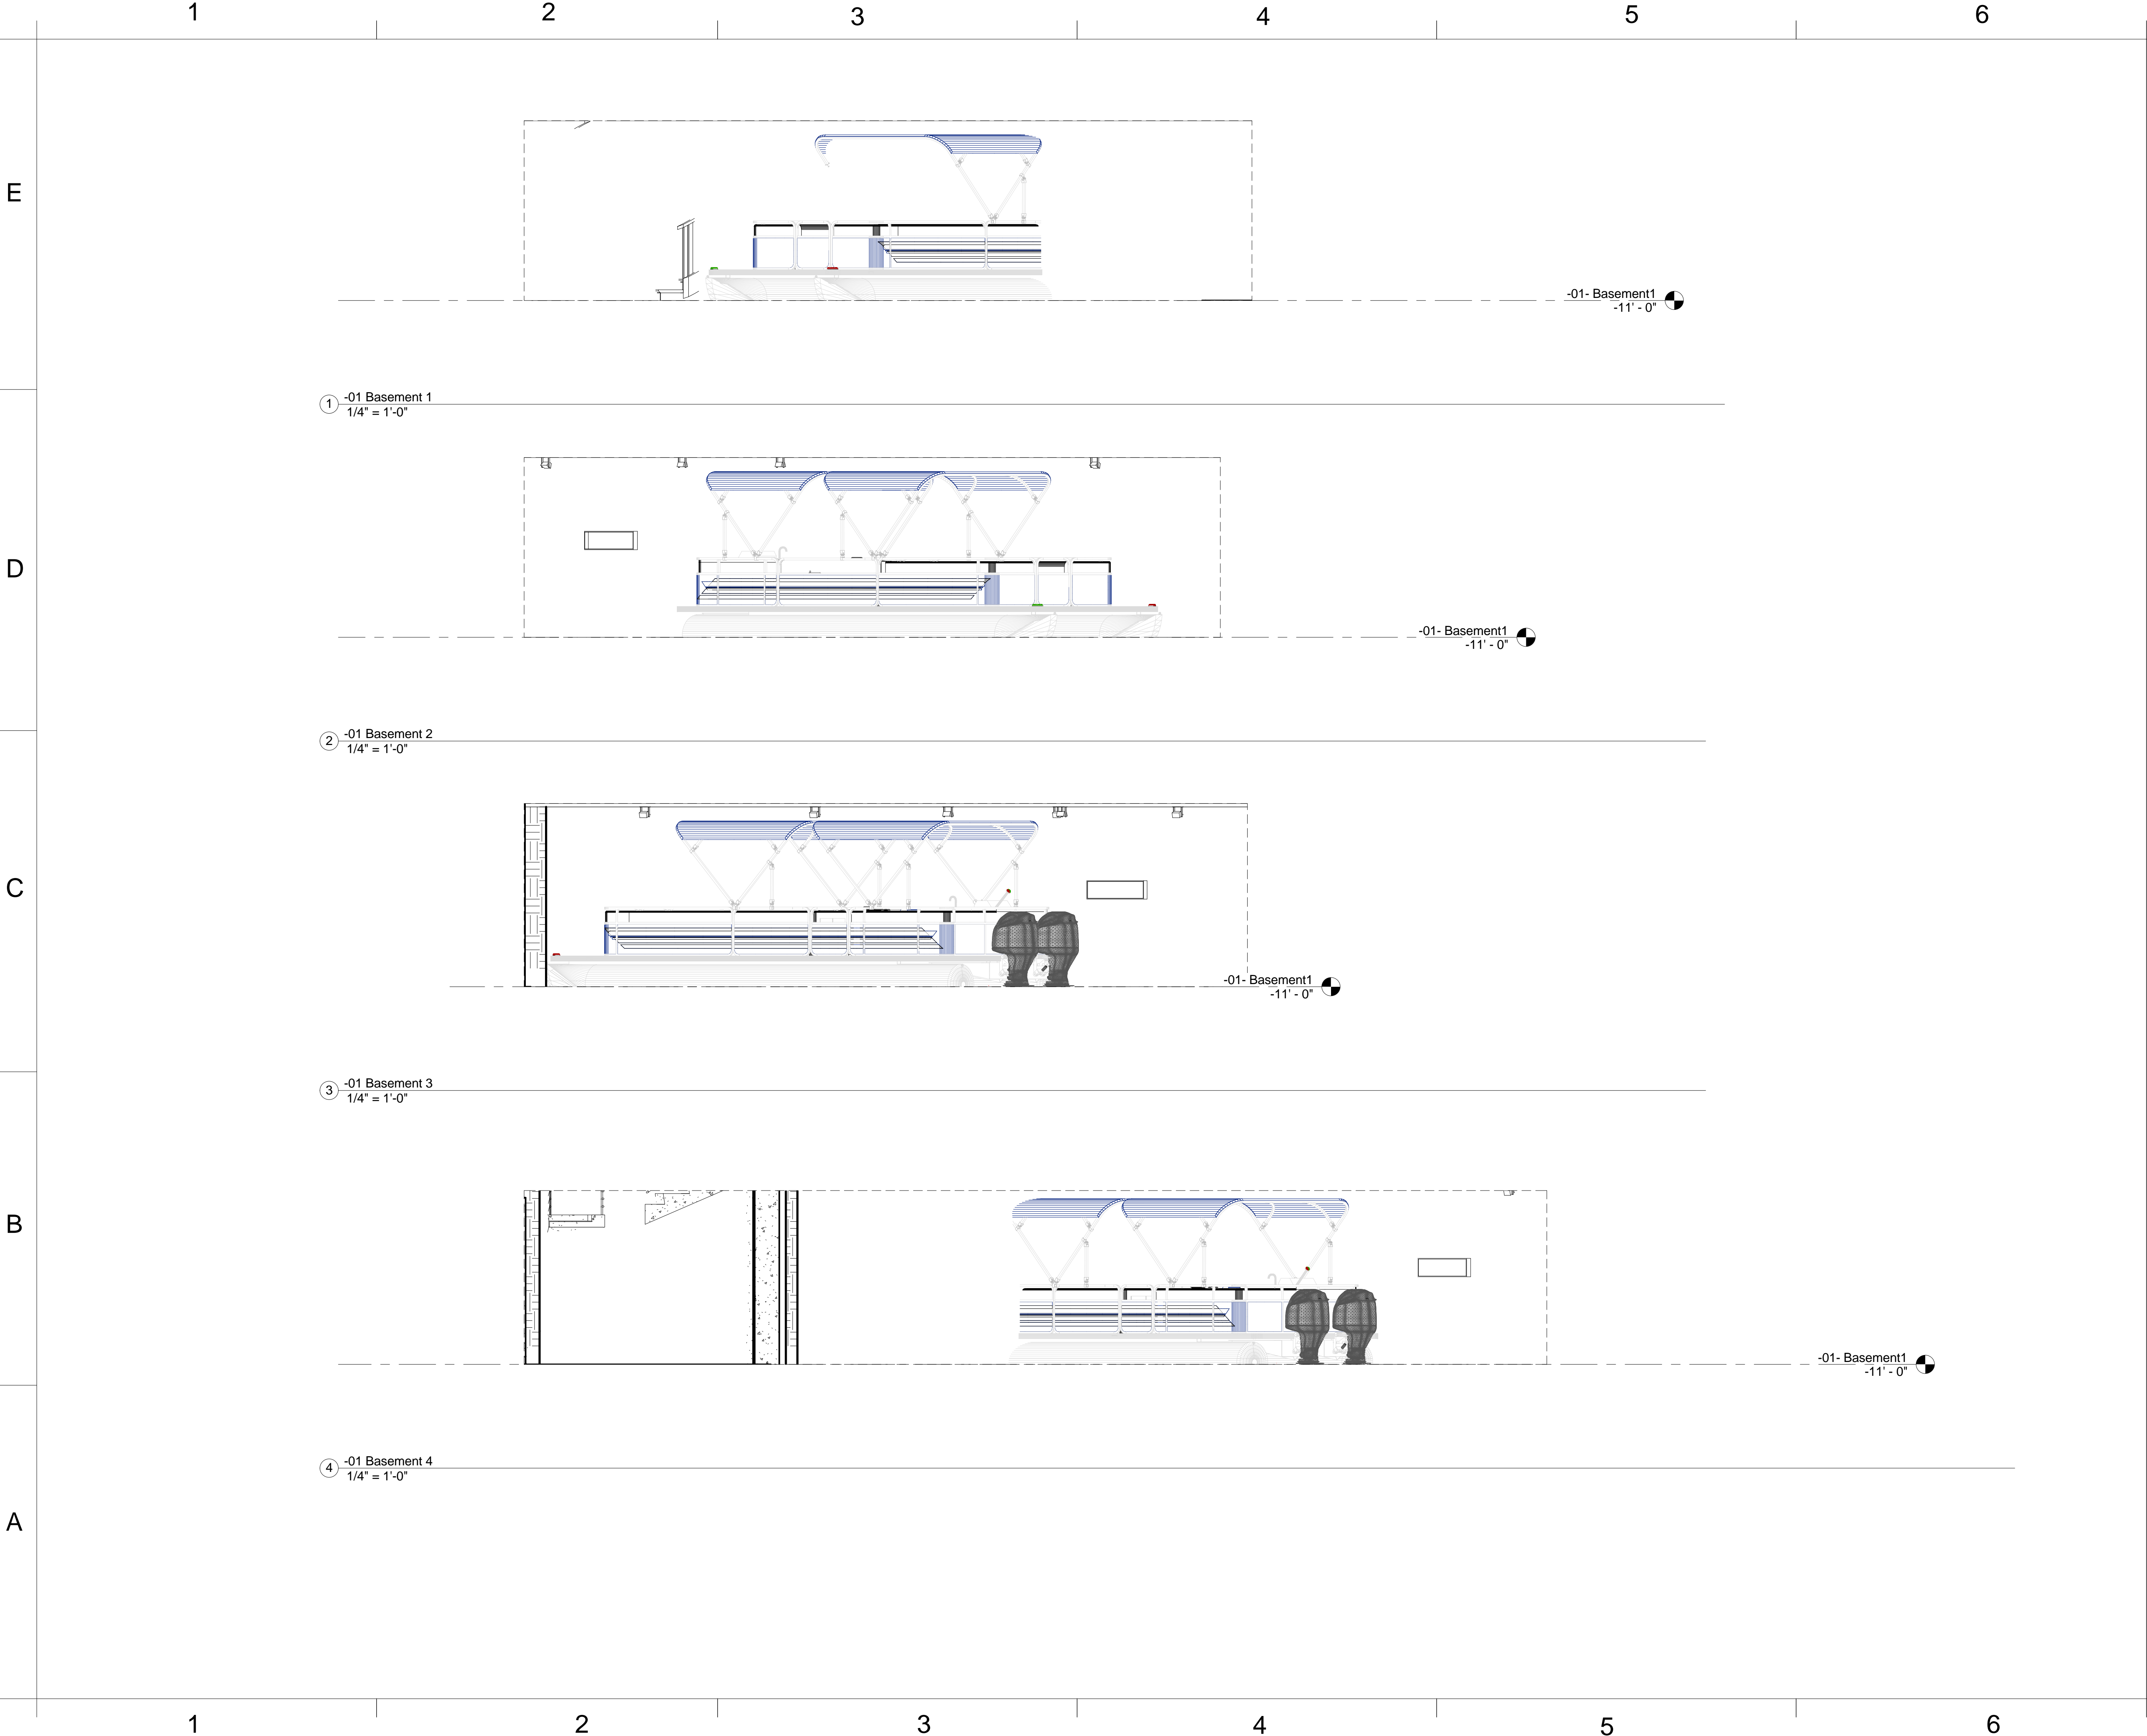

**YH DESIGN**

www.yhdesign.com

Consultant Prof. Christine Wacta  
Address Eichberg Hall  
Phone 912-228-2696

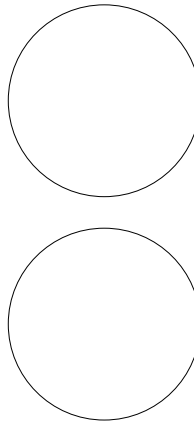

**SCAD  
ELDS - 225-07  
FINAL**

No.	Description	Date
HW 2B	house by the water	04/15/2013
HW 3	Pre-Final	04/24/2013
HW 4	Pre-Final	05/06/2013
HW 5	Pre-Final	05/13/2013

House by Water


**INTERIOR  
ELEVATION --  
BASEMENT**

Project Number	Project Number
Date	May 1st, 2013
Drawn By	Yun Huang
Checked By	Prof. Wacta

**A 205**

Scale	1/4" = 1'-0"
-------	--------------




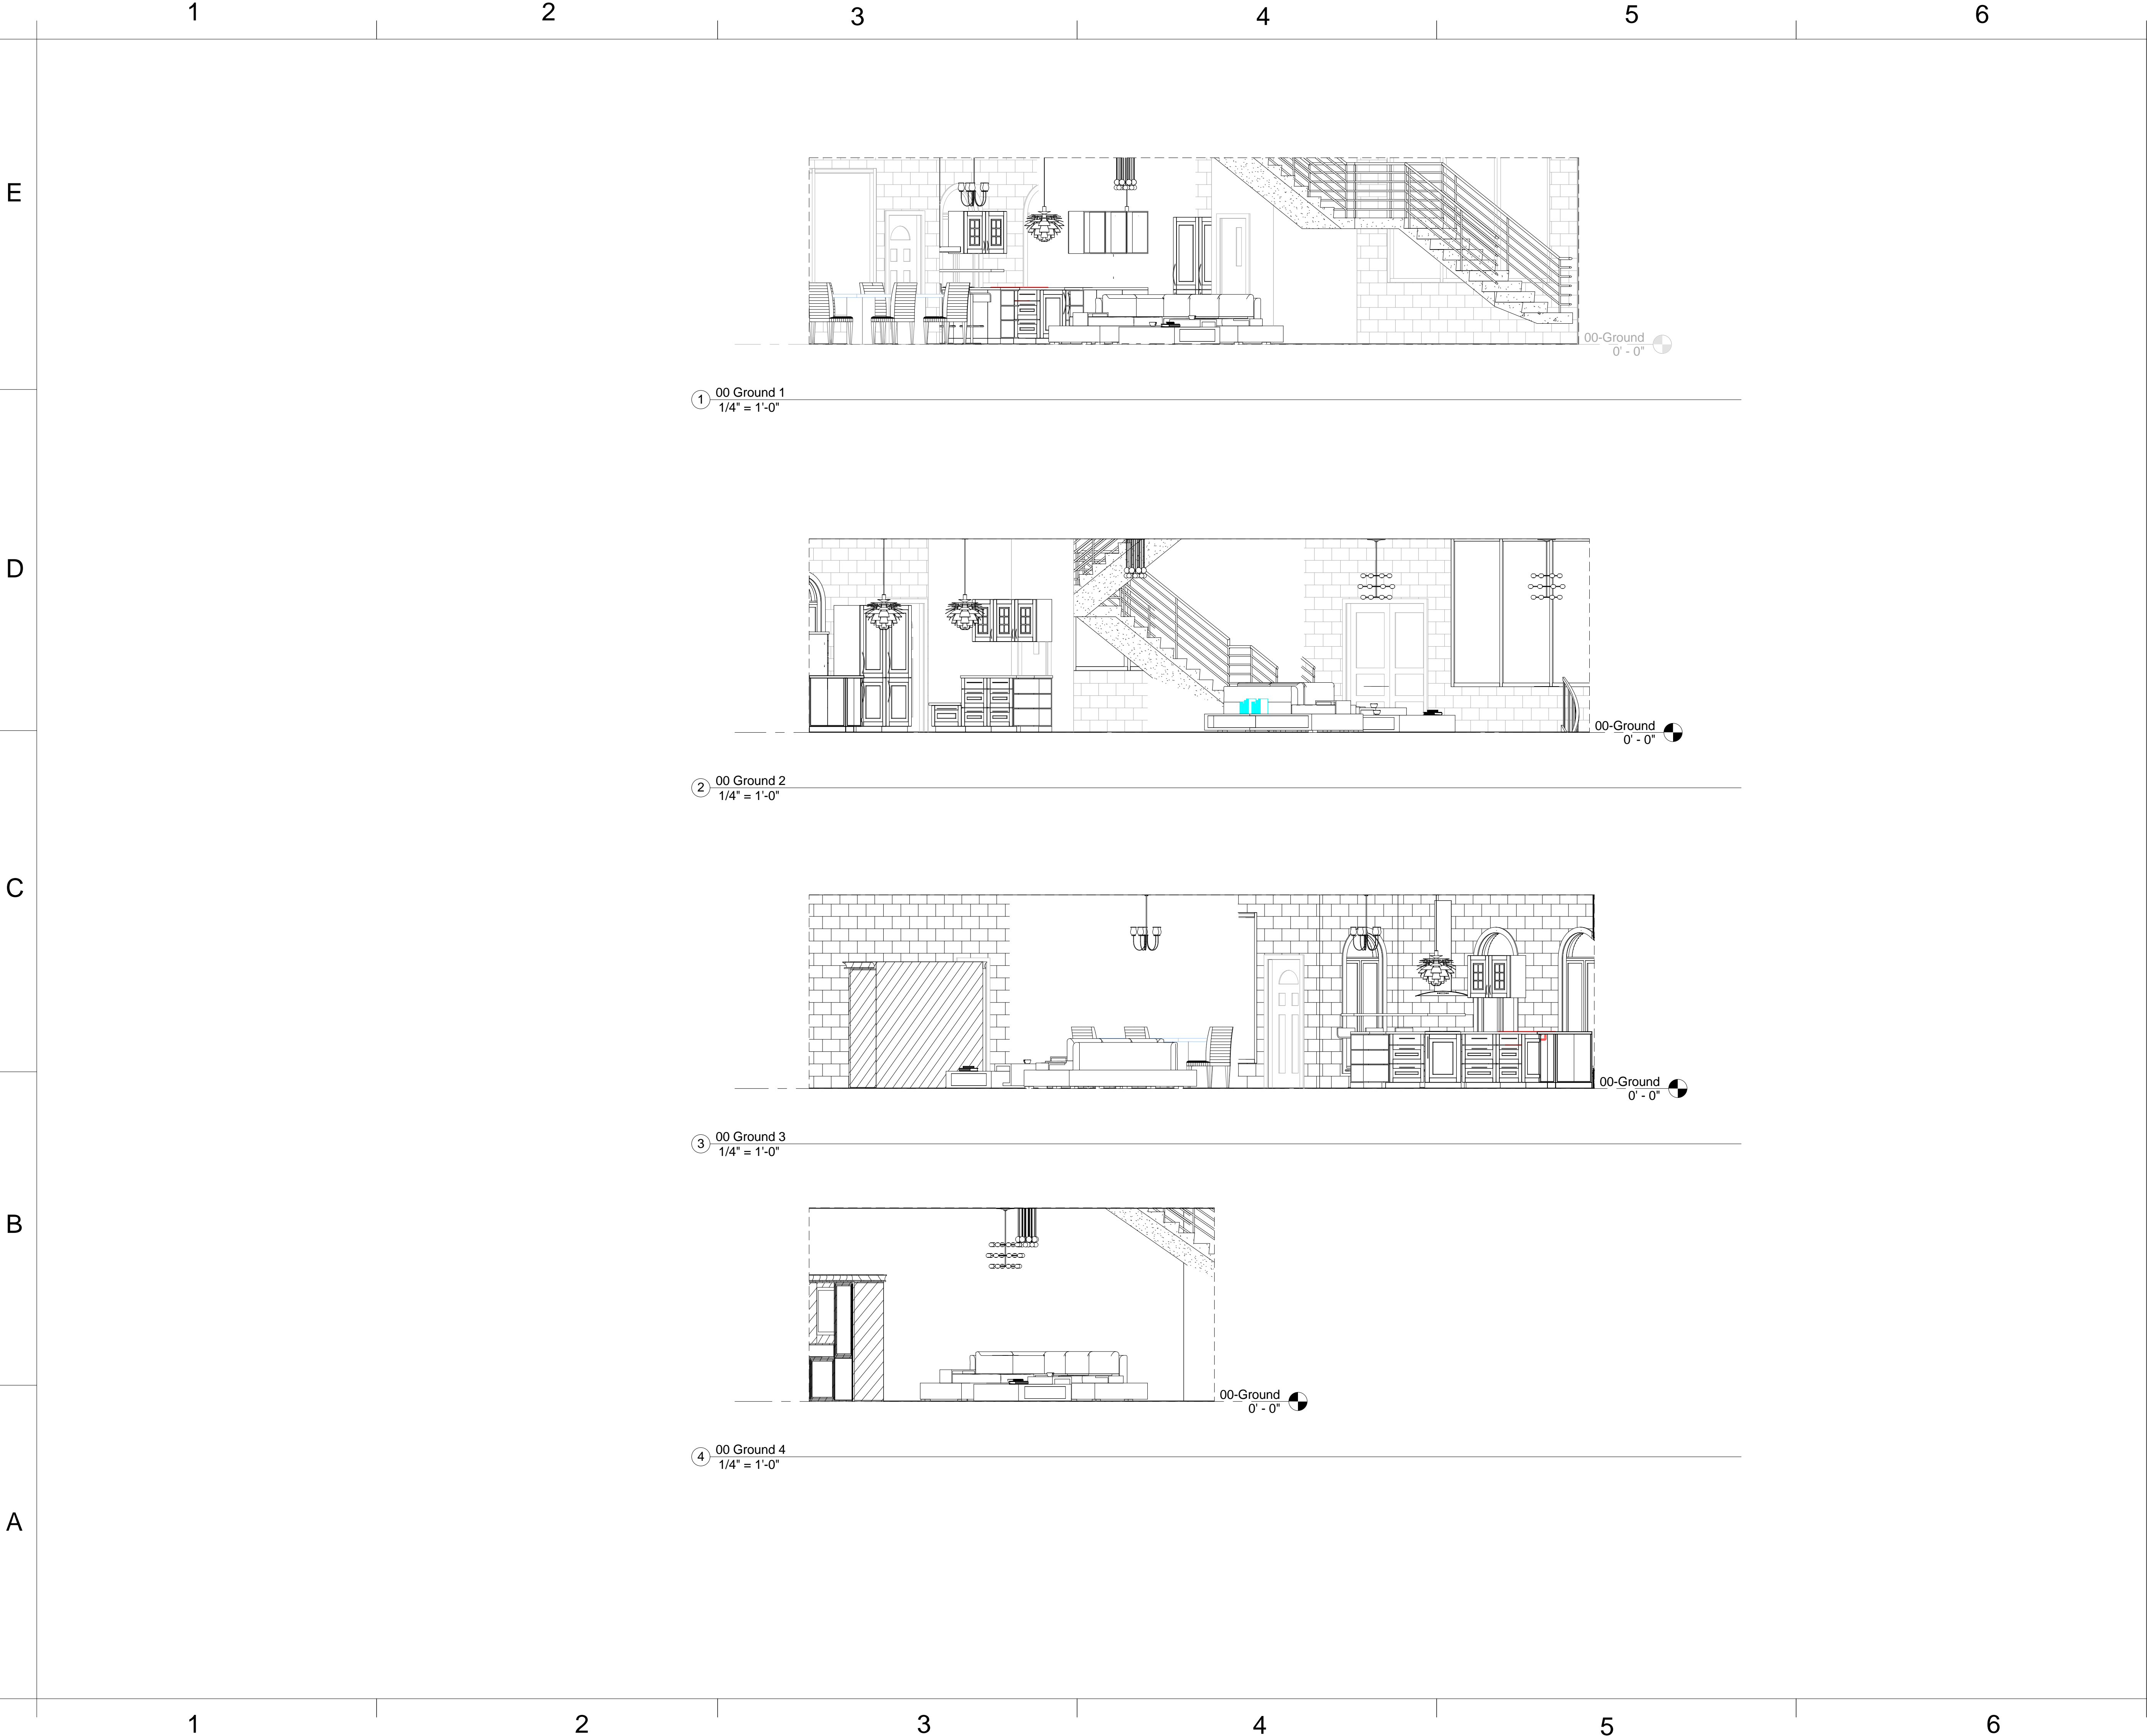

**YH DESIGN**

www.yhdesign.com

Consultant Prof. Christine Wacta  
Address Eichberg Hall  
Phone 912-228-2696

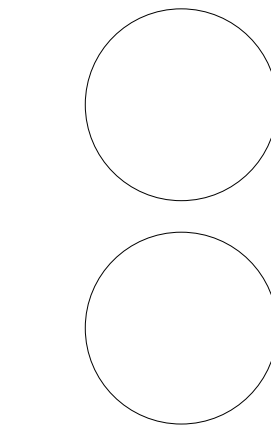

**SCAD  
ELDS - 225-07  
FINAL**

No.	Description	Date
HW 2B	house by the water	04/15/2013
HW 3	Pre-Final	04/24/2013
HW 4	Pre-Final	05/06/2013
HW 5	Pre- Final	05/13/2013


House by Water

**INTERIOR  
ELEVATION --  
GROUND FLOOR**

Project Number	Project Number
Date	May 1st, 2013
Drawn By	Yun Huang
Checked By	Prof. Wacta

**A 206**


Scale	1/4" = 1'-0"
-------	--------------

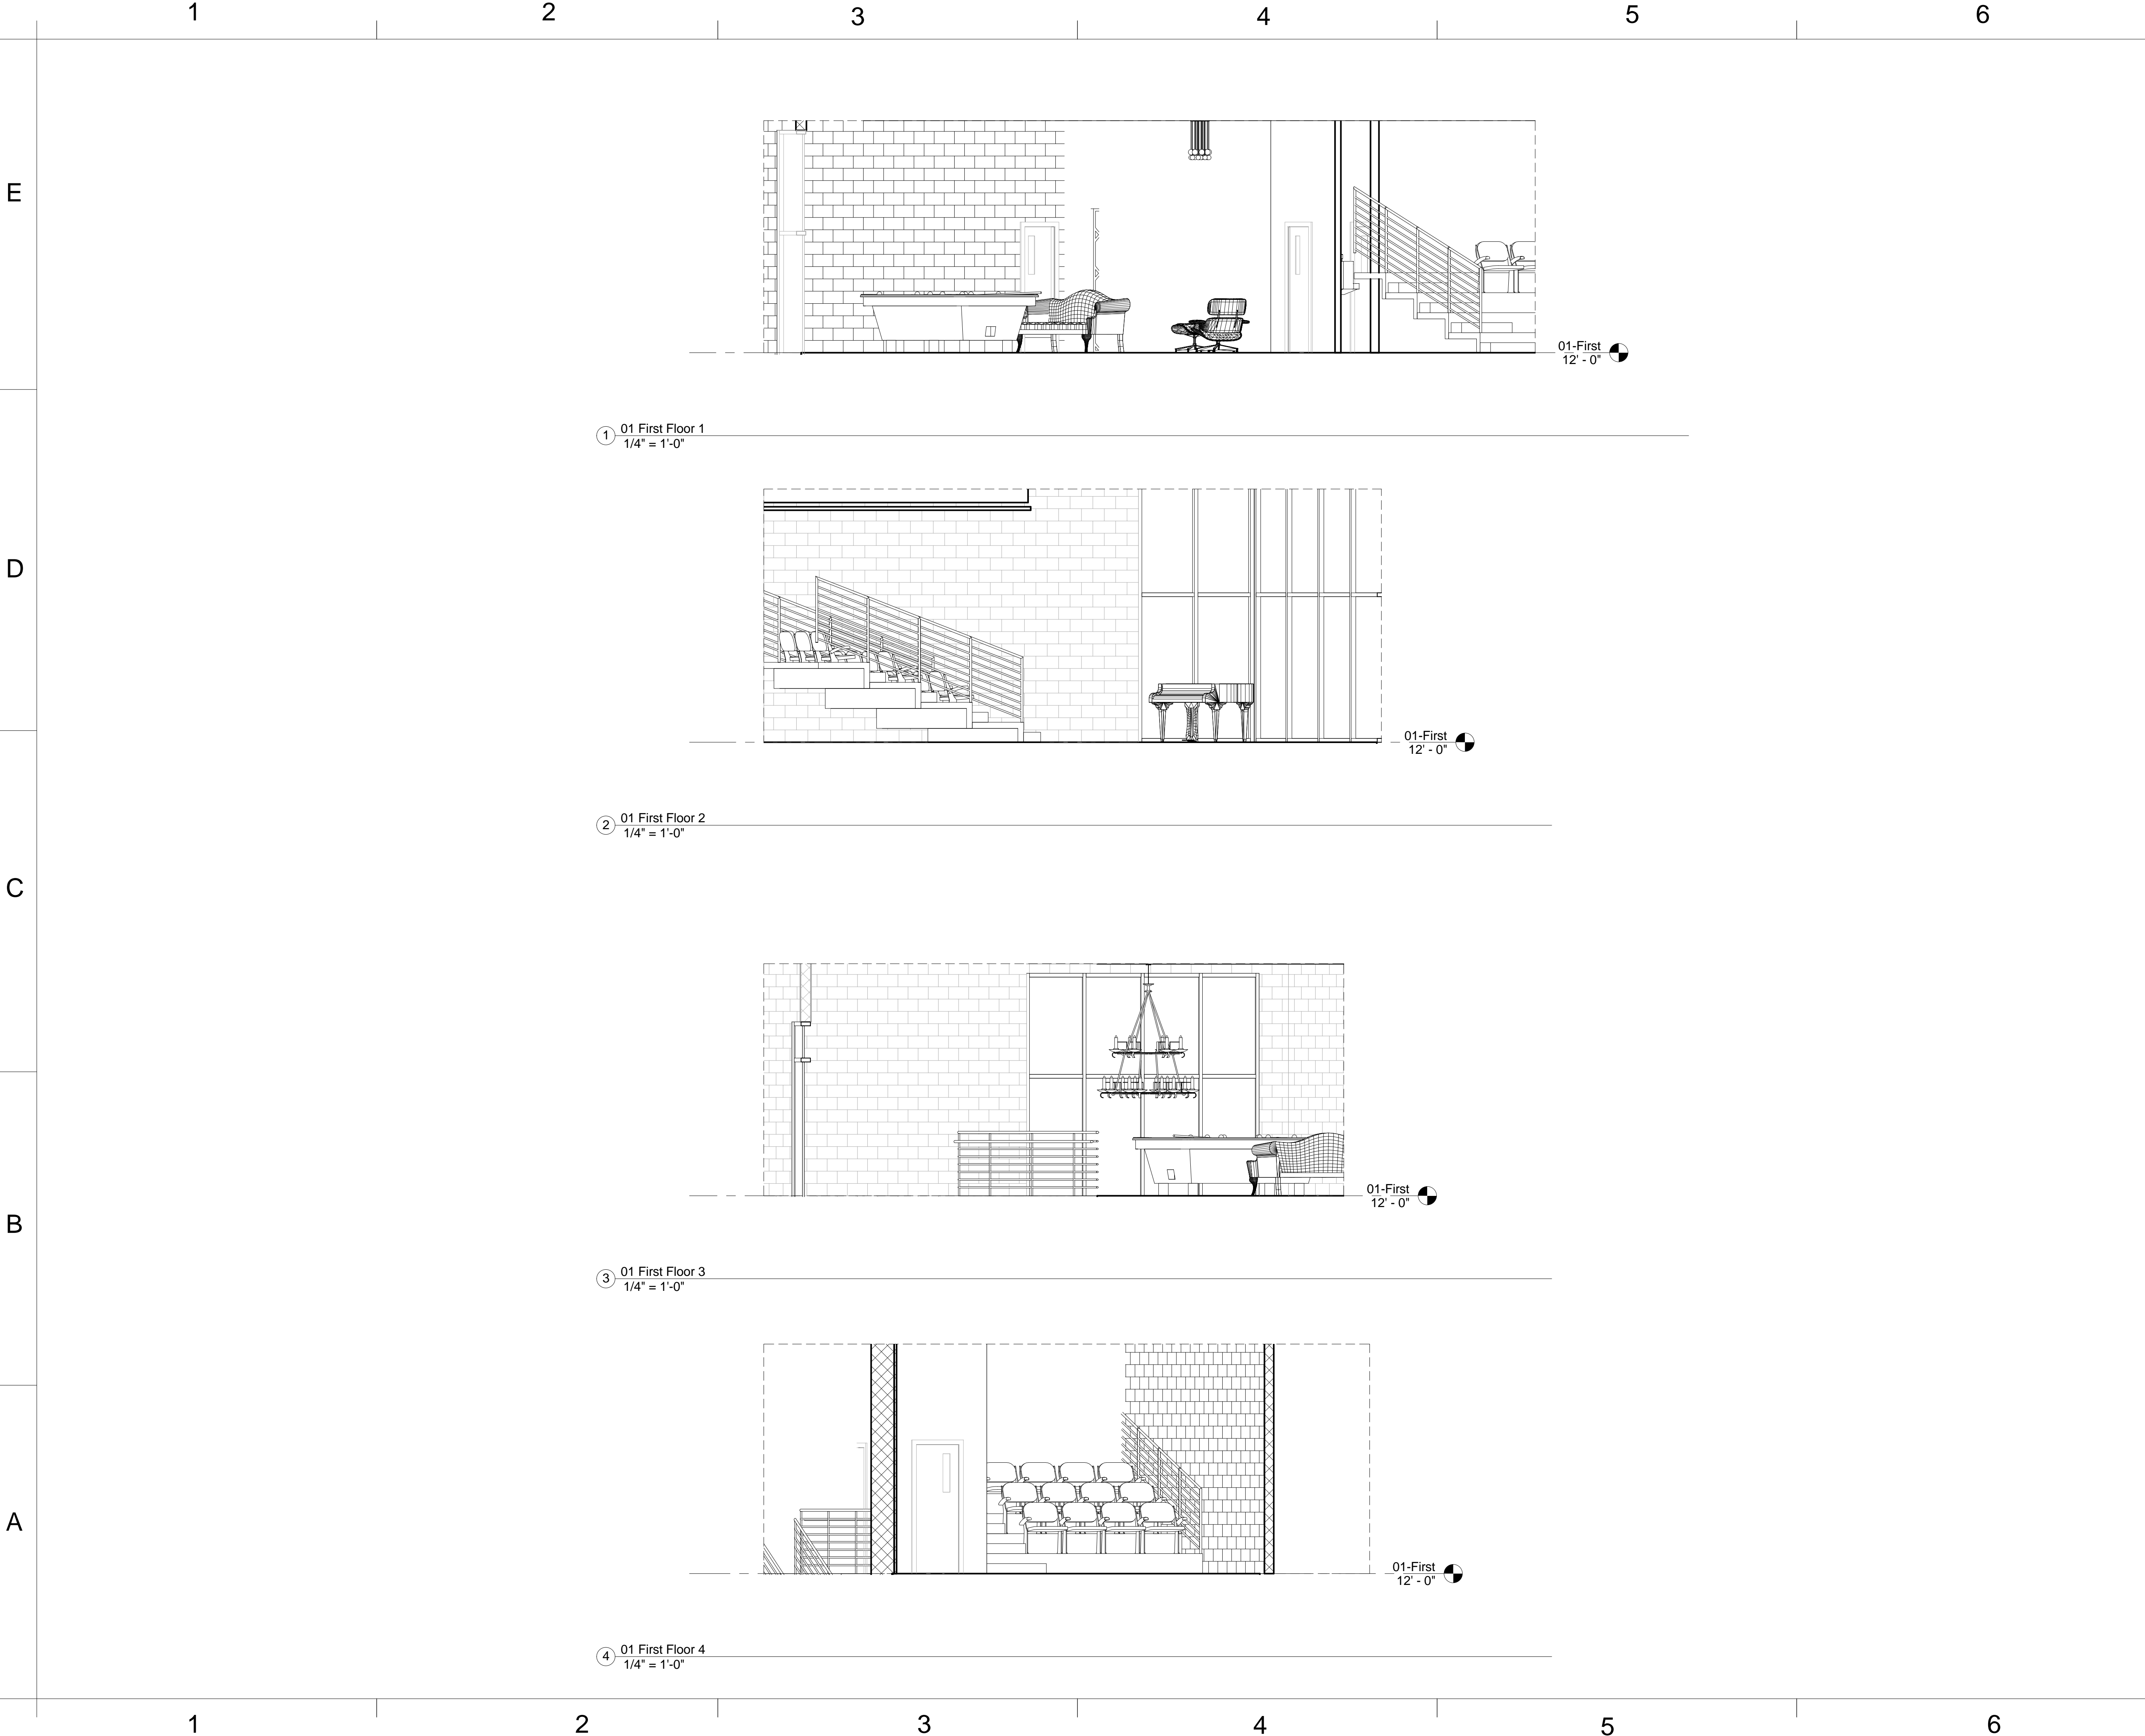

**YH DESIGN**

www.yhdesign.com

Consultant Prof. Christine Wacta  
Address Eichberg Hall  
Phone 912-228-2696

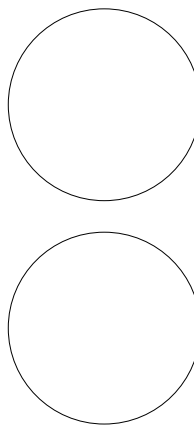

SCAD  
ELDS - 225-07  
FINAL

No.	Description	Date
HW 2B	house by the water	04/15/2013
HW 3	Pre-Final	04/24/2013
HW 4	Pre-Final	05/06/2013
HW 5	Pre-Final	05/13/2013

House by Water

INTERIOR  
ELEVATION --  
FIRST FLOOR

Project Number	Project Number
Date	May 1st, 2013
Drawn By	Yun Huang
Checked By	Prof. Wacta

A 207

Scale	1/4" = 1'-0"
-------	--------------






**YH DESIGN**

www.yhdesign.com

Consultant Prof. Christine Wacta  
Address Eichberg Hall  
Phone 912-228-2696

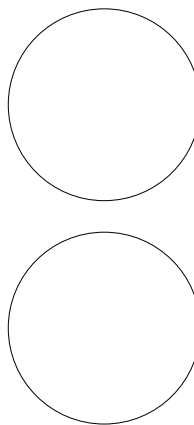

**SCAD  
ELDS - 225-07  
FINAL**

No.	Description	Date
HW 2B	house by the water	04/15/2013
HW 3	Pre-Final	04/24/2013
HW 4	Pre-Final	05/06/2013
HW 5	Pre- Final	05/13/2013


**House by Water**

**INTERIOR  
ELEVATION --  
SECOND FLOOR**

Project Number	Project Number
Date	May 1st, 2013
Drawn By	Yun Huang
Checked By	Prof. Wacta

**A 208**

Scale	1/4" = 1'-0"
-------	--------------

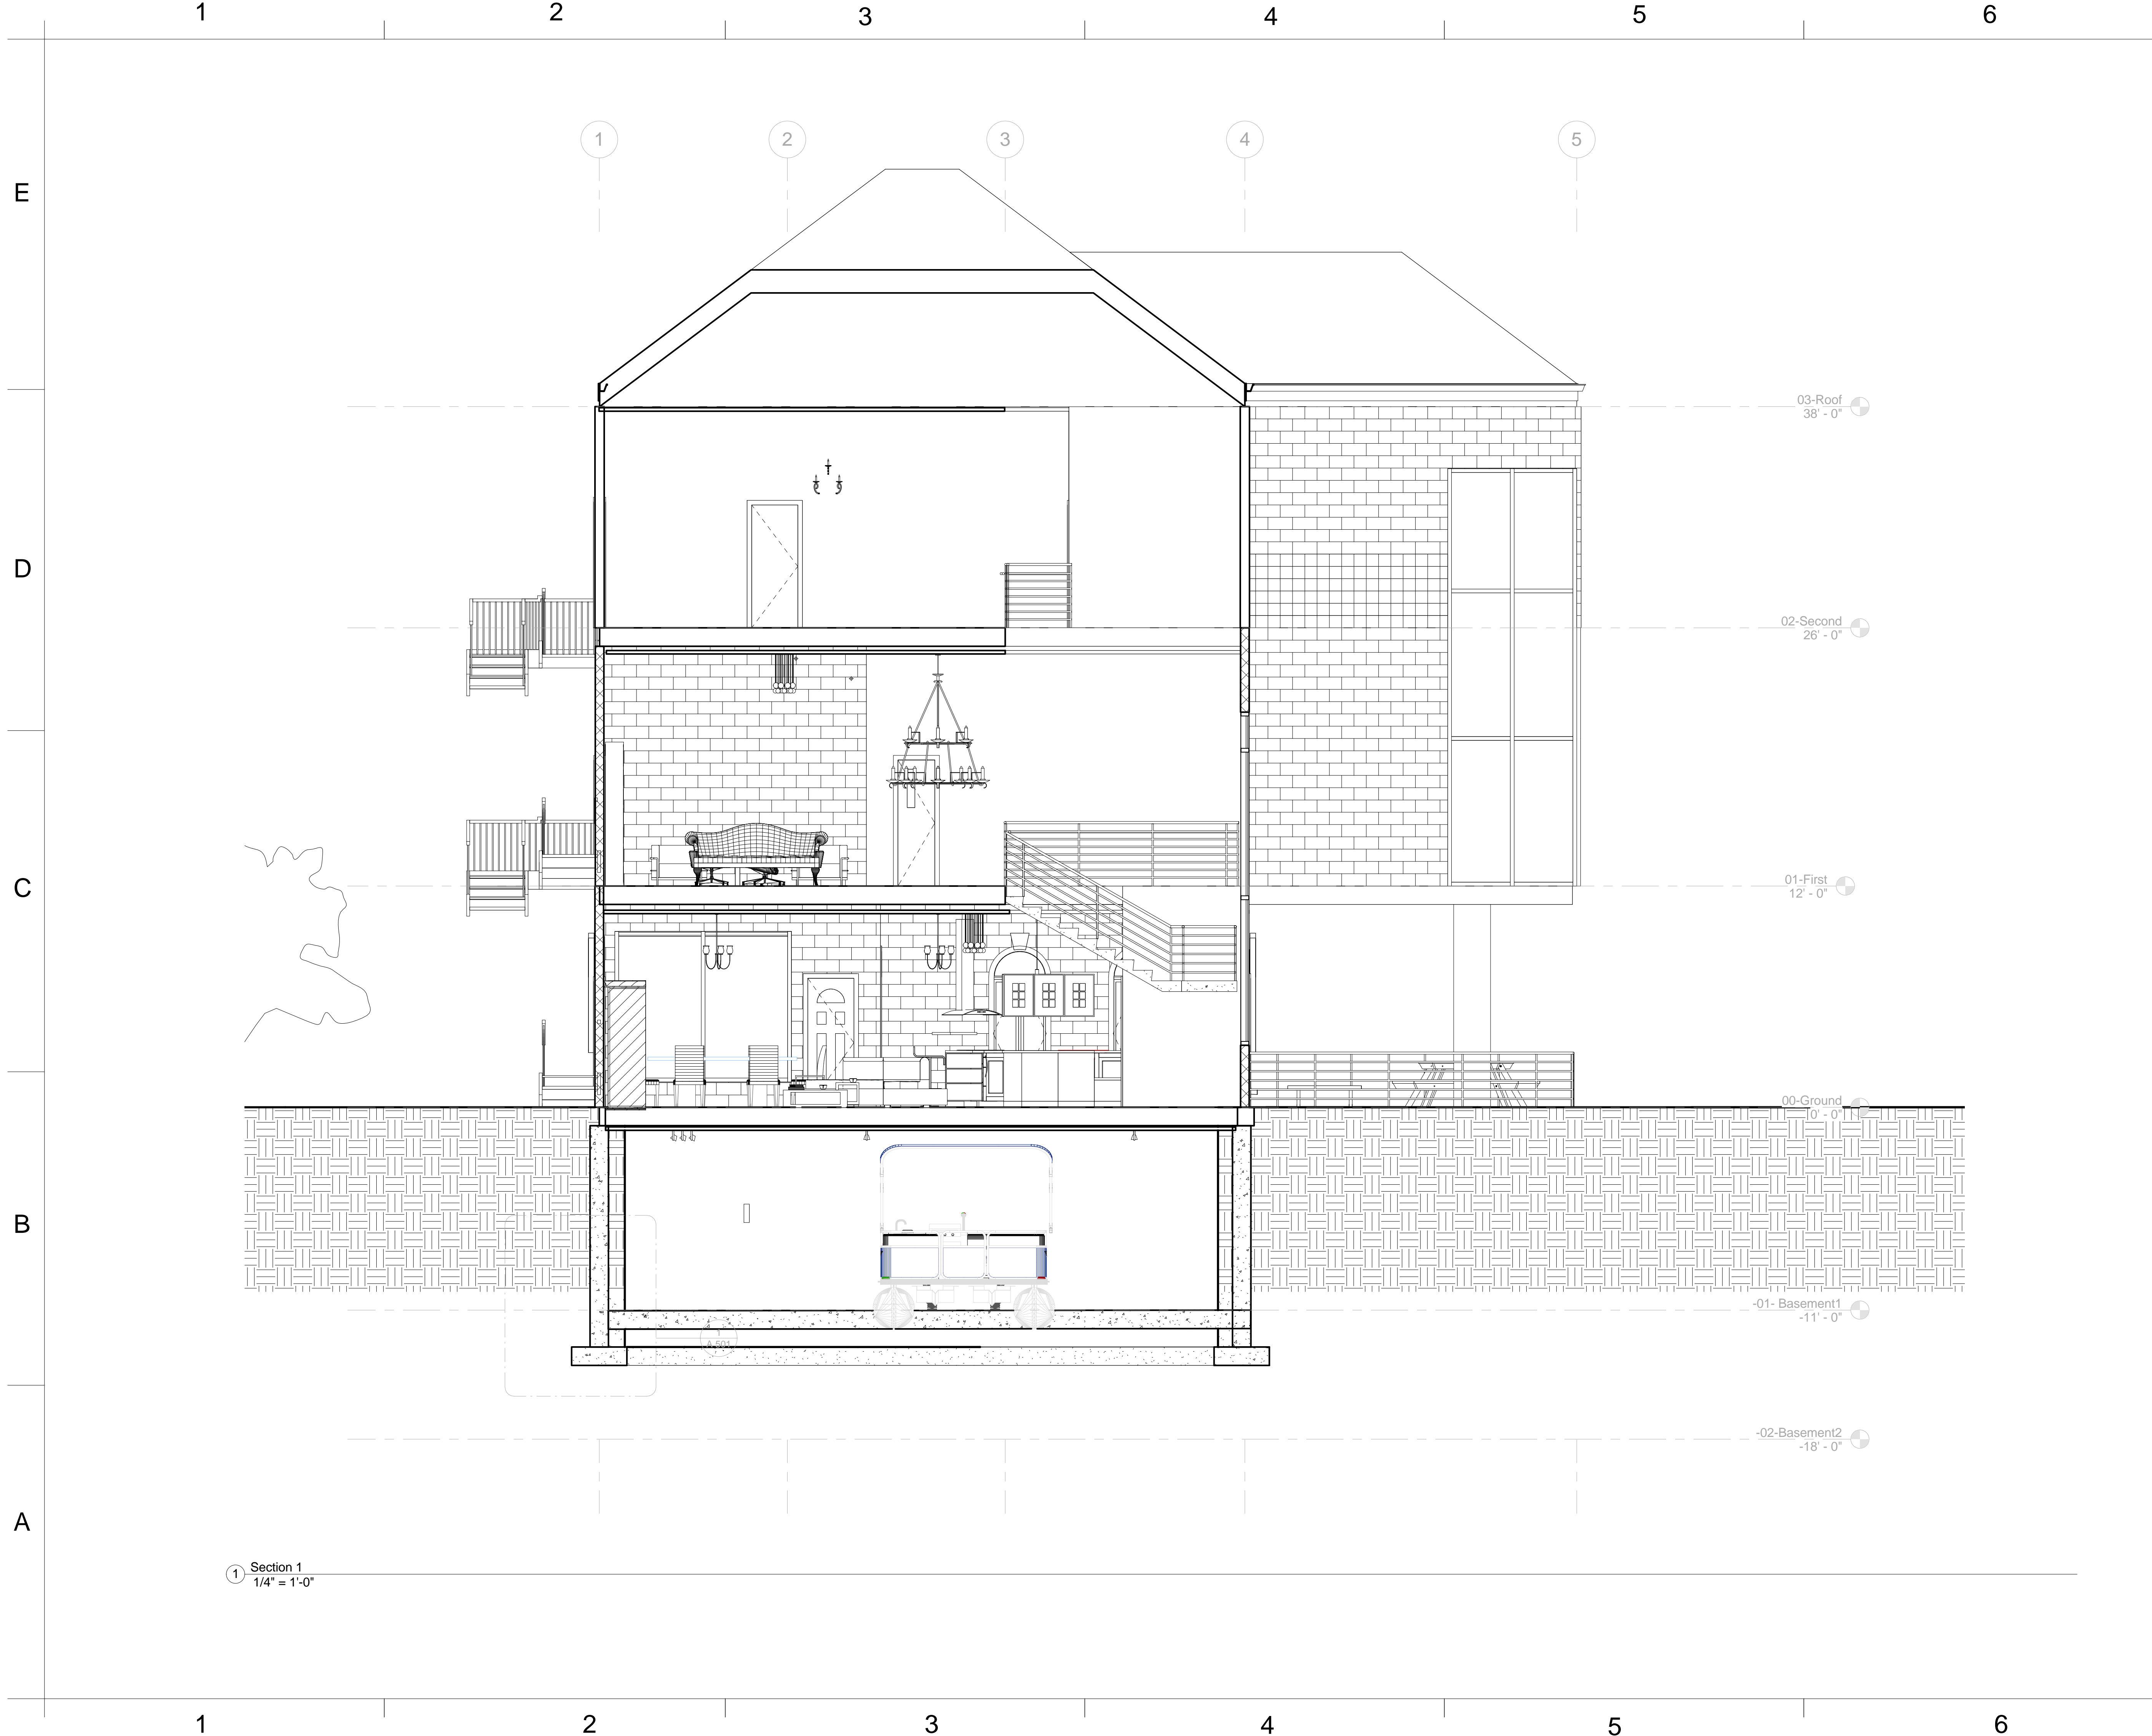

**YH DESIGN**

[www.yhdesign.com](http://www.yhdesign.com)

Consultant Prof. Christine Wacta  
Address Eichberg Hall  
Phone 912-228-2696

SCAD  
ELDS - 225-07  
FINAL

No.	Description	Date
HW 2B	house by the water	04/15/2013
HW 3	Pre-Final	04/24/2013
HW 4	Pre-Final	05/06/2013
HW 5	Pre-Final	05/13/2013

House by Water


SECTIONS

Project Number	Project Number
Date	May 1st, 2013
Drawn By	Yun Huang
Checked By	Prof. Wacta

A 301

Scale1/4" = 1'-0"



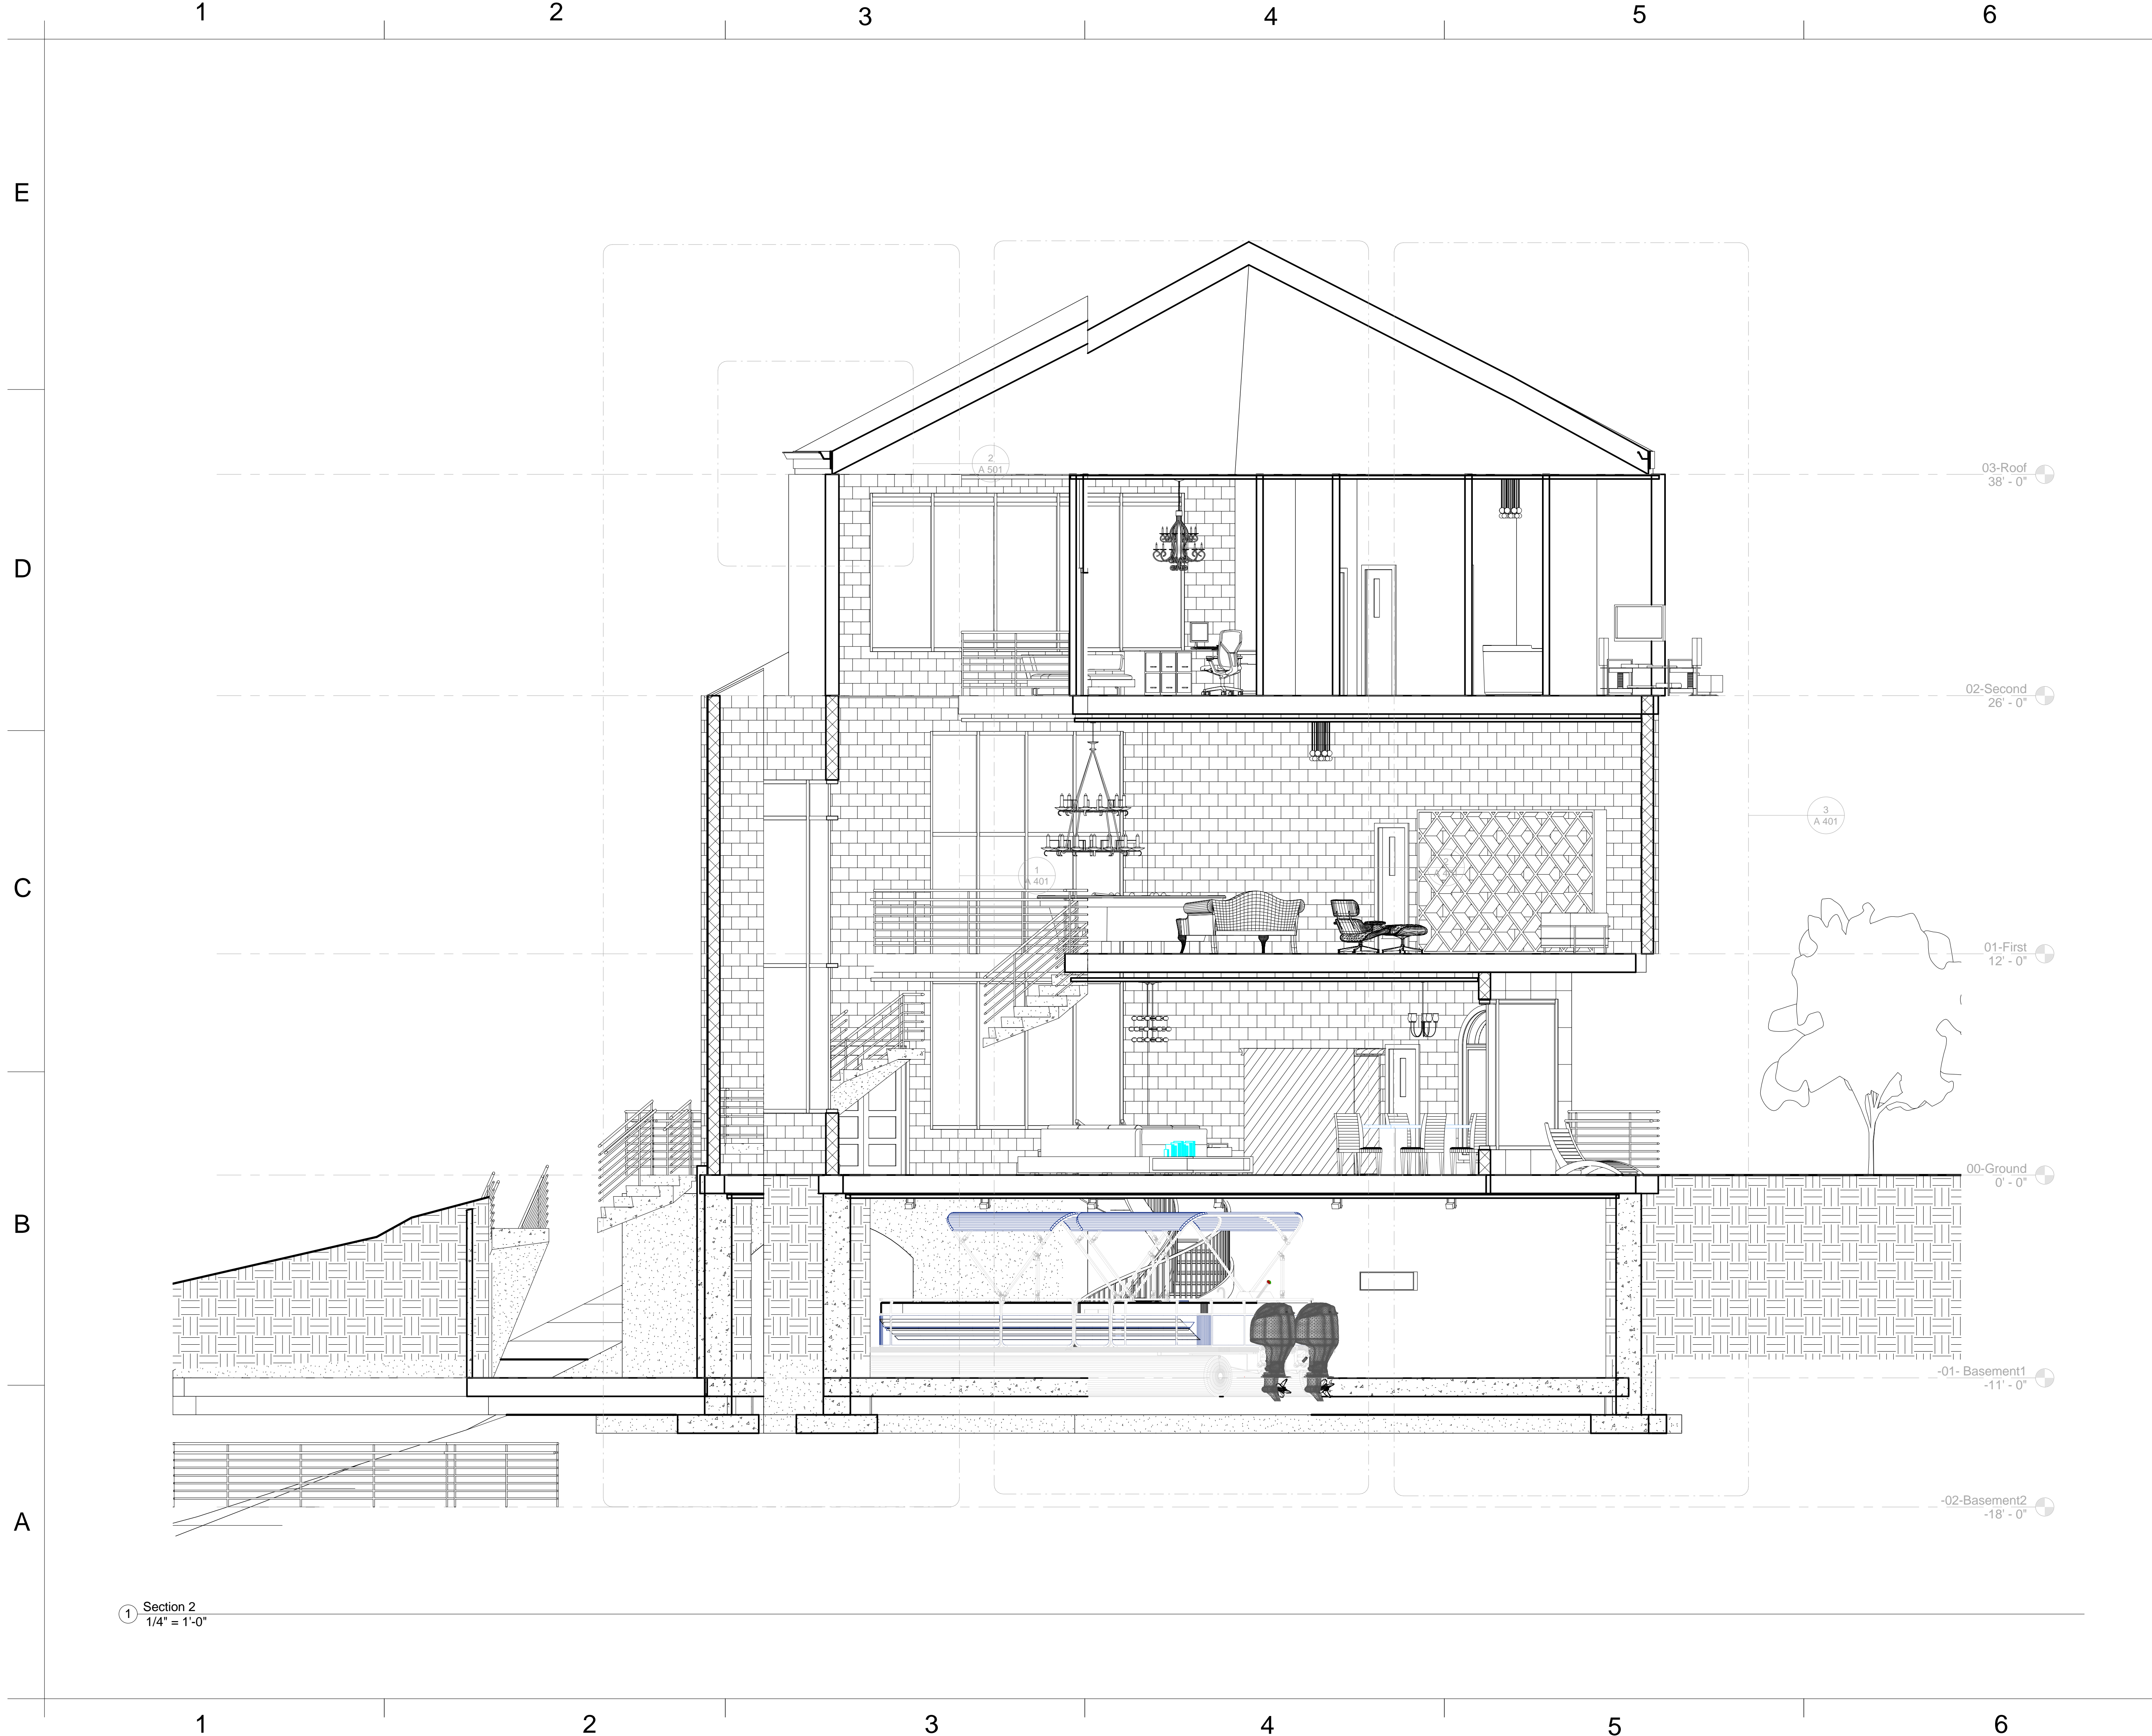

**YH DESIGN**

www.yhdesign.com

Consultant Prof. Christine Wacta  
Address Eichberg Hall  
Phone 912-228-2696

SCAD  
ELDS - 225-07  
FINAL

No.	Description	Date
HW 2B	house by the water	04/15/2013
HW 3	Pre-Final	04/24/2013
HW 4	Pre-Final	05/06/2013
HW 5	Pre-Final	05/13/2013

House by Water

SECTIONS


Project Number  
Date  
Drawn By  
Checked By

Project Number  
May 1st, 2013  
Yun Huang  
Prof. Wacta

A 302

Scale1/4" = 1'-0"

5/30/2013 11:34:08 AM

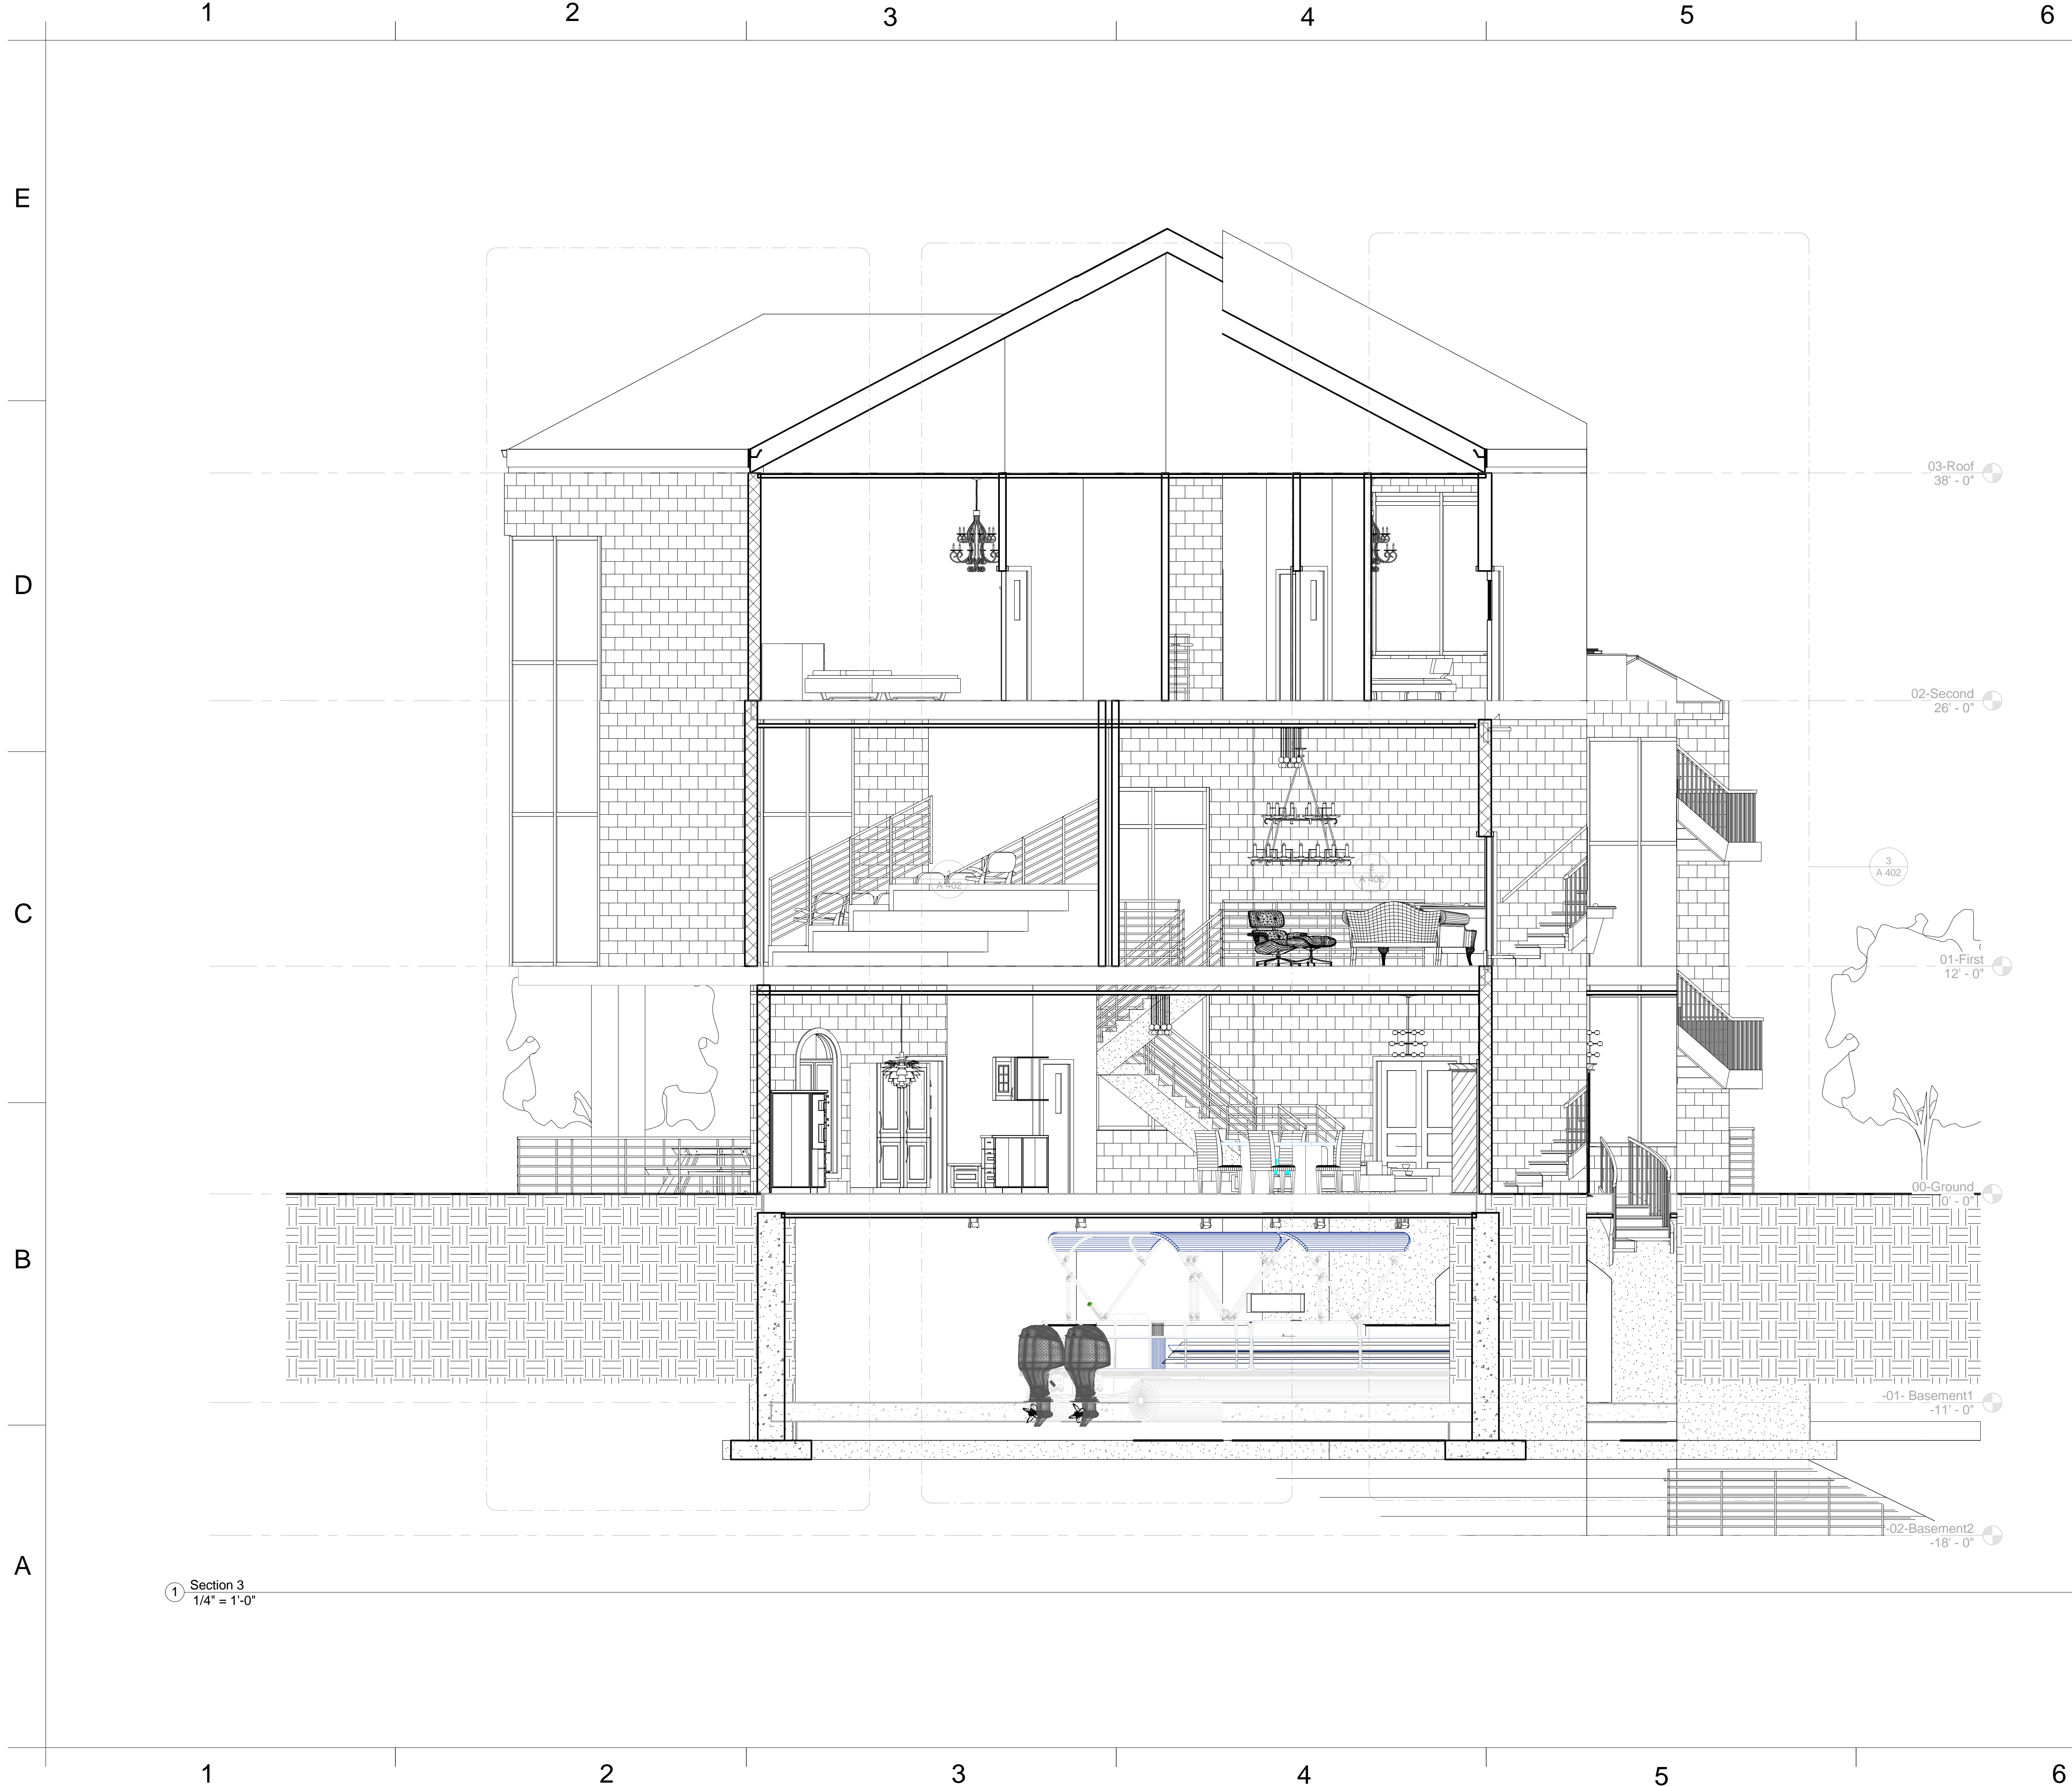


① Section 3  
1/4" = 1'-0"

**YH DESIGN**

www.yhdesign.com

Consultant Prof. Christine Wacta  
Address Eichberg Hall  
Phone 912-228-2696

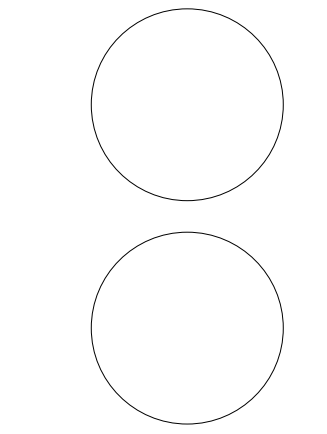

**SCAD  
ELDS - 225-07  
FINAL**

No.	Description	Date
HW 2B	house by the water	04/15/2013
HW 3	Pre-Final	04/24/2013
HW 4	Pre-Final	05/06/2013
HW 5	Pre-Final	05/13/2013

House by Water

**SECTIONS**

Project Number	Project Number
Date	May 1st, 2013
Drawn By	Yun Huang
Checked By	Prof. Wacta

**A 303**

Scale	1/4" = 1'-0"
-------	--------------






**YH DESIGN**

www.yhdesign.com

Consultant Prof. Christine Wacta  
Address Eichberg Hall  
Phone 912-228-2696

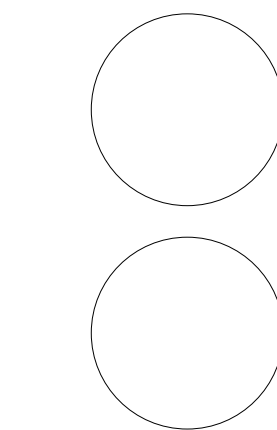

**SCAD  
ELDS - 225-07  
FINAL**

No.	Description	Date
HW 2B	house by the water	04/15/2013
HW 3	Pre-Final	04/24/2013
HW 4	Pre-Final	05/06/2013
HW 5	Pre-Final	05/13/2013

**House by Water**

**ENLARGED  
SECTIONS**

Project Number	Project Number
Date	May 1st, 2013
Drawn By	Yun Huang
Checked By	Prof. Wacta

**A 401**

Scale	1/4" = 1'-0"
-------	--------------



**YH DESIGN**

www.yhdesign.com

Consultant Prof. Christine Wacta  
Address Eichberg Hall  
Phone 912-228-2696

SCAD  
ELDS - 225-07  
FINAL

No.	Description	Date
HW 2B	house by the water	04/15/2013
HW 3	Pre-Final	04/24/2013
HW 4	Pre-Final	05/06/2013
HW 5	Pre- Final	05/13/2013

House by Water


ENLARGED  
SECTIONS

Project Number	Project Number
Date	May 1st, 2013
Drawn By	Yun Huang
Checked By	Prof. Wacta

A 402

Scale	1/4" = 1'-0"
-------	--------------




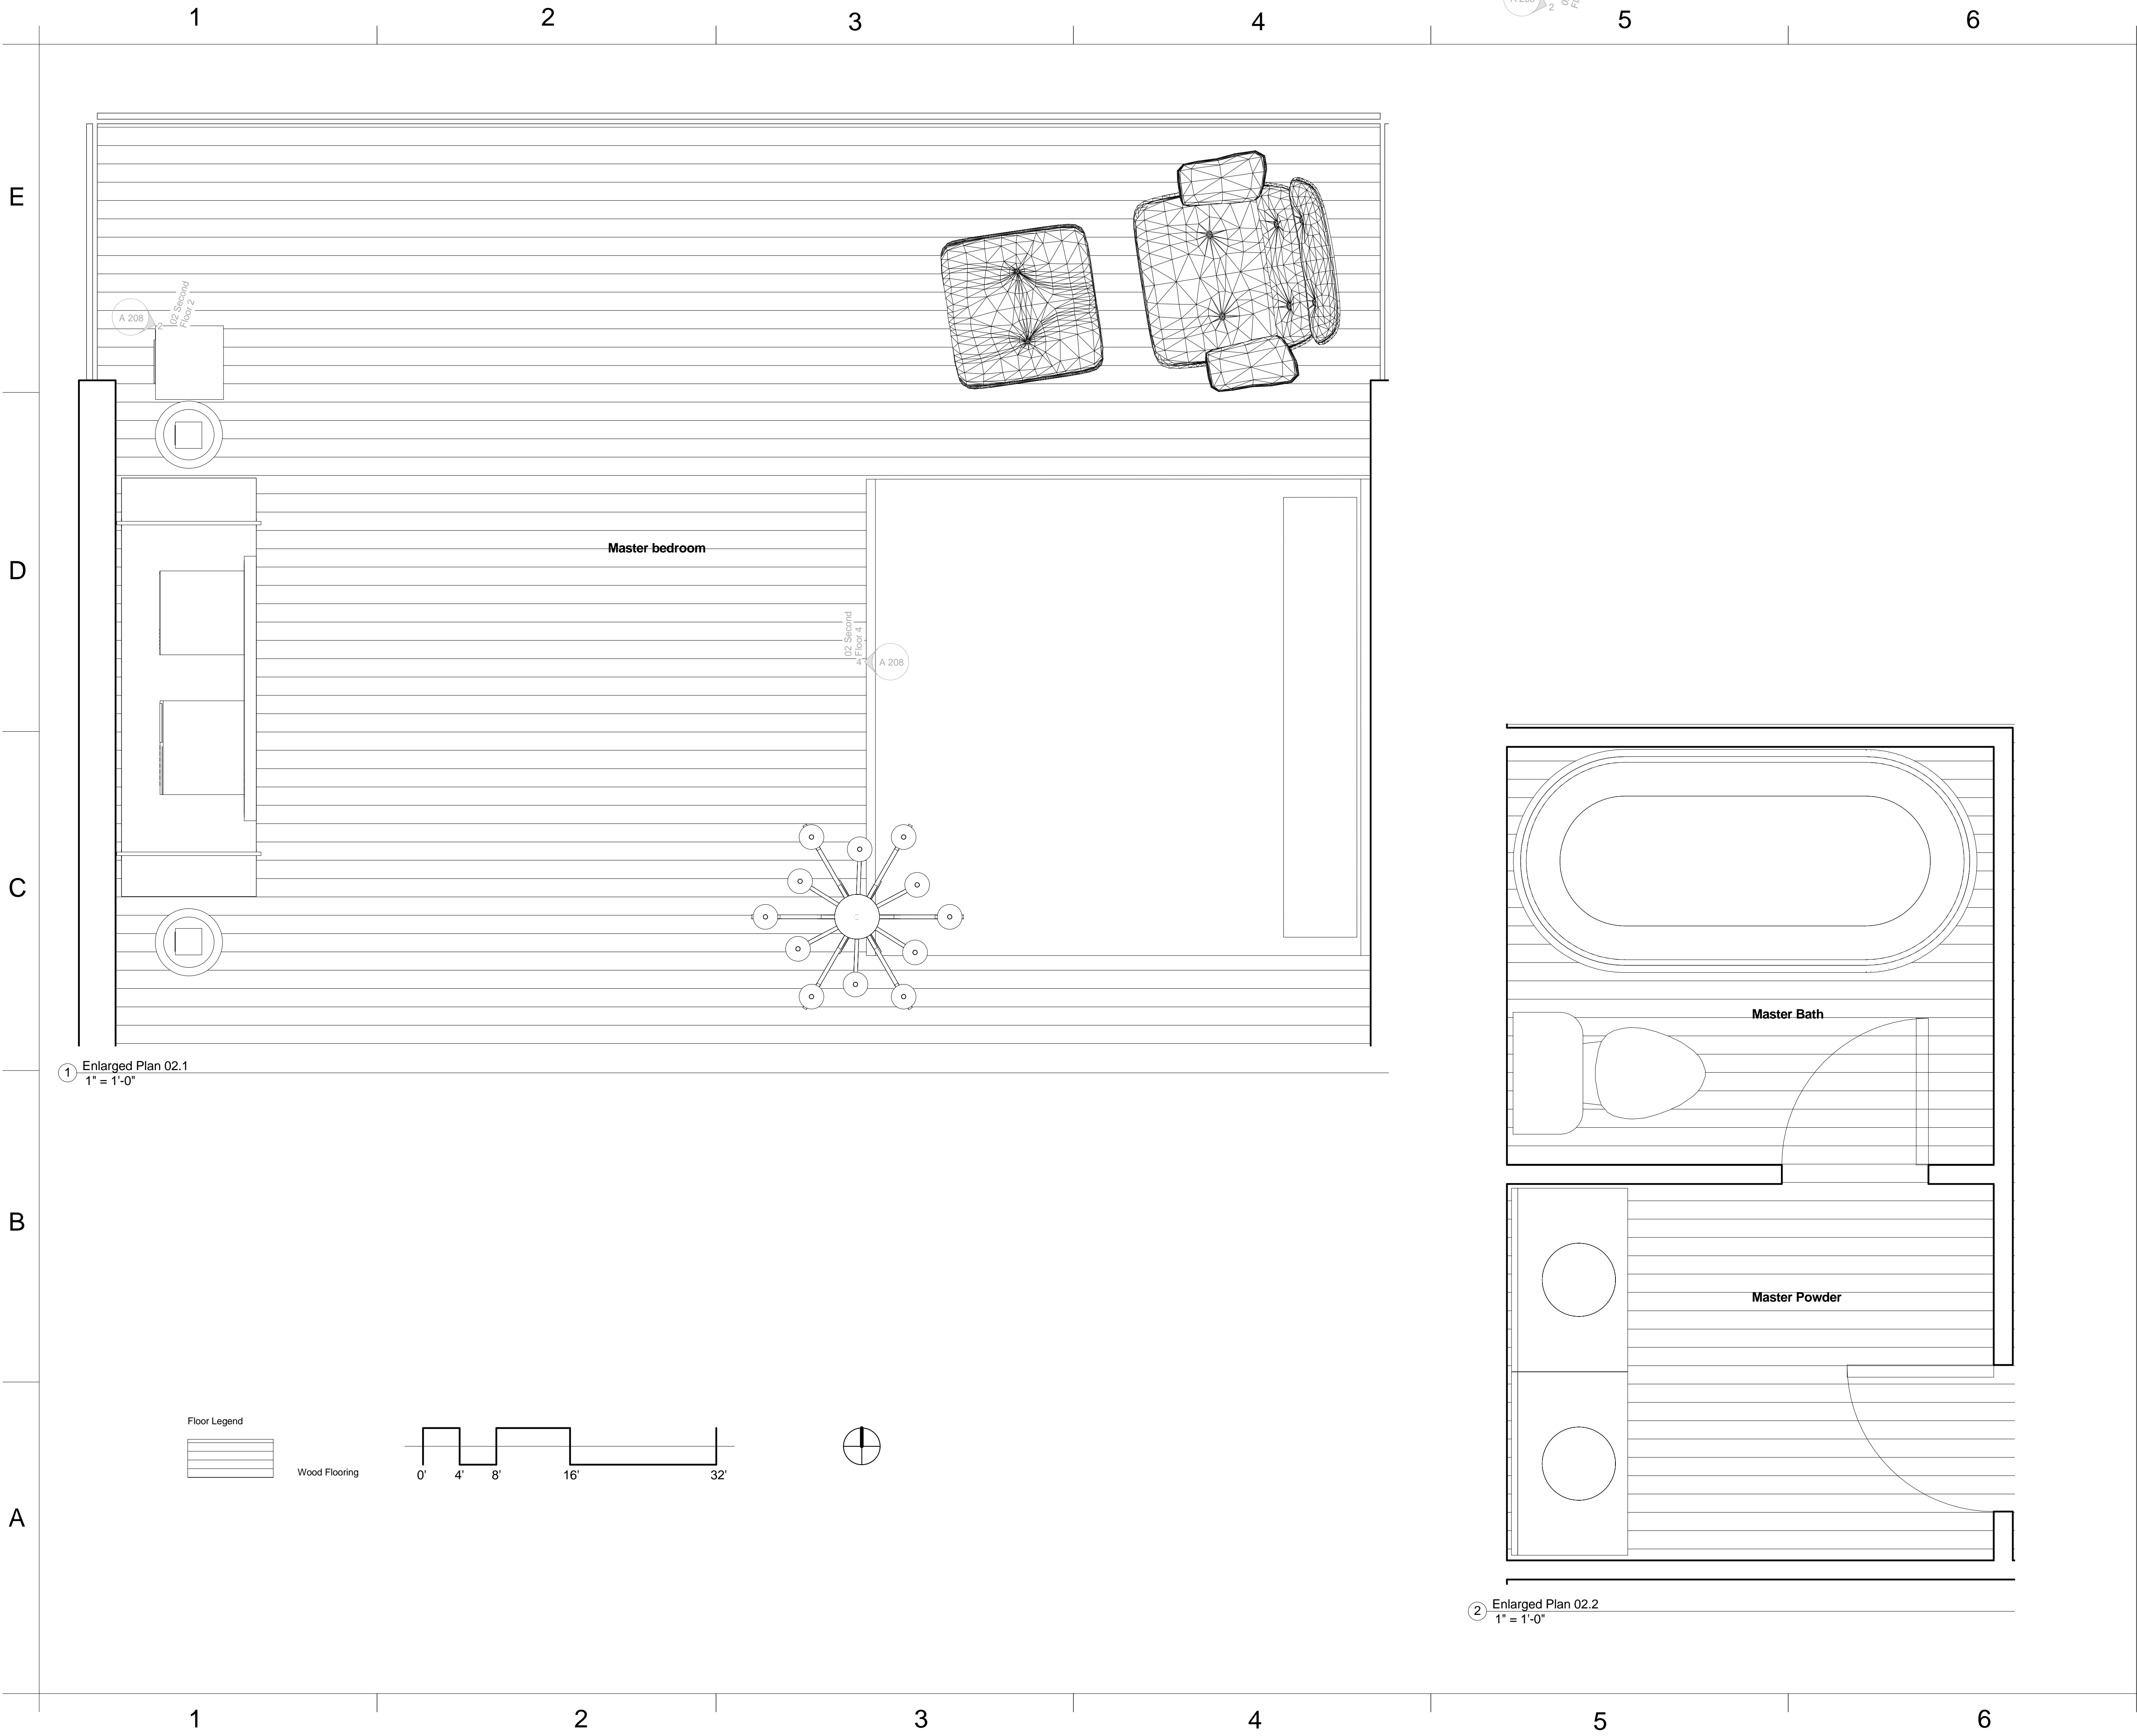

**YH DESIGN**

www.yhdesign.com

Consultant Prof. Christine Wacta  
Address Eichberg Hall  
Phone 912-228-2696

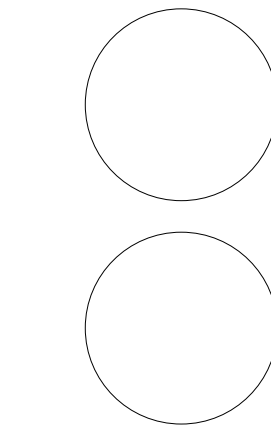

**SCAD  
ELDS - 225-07  
FINAL**

No.	Description	Date
HW 2B	house by the water	04/15/2013
HW 3	Pre-Final	04/24/2013
HW 4	Pre-Final	05/06/2013
HW 5	Pre-Final	05/13/2013


House by Water

**ENLARGE PLANS  
-- MASTER  
BEDROOM**


Project Number	Project Number
Date	May 1st, 2013
Drawn By	Yun Huang
Checked By	Prof. Wacta

**A 403**




Scale As indicated

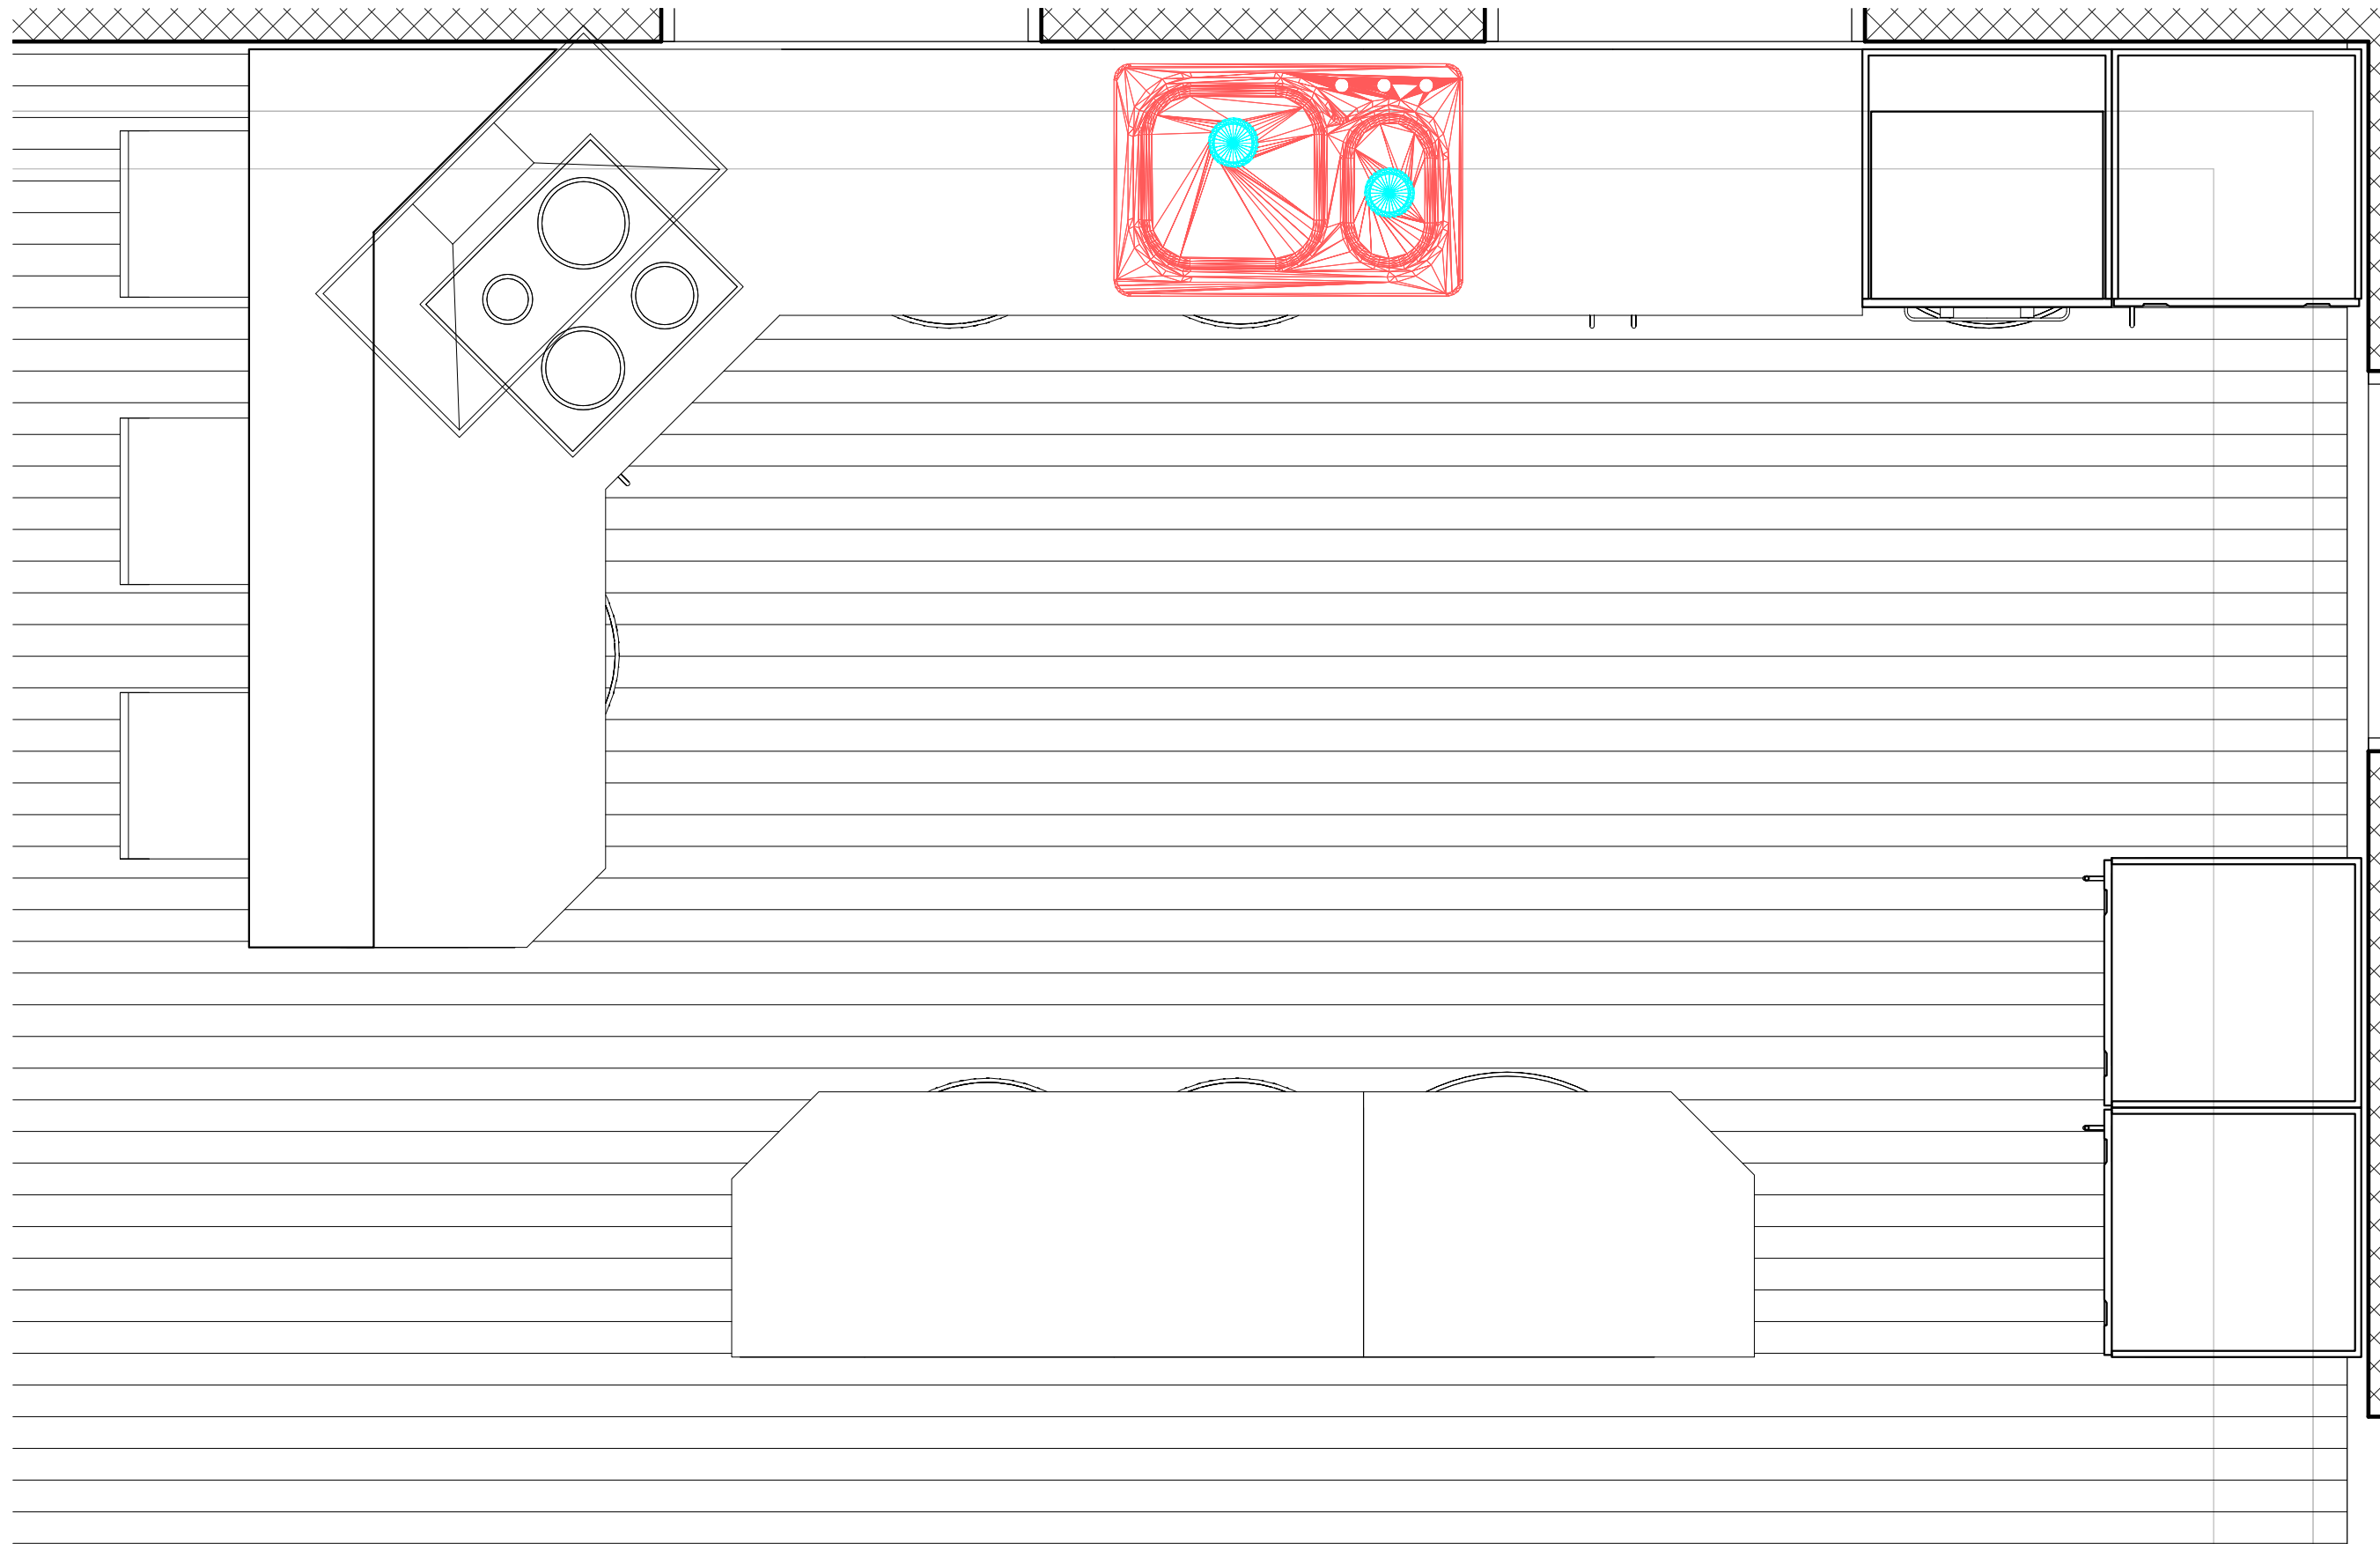

① Enlarged plan 00.1  
3/4" = 1'-0"

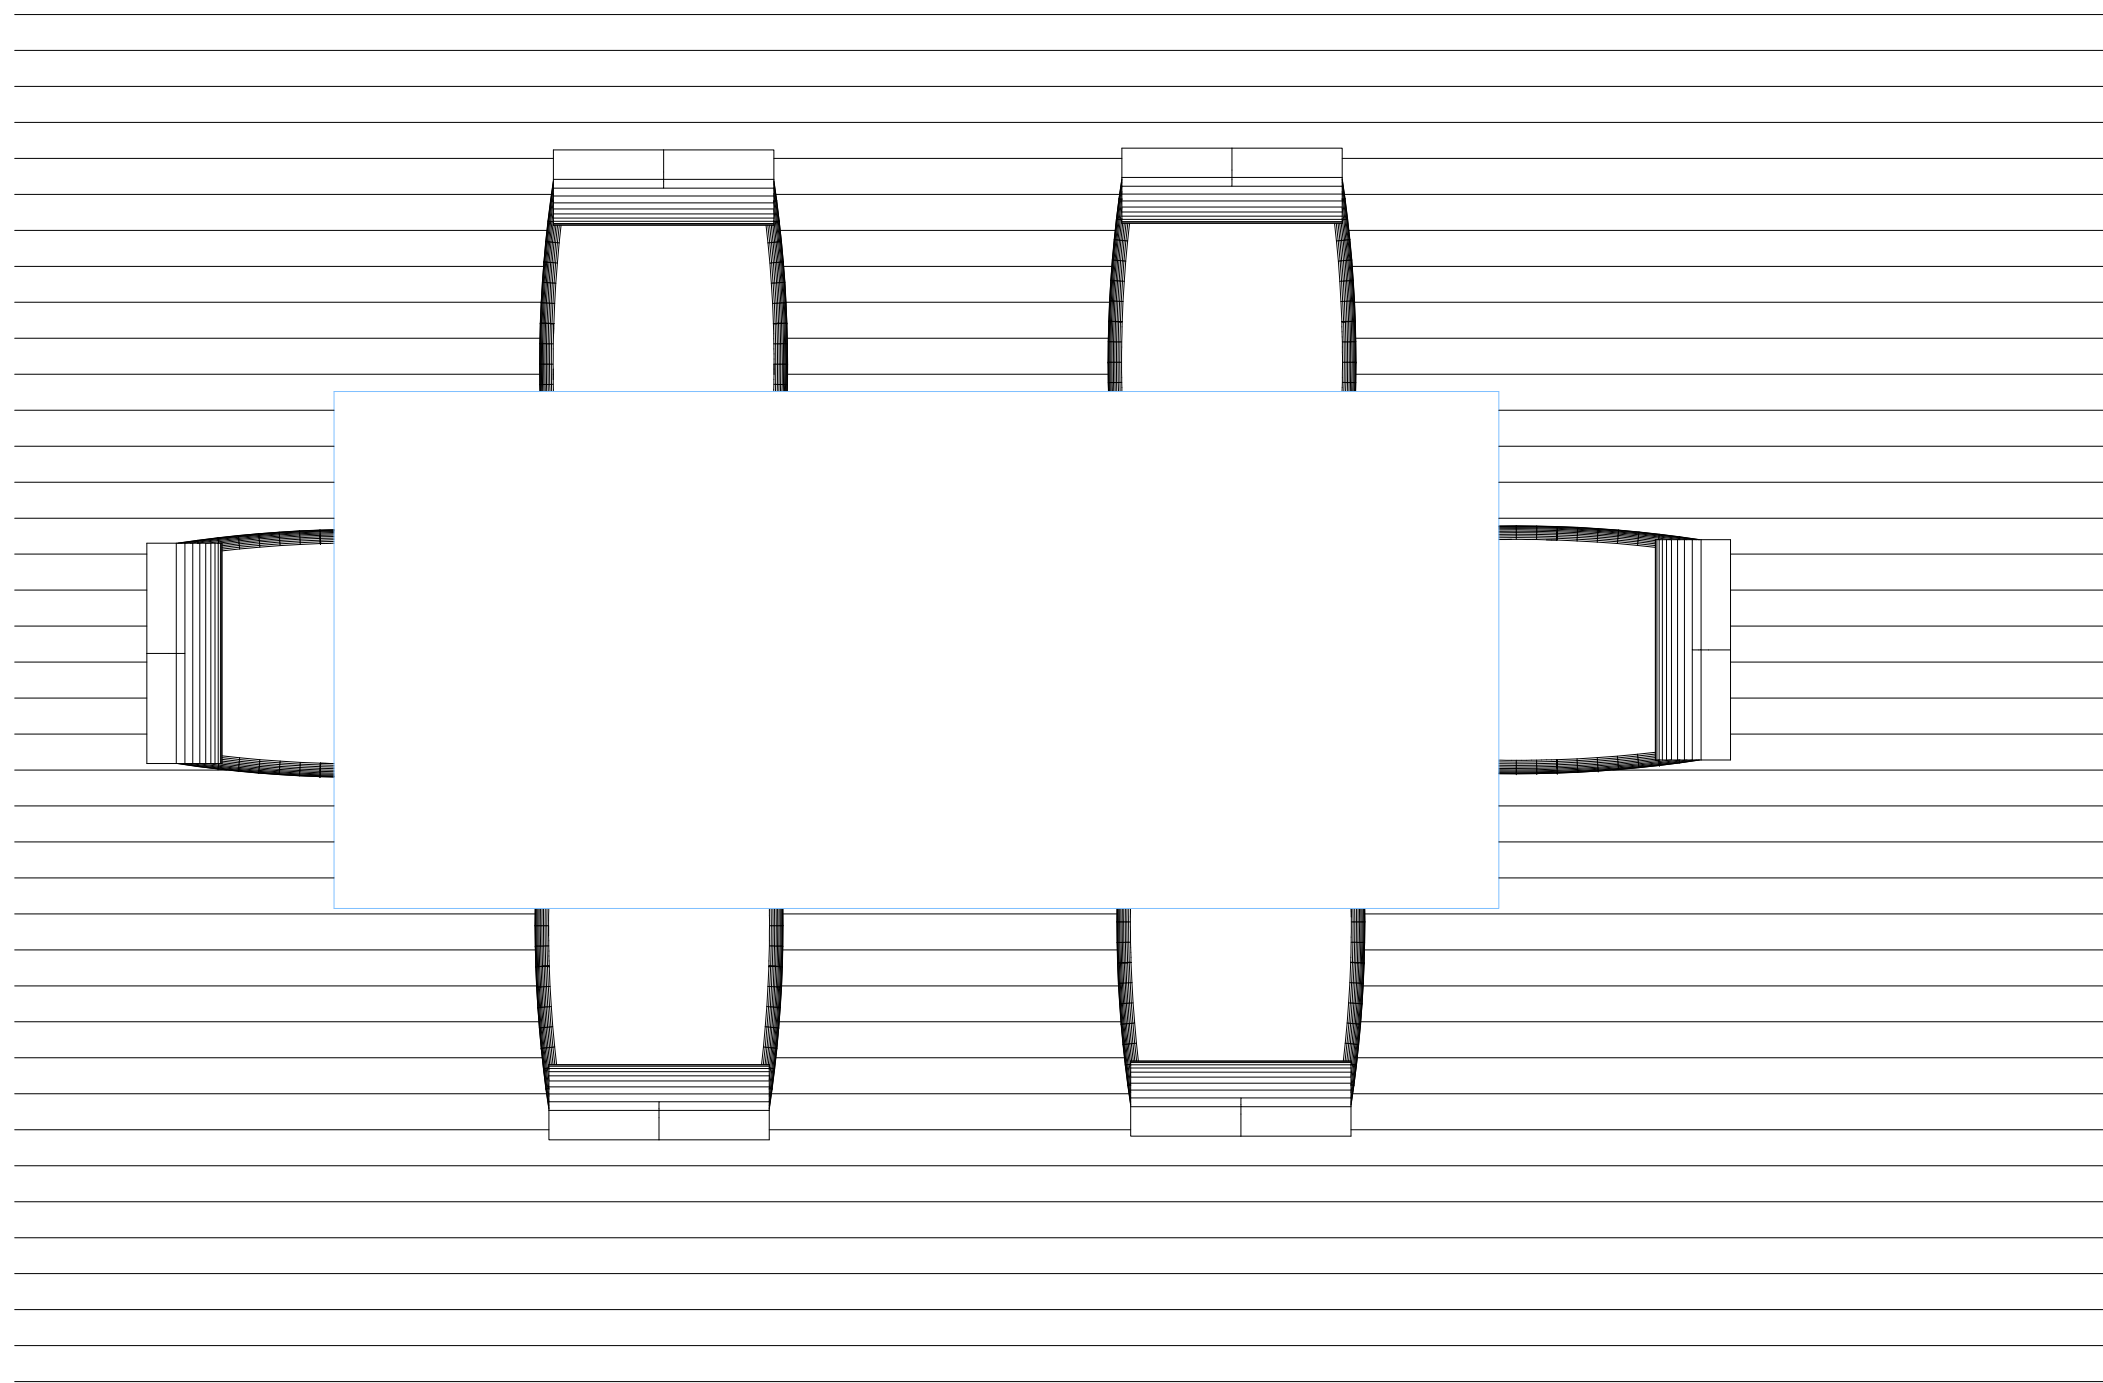


② Enlarged Plan 00.2  
3/4" = 1'-0"

 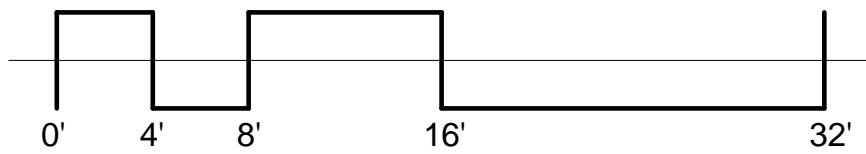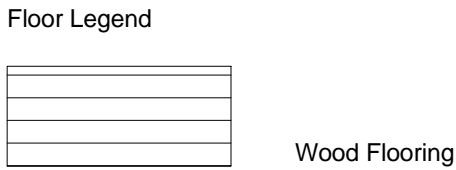

**YH DESIGN**

www.yhdesign.com

Consultant Prof. Christine Wacta  
Address Eichberg Hall  
Phone 912-228-2696

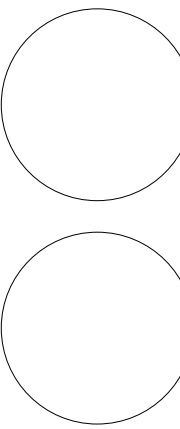

**SCAD  
ELDS - 225-07  
FINAL**

No.	Description	Date
HW 2B	house by the water	04/15/2013
HW 3	Pre-Final	04/24/2013
HW 4	Pre-Final	05/06/2013
HW 5	Pre- Final	05/13/2013

House by Water


**ENLARGE PLANS  
-- KITCHEN &  
DINING AREA**

Project Number	Project Number
Date	May 1st, 2013
Drawn By	Yun Huang
Checked By	Prof. Wacta

**A 404**

Scale As indicated




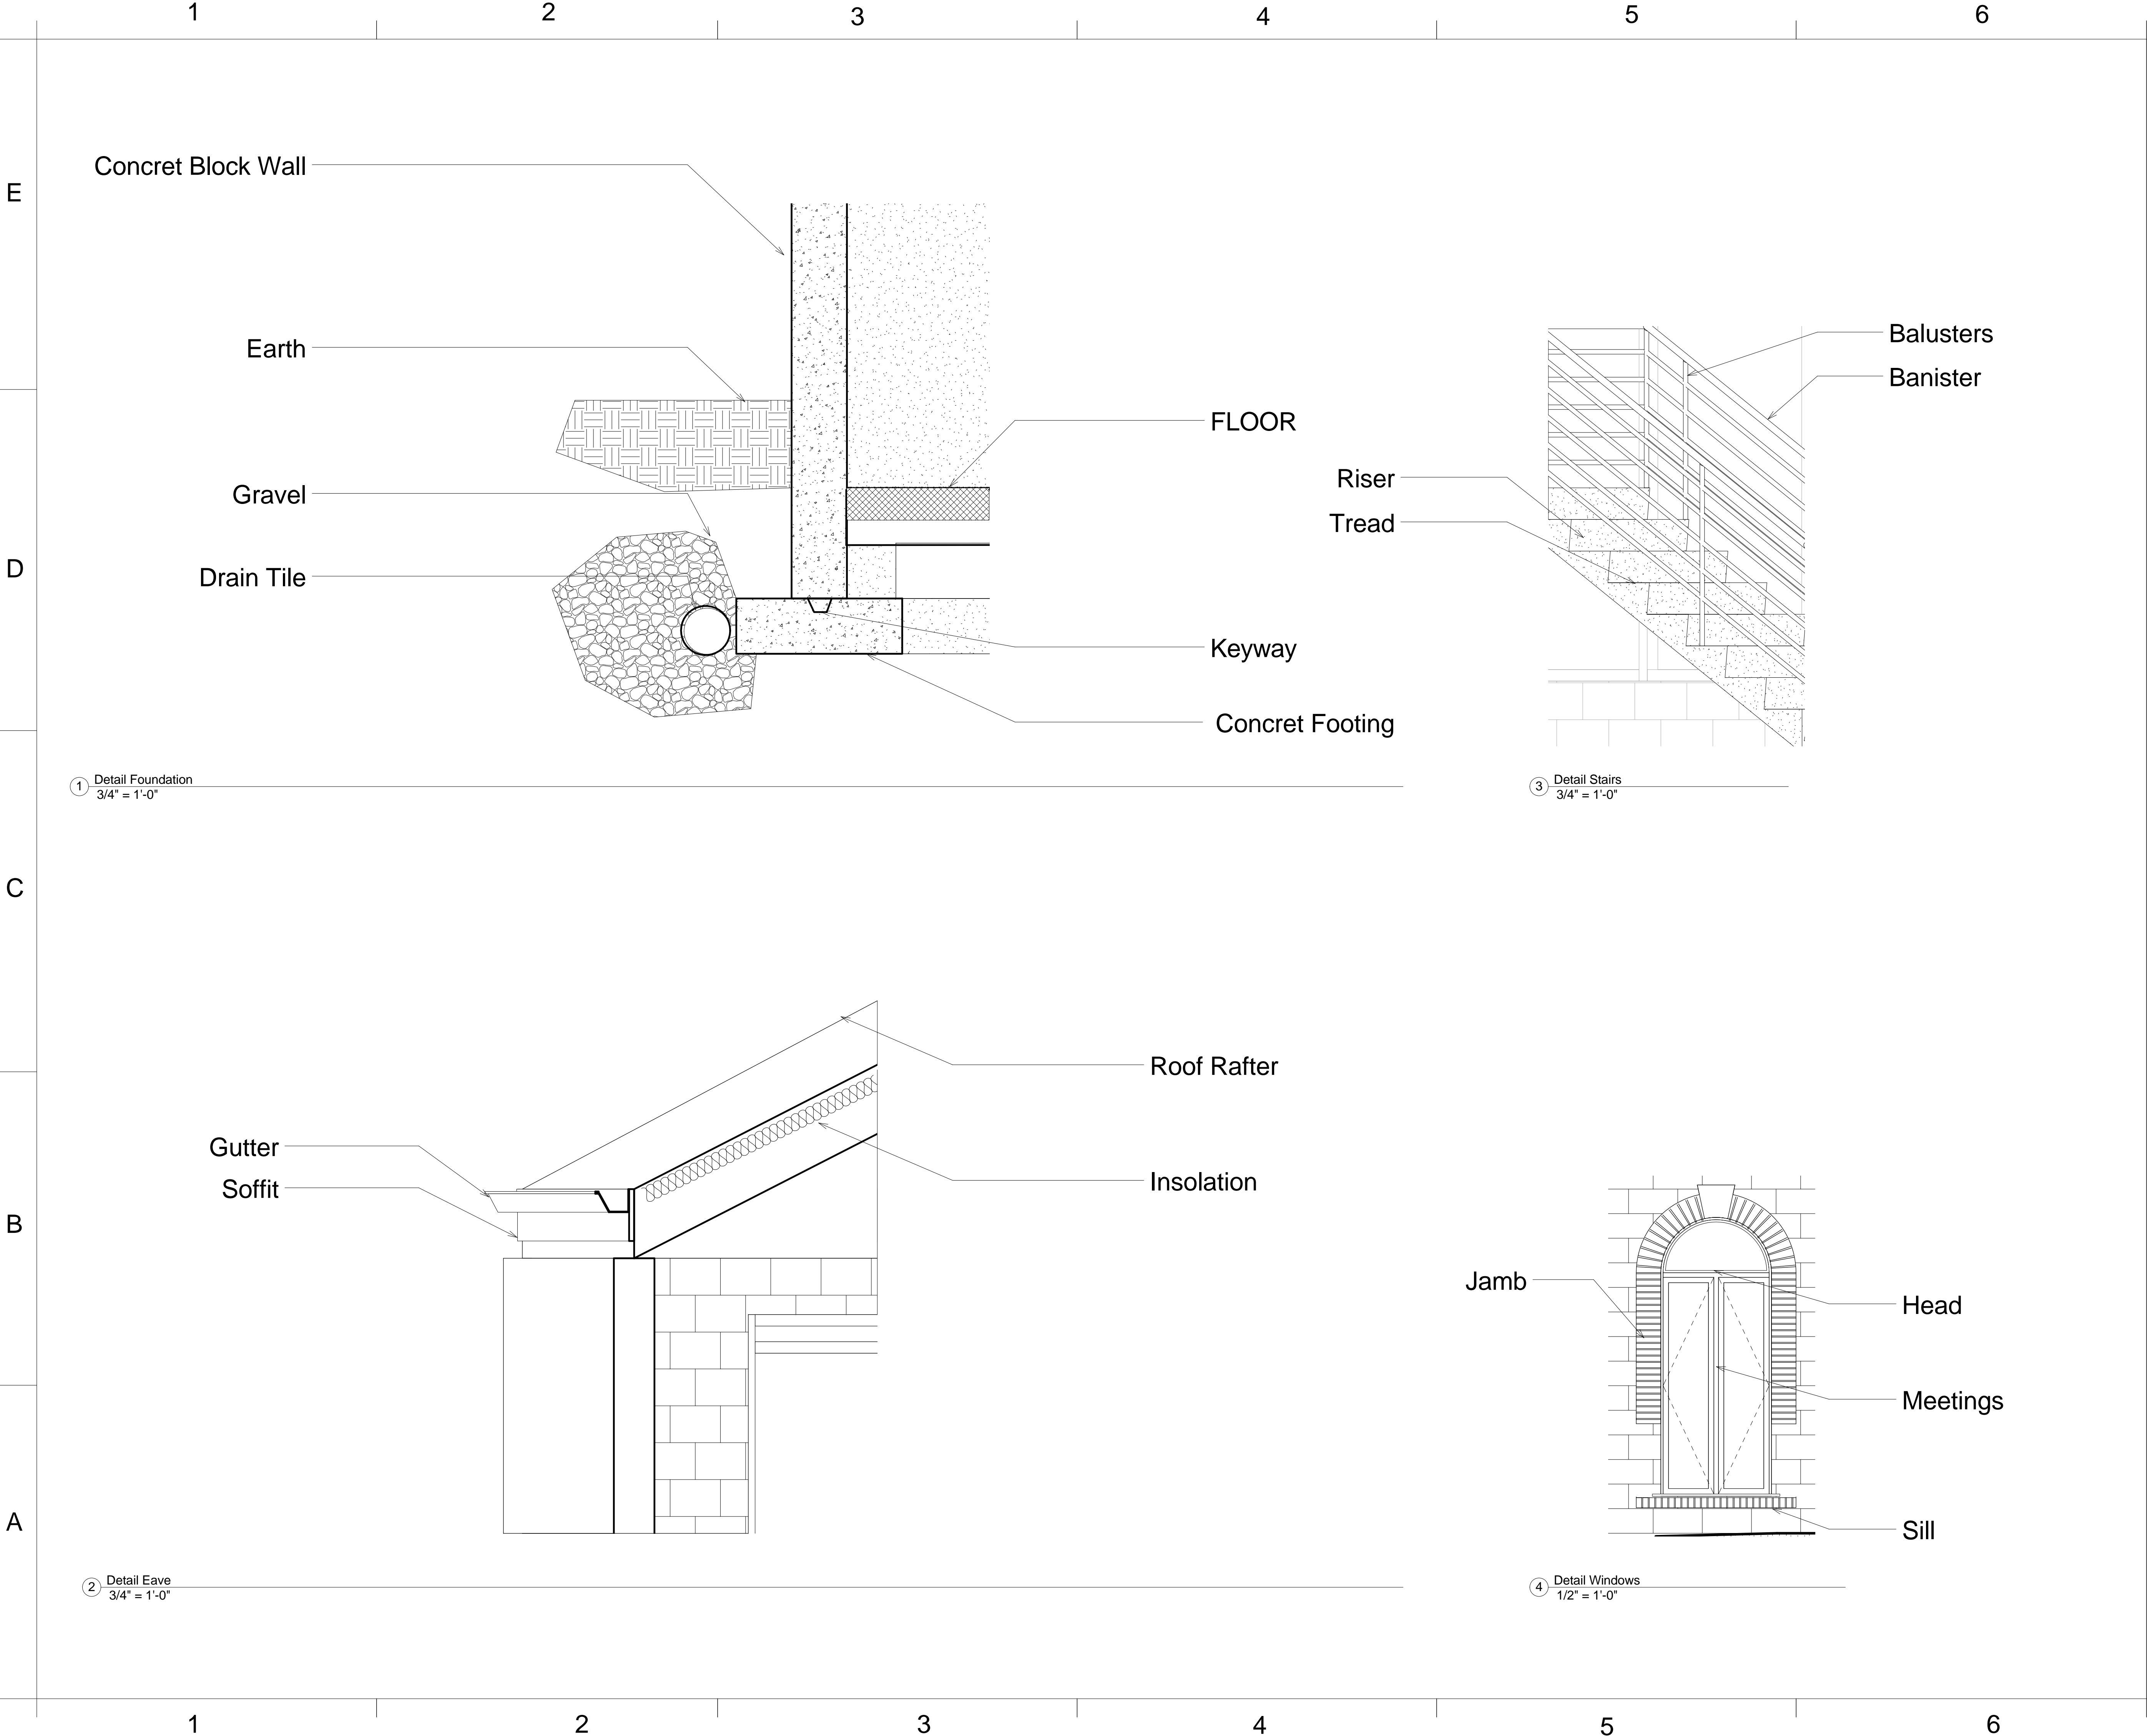

**YH DESIGN**

www.yhdesign.com

Consultant Prof. Christine Wacta  
Address Eichberg Hall  
Phone 912-228-2696

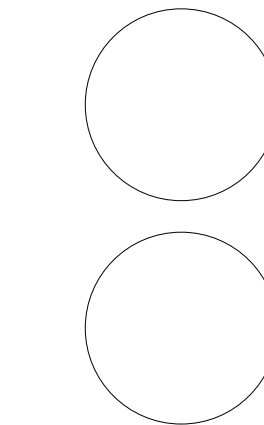

**SCAD  
ELDS - 225-07  
FINAL**

No.	Description	Date
HW 2B	house by the water	04/15/2013
HW 3	Pre-Final	04/24/2013
HW 4	Pre-Final	05/06/2013
HW 5	Pre- Final	05/13/2013


**House by Water**

**DETAILS**

Project Number	Project Number
Date	May 1st, 2013
Drawn By	Yun Huang
Checked By	Prof. Wacta

**A 501**


Scale	As indicated
-------	--------------

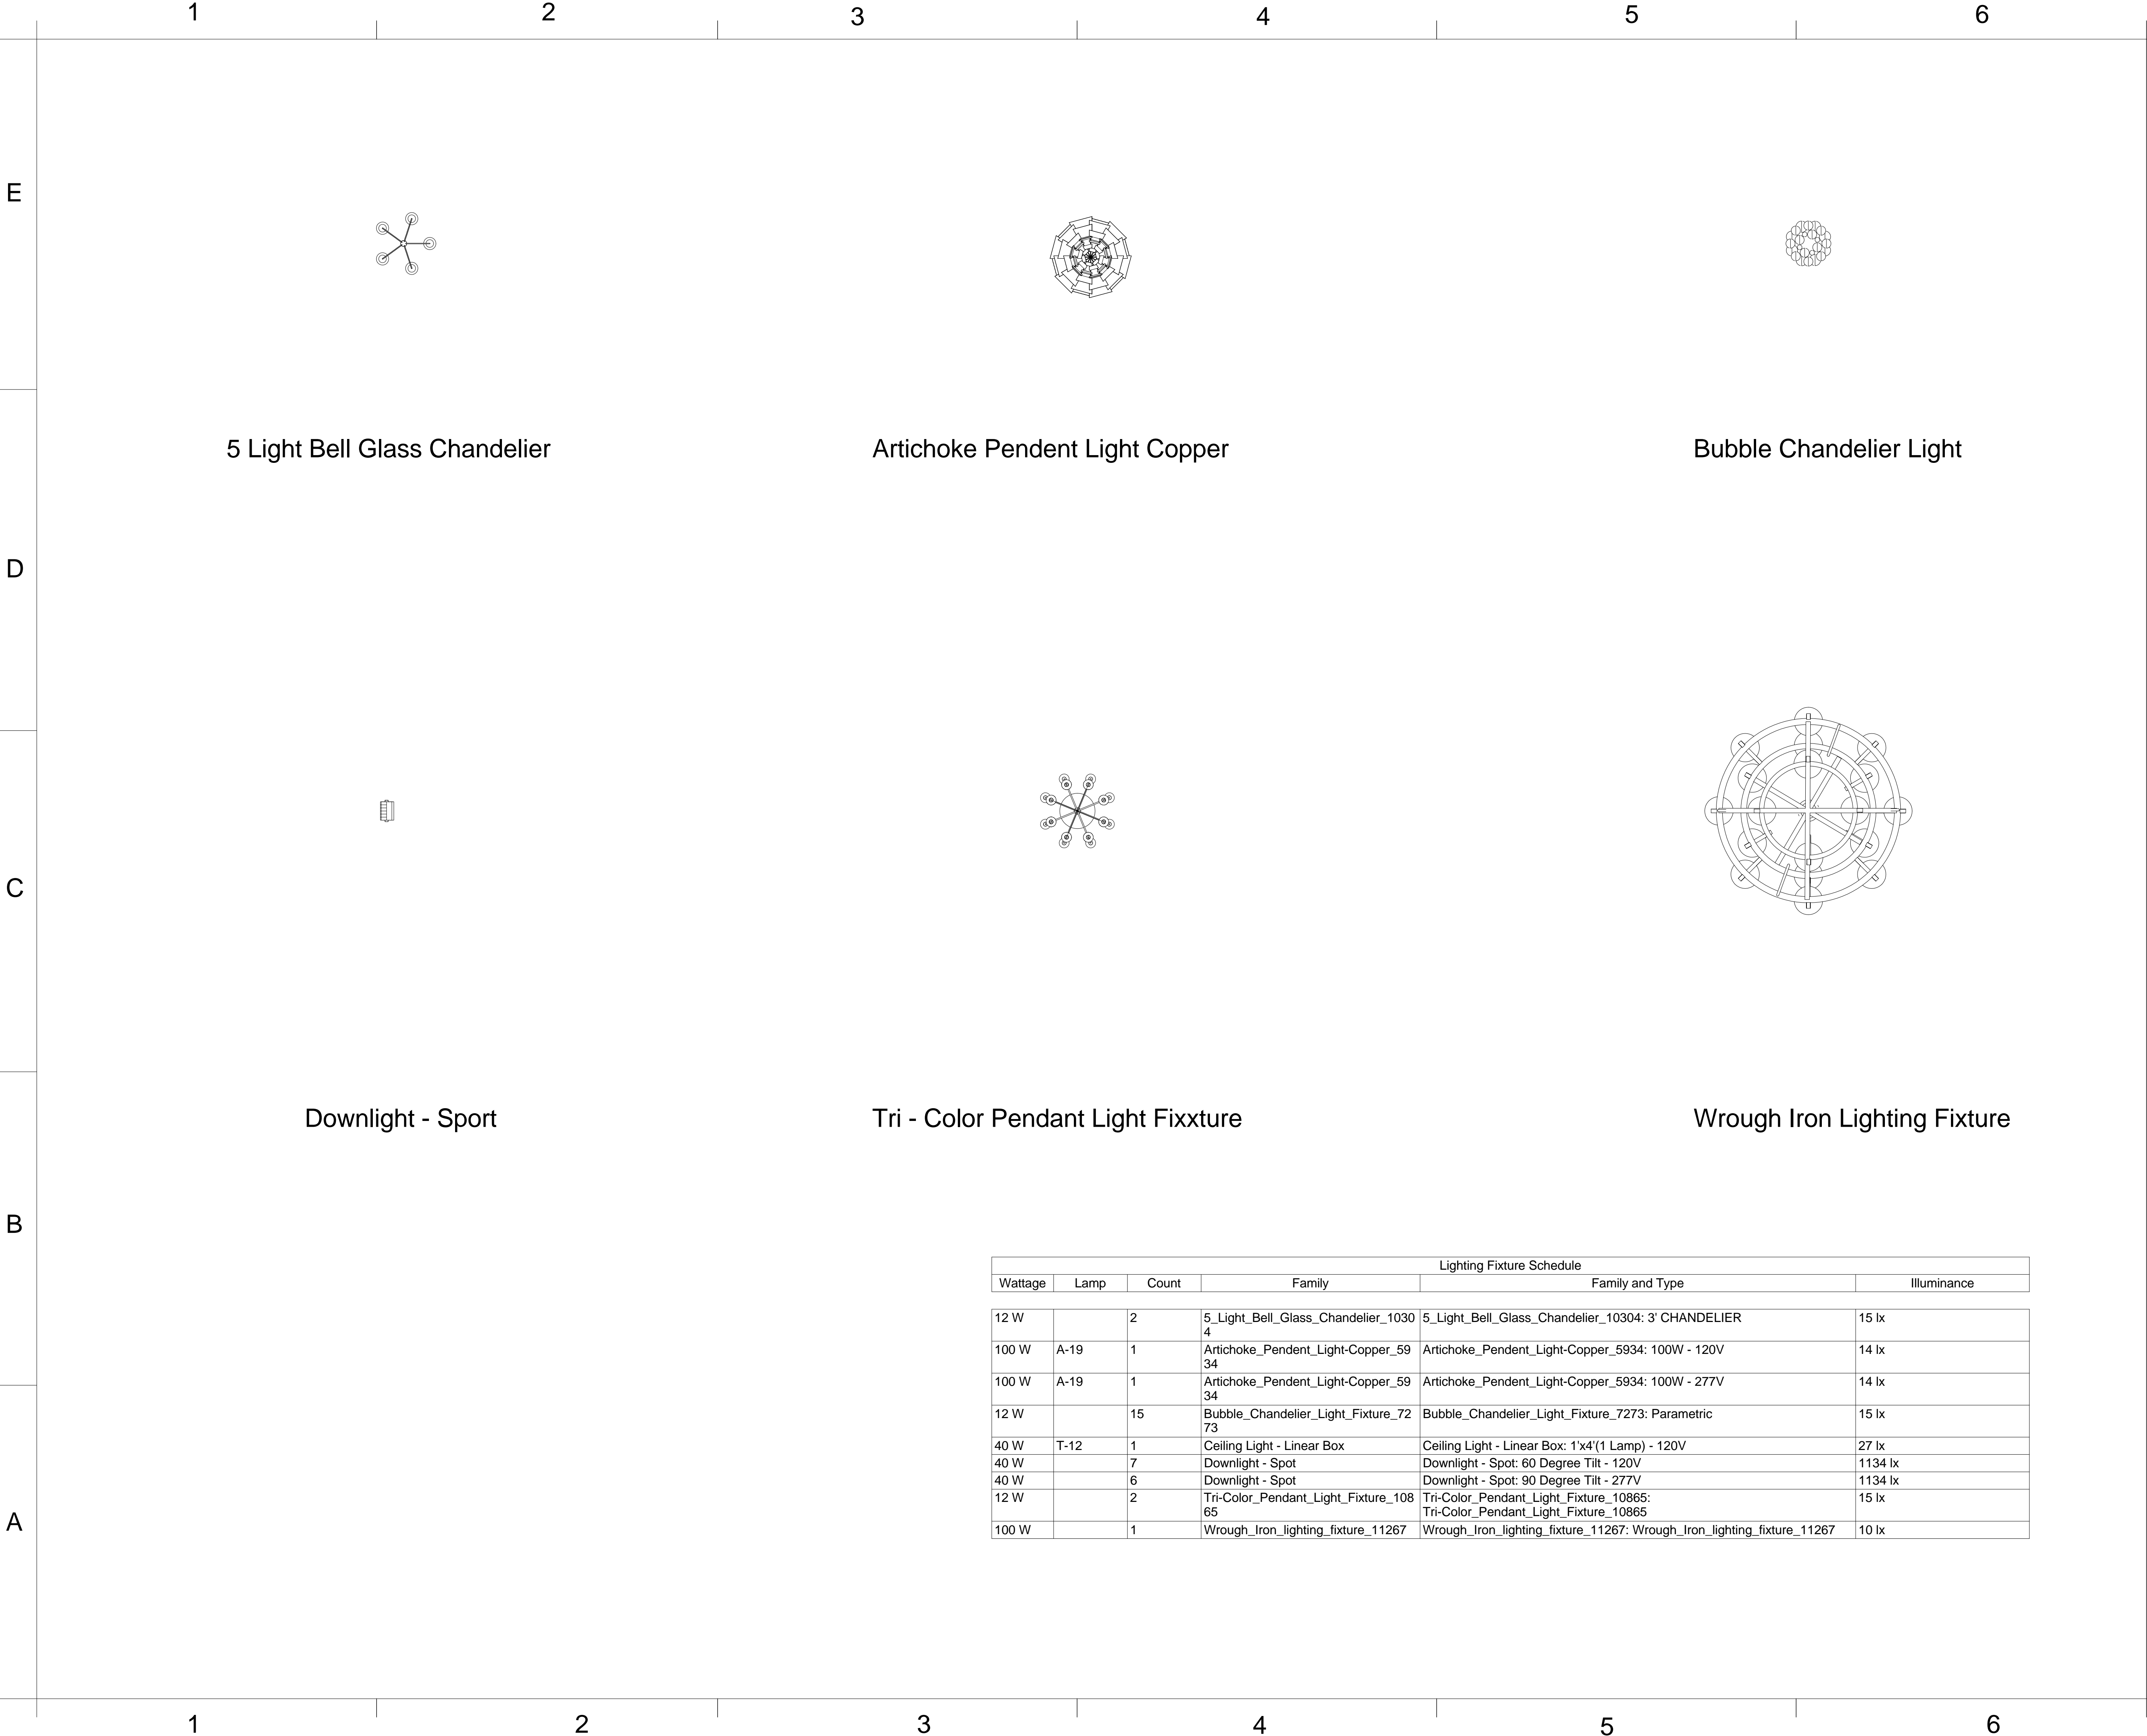

**YH DESIGN**

www.yhdesign.com

Consultant Prof. Chistine Wacta  
Address Eichberg Hall  
Phone 912-228-2696

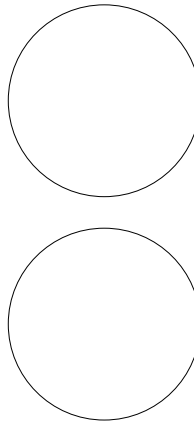

SCAD  
ELDS - 225-07  
FINAL

No.	Description	Date
HW 2B	house by the water	04/15/2013
HW 3	Pre-Final	04/24/2013
HW 4	Pre-Final	05/06/2013
HW 5	Pre- Final	05/13/2013

House by Water

LIGHT FIXTURE  
SCHEDULE

Project Number	Project Number
Date	May 1st, 2013
Drawn By	Yun Huang
Checked By	Prof. Wacta

A 603

Scale	1/2" = 1'-0"
-------	--------------

Lighting Fixture Schedule					
Wattage	Lamp	Count	Family	Family and Type	Illuminance
12 W		2	5_Light_Bell_Glass_Chandelier_10304	5_Light_Bell_Glass_Chandelier_10304: 3' CHANDELIER	15 lx
100 W	A-19	1	Artichoke_Pendent_Light-Copper_5934	Artichoke_Pendent_Light-Copper_5934: 100W - 120V	14 lx
100 W	A-19	1	Artichoke_Pendent_Light-Copper_5934	Artichoke_Pendent_Light-Copper_5934: 100W - 277V	14 lx
12 W		15	Bubble_Chandelier_Light_Fixture_7273	Bubble_Chandelier_Light_Fixture_7273: Parametric	15 lx
40 W	T-12	1	Ceiling Light - Linear Box	Ceiling Light - Linear Box: 1'x4'(1 Lamp) - 120V	27 lx
40 W		7	Downlight - Spot	Downlight - Spot: 60 Degree Tilt - 120V	1134 lx
40 W		6	Downlight - Spot	Downlight - Spot: 90 Degree Tilt - 277V	1134 lx
12 W		2	Tri-Color_Pendant_Light_Fixture_10865	Tri-Color_Pendant_Light_Fixture_10865: Tri-Color_Pendant_Light_Fixture_10865	15 lx
100 W		1	Wrough_Iron_lighting_fixture_11267	Wrough_Iron_lighting_fixture_11267: Wrough_Iron_lighting_fixture_11267	10 lx



123456


E

D


C

B


A

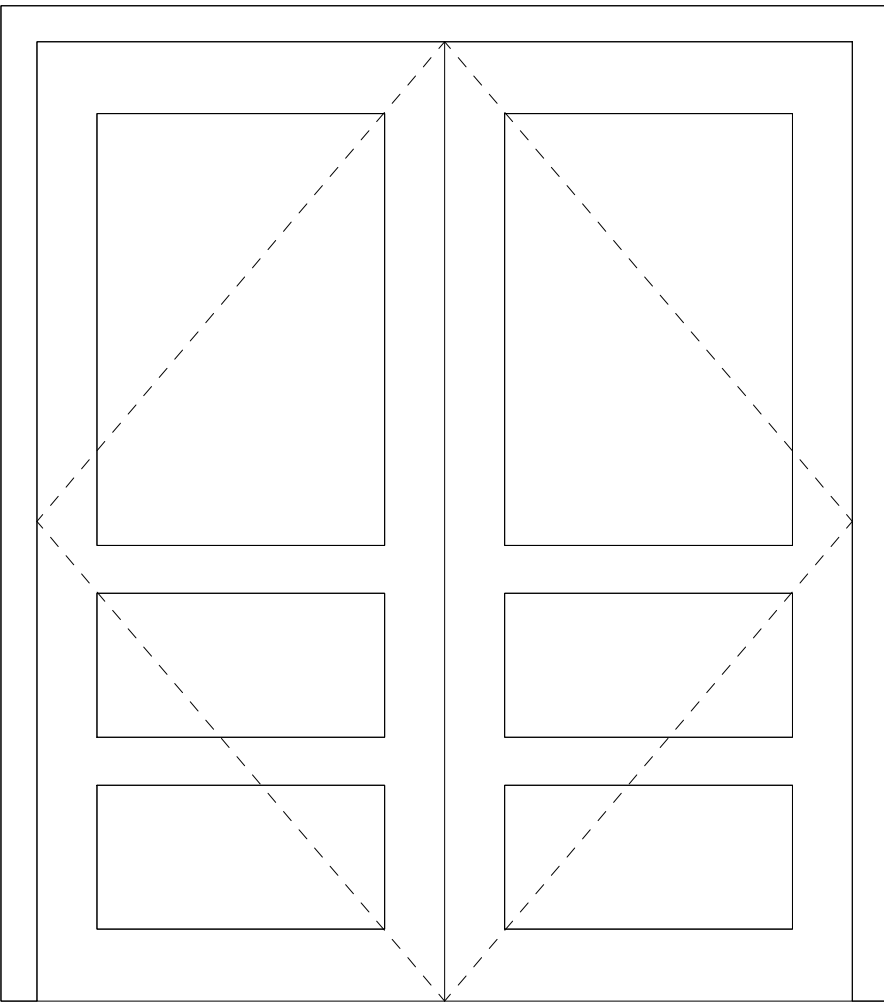


Double Panel

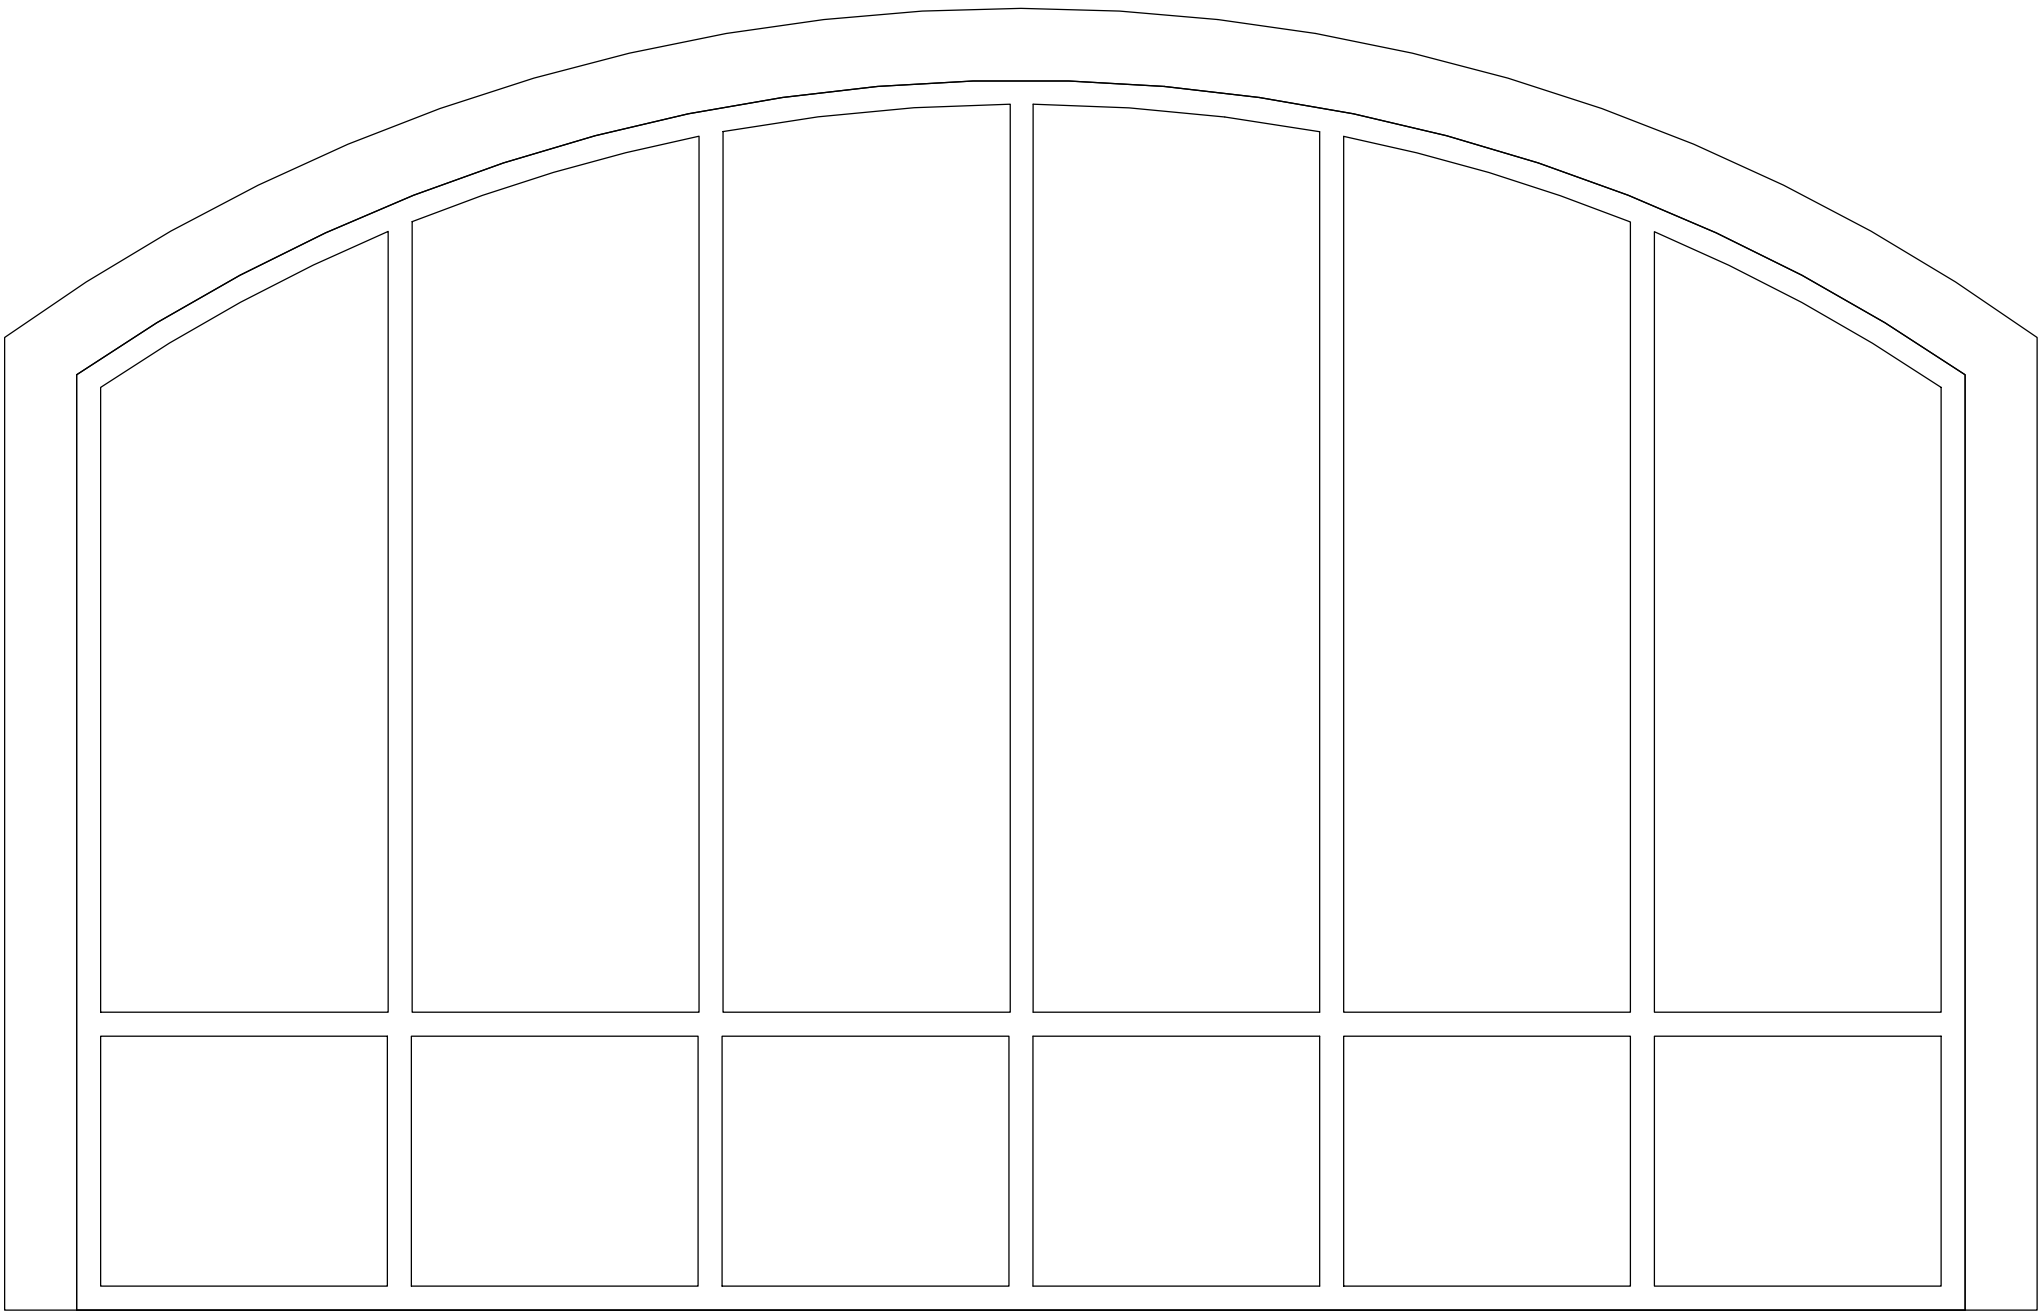


Parametric Garage Door

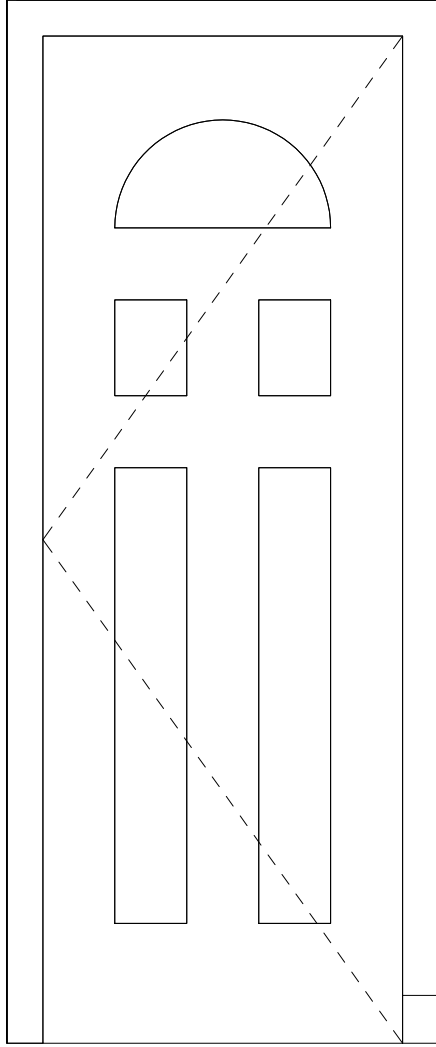

Single Decorative

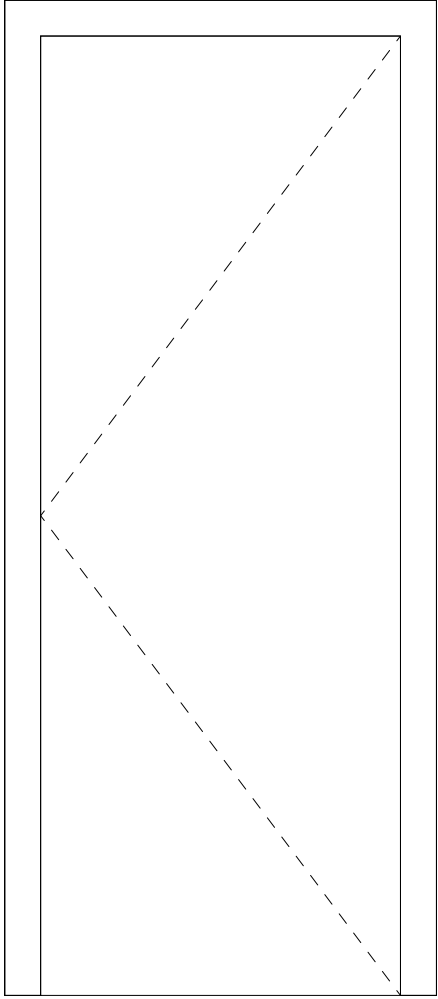

Single Flush

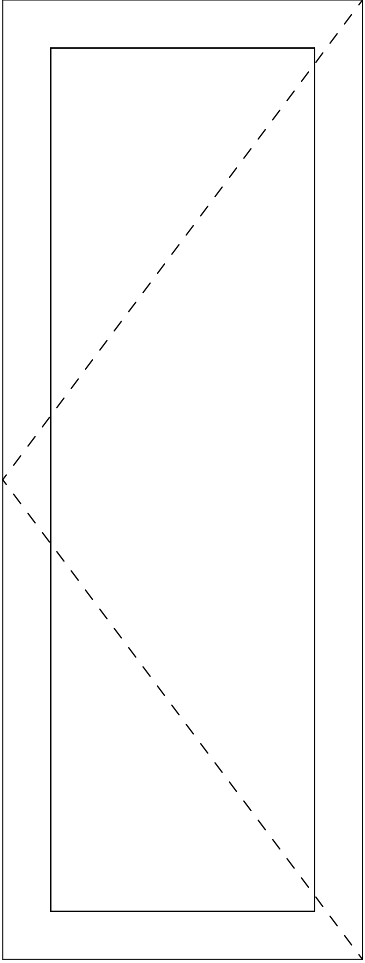

Single Door Glass

Door Schedule							
Mark	Family	Family and Type	Height	Type Mark	Width	Count	Level
9	Double-Pan	Double-Pan el 1: 72" x 84"	7' - 0"	11	6' - 0"	1	00-Ground
41	Parametric_Garage_Do or_14170	Parametric_Garage_Do or_14170: 2435 x 1981mm	6' - 6"	46	13' - 1 15/32"	1	-01-Basement1
	Single-Dec orative 2	Single-Dec orative 2: 30" x 80"	6' - 8"	17	2' - 6"	2	00-Ground
	Single-Flus h	Single-Flus h: 30" x 80"	6' - 8"	5	2' - 6"	3	02-Second
	Single-Flus h Vision					11	

YH DESIGN

www.yhdesign.com

Consultant Prof. Christine Wacta

Address Eichberg Hall

Phone 912-228-2696

SCAD  
ELDS - 225-07  
FINAL

No.	Description	Date
HW 2B	house by the water	04/15/2013
HW 3	Pre-Final	04/24/2013
HW 4	Pre-Final	05/06/2013
HW 5	Pre- Final	05/13/2013

House by Water

DOOR SCHEDULE

Project Number

Project Number

Date

May 1st, 2013

Drawn By

Yun Huang

Checked By


Prof. Wacta

A 604


Scale

3/4" = 1'-0"


5/30/2013 11:34:36 AM

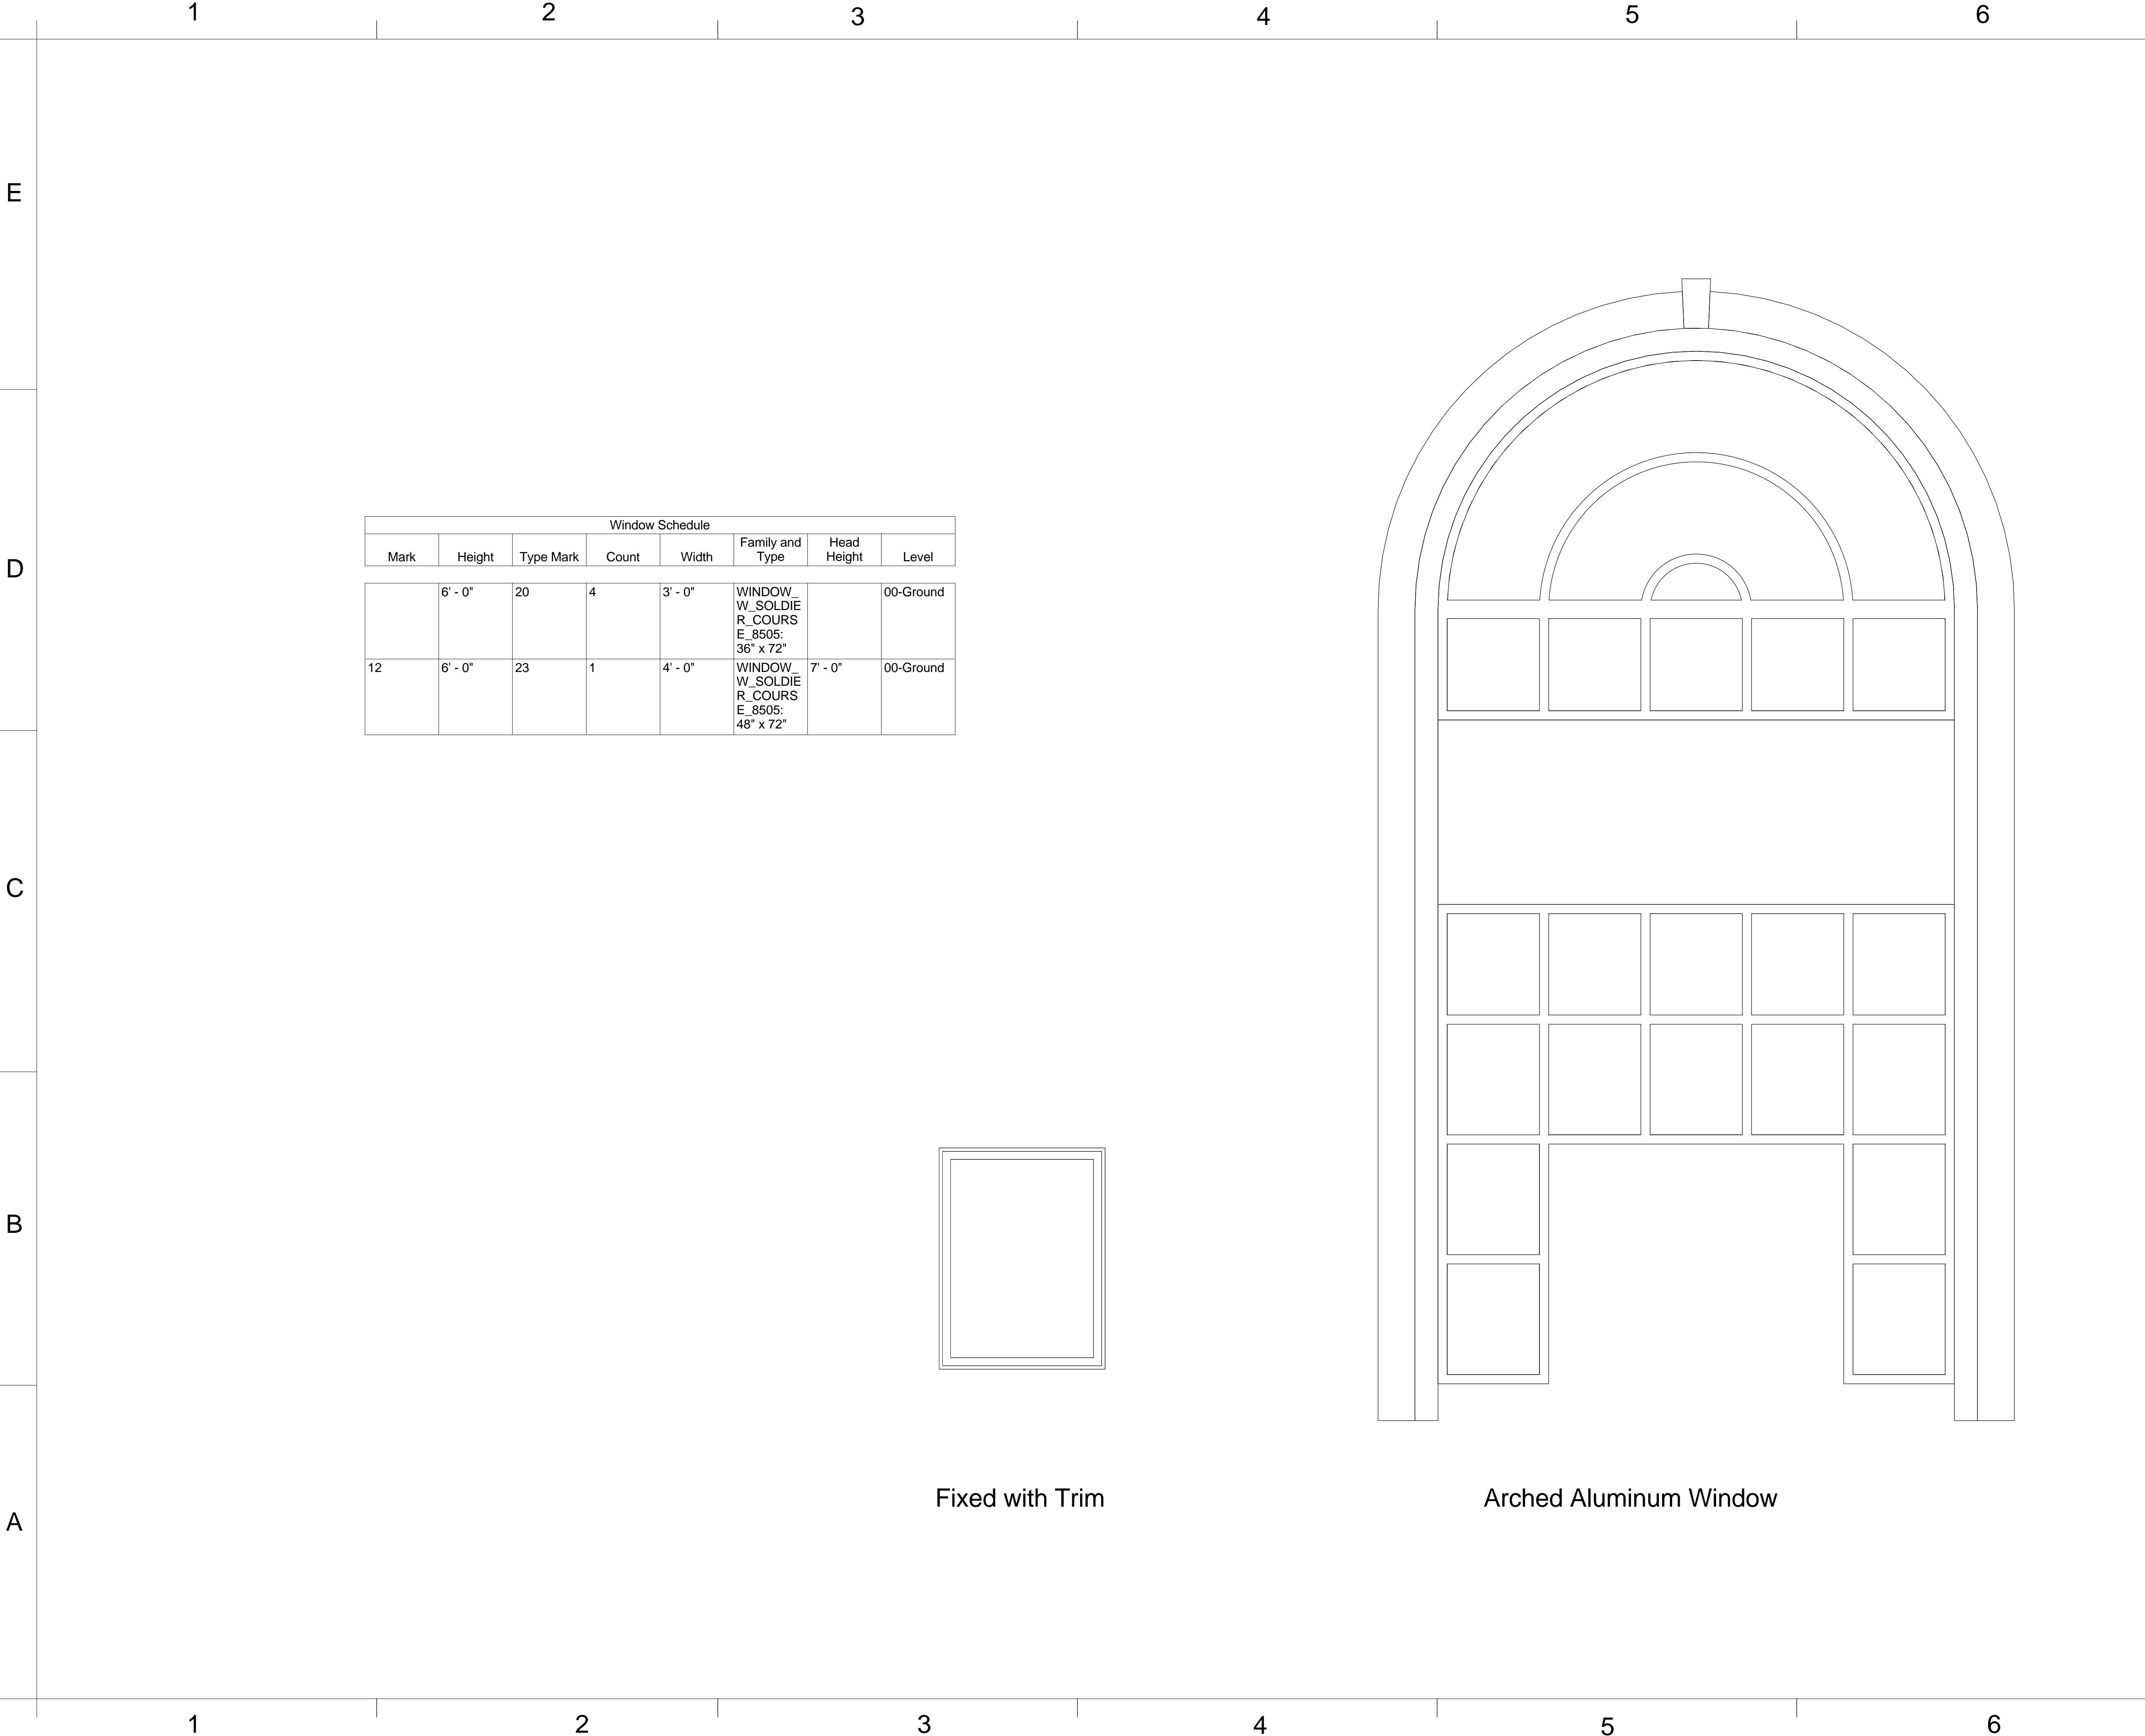

Window Schedule							
Mark	Height	Type Mark	Count	Width	Family and Type	Head Height	Level
	6' - 0"	20	4	3' - 0"	WINDOW W_SOLDIE R_COURS E_8505: 36" x 72"		00-Ground
12	6' - 0"	23	1	4' - 0"	WINDOW W_SOLDIE R_COURS E_8505: 48" x 72"	7' - 0"	00-Ground

 

Fixed with Trim

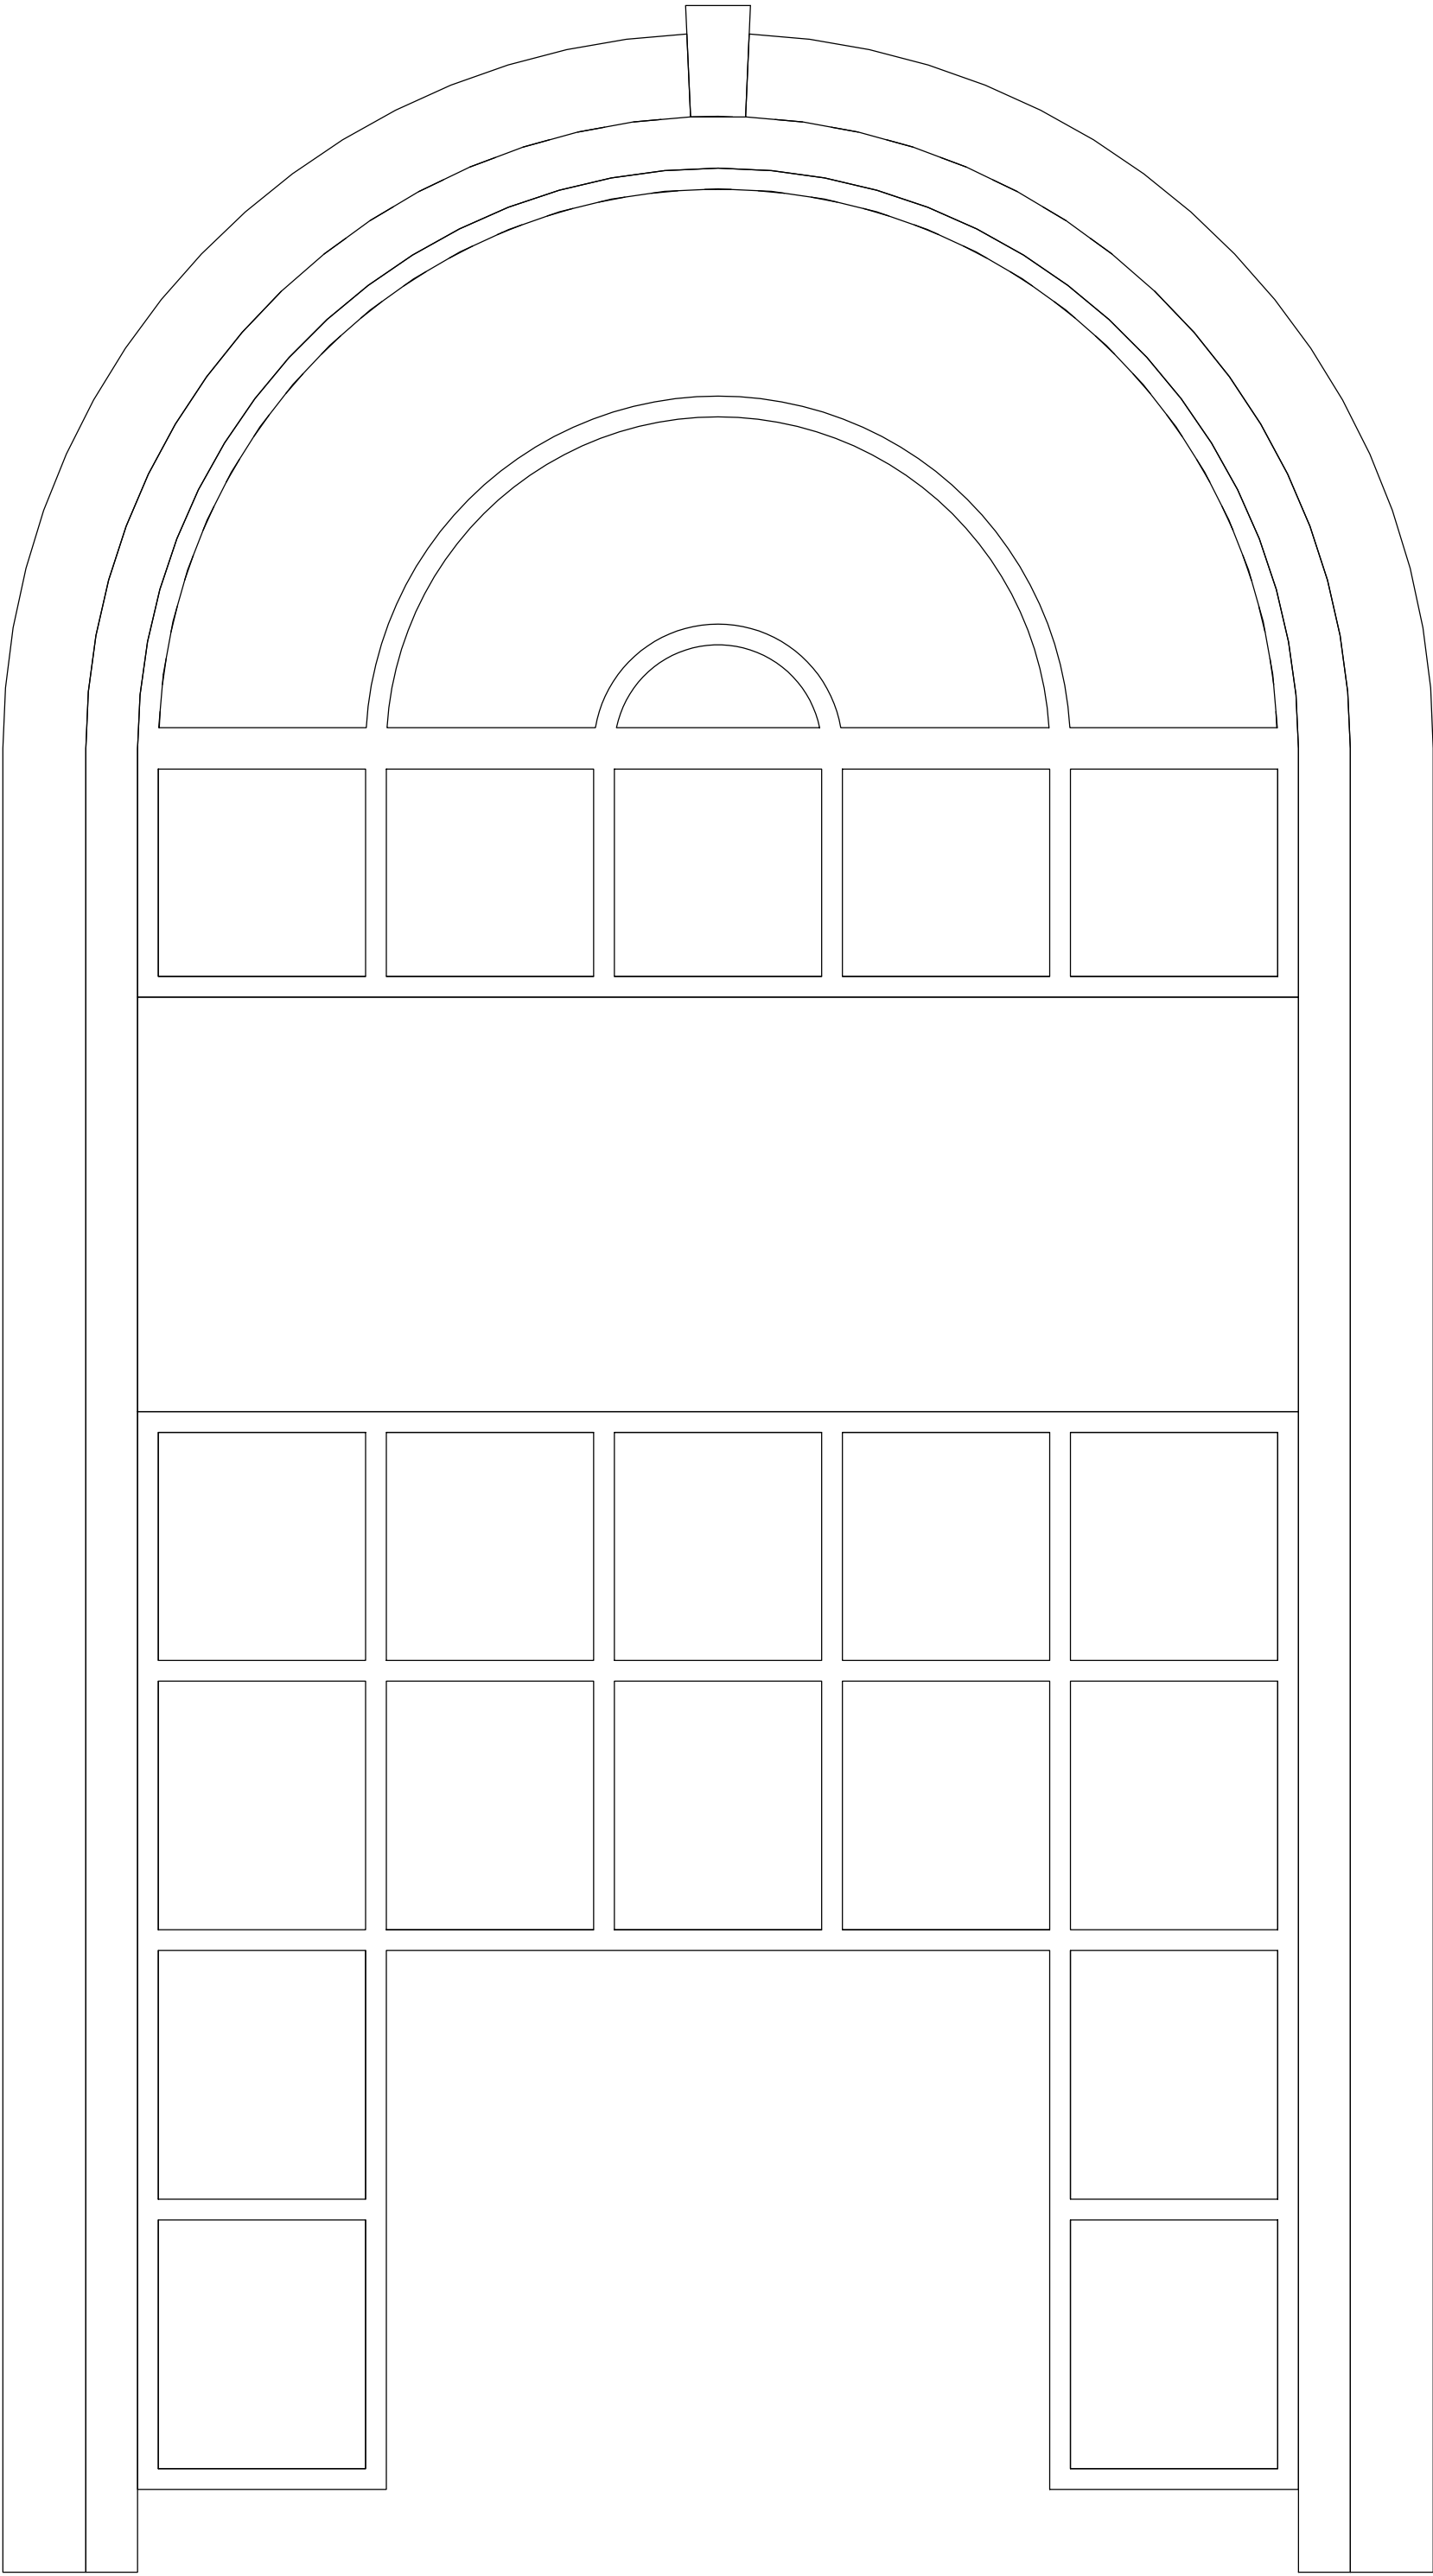


Arched Aluminum Window

**YH DESIGN**

www.yhdesign.com

Consultant Prof. Christine Wacta  
Address Eichberg Hall  
Phone 912-228-2696

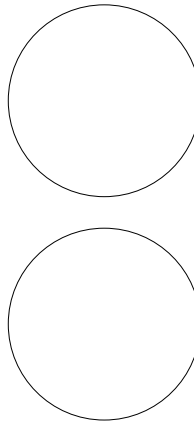

**SCAD  
ELDS - 225-07  
FINAL**

No.	Description	Date
HW 2B	house by the water	04/15/2013
HW 3	Pre-Final	04/24/2013
HW 4	Pre-Final	05/06/2013
HW 5	Pre- Final	05/13/2013

House by Water


**WINDOW  
SCHEDULE**

Project Number	Project Number
Date	May 1st, 2013
Drawn By	Yun Huang
Checked By	Prof. Wacta

**A 605**

Scale	3/4" = 1'-0"
-------	--------------




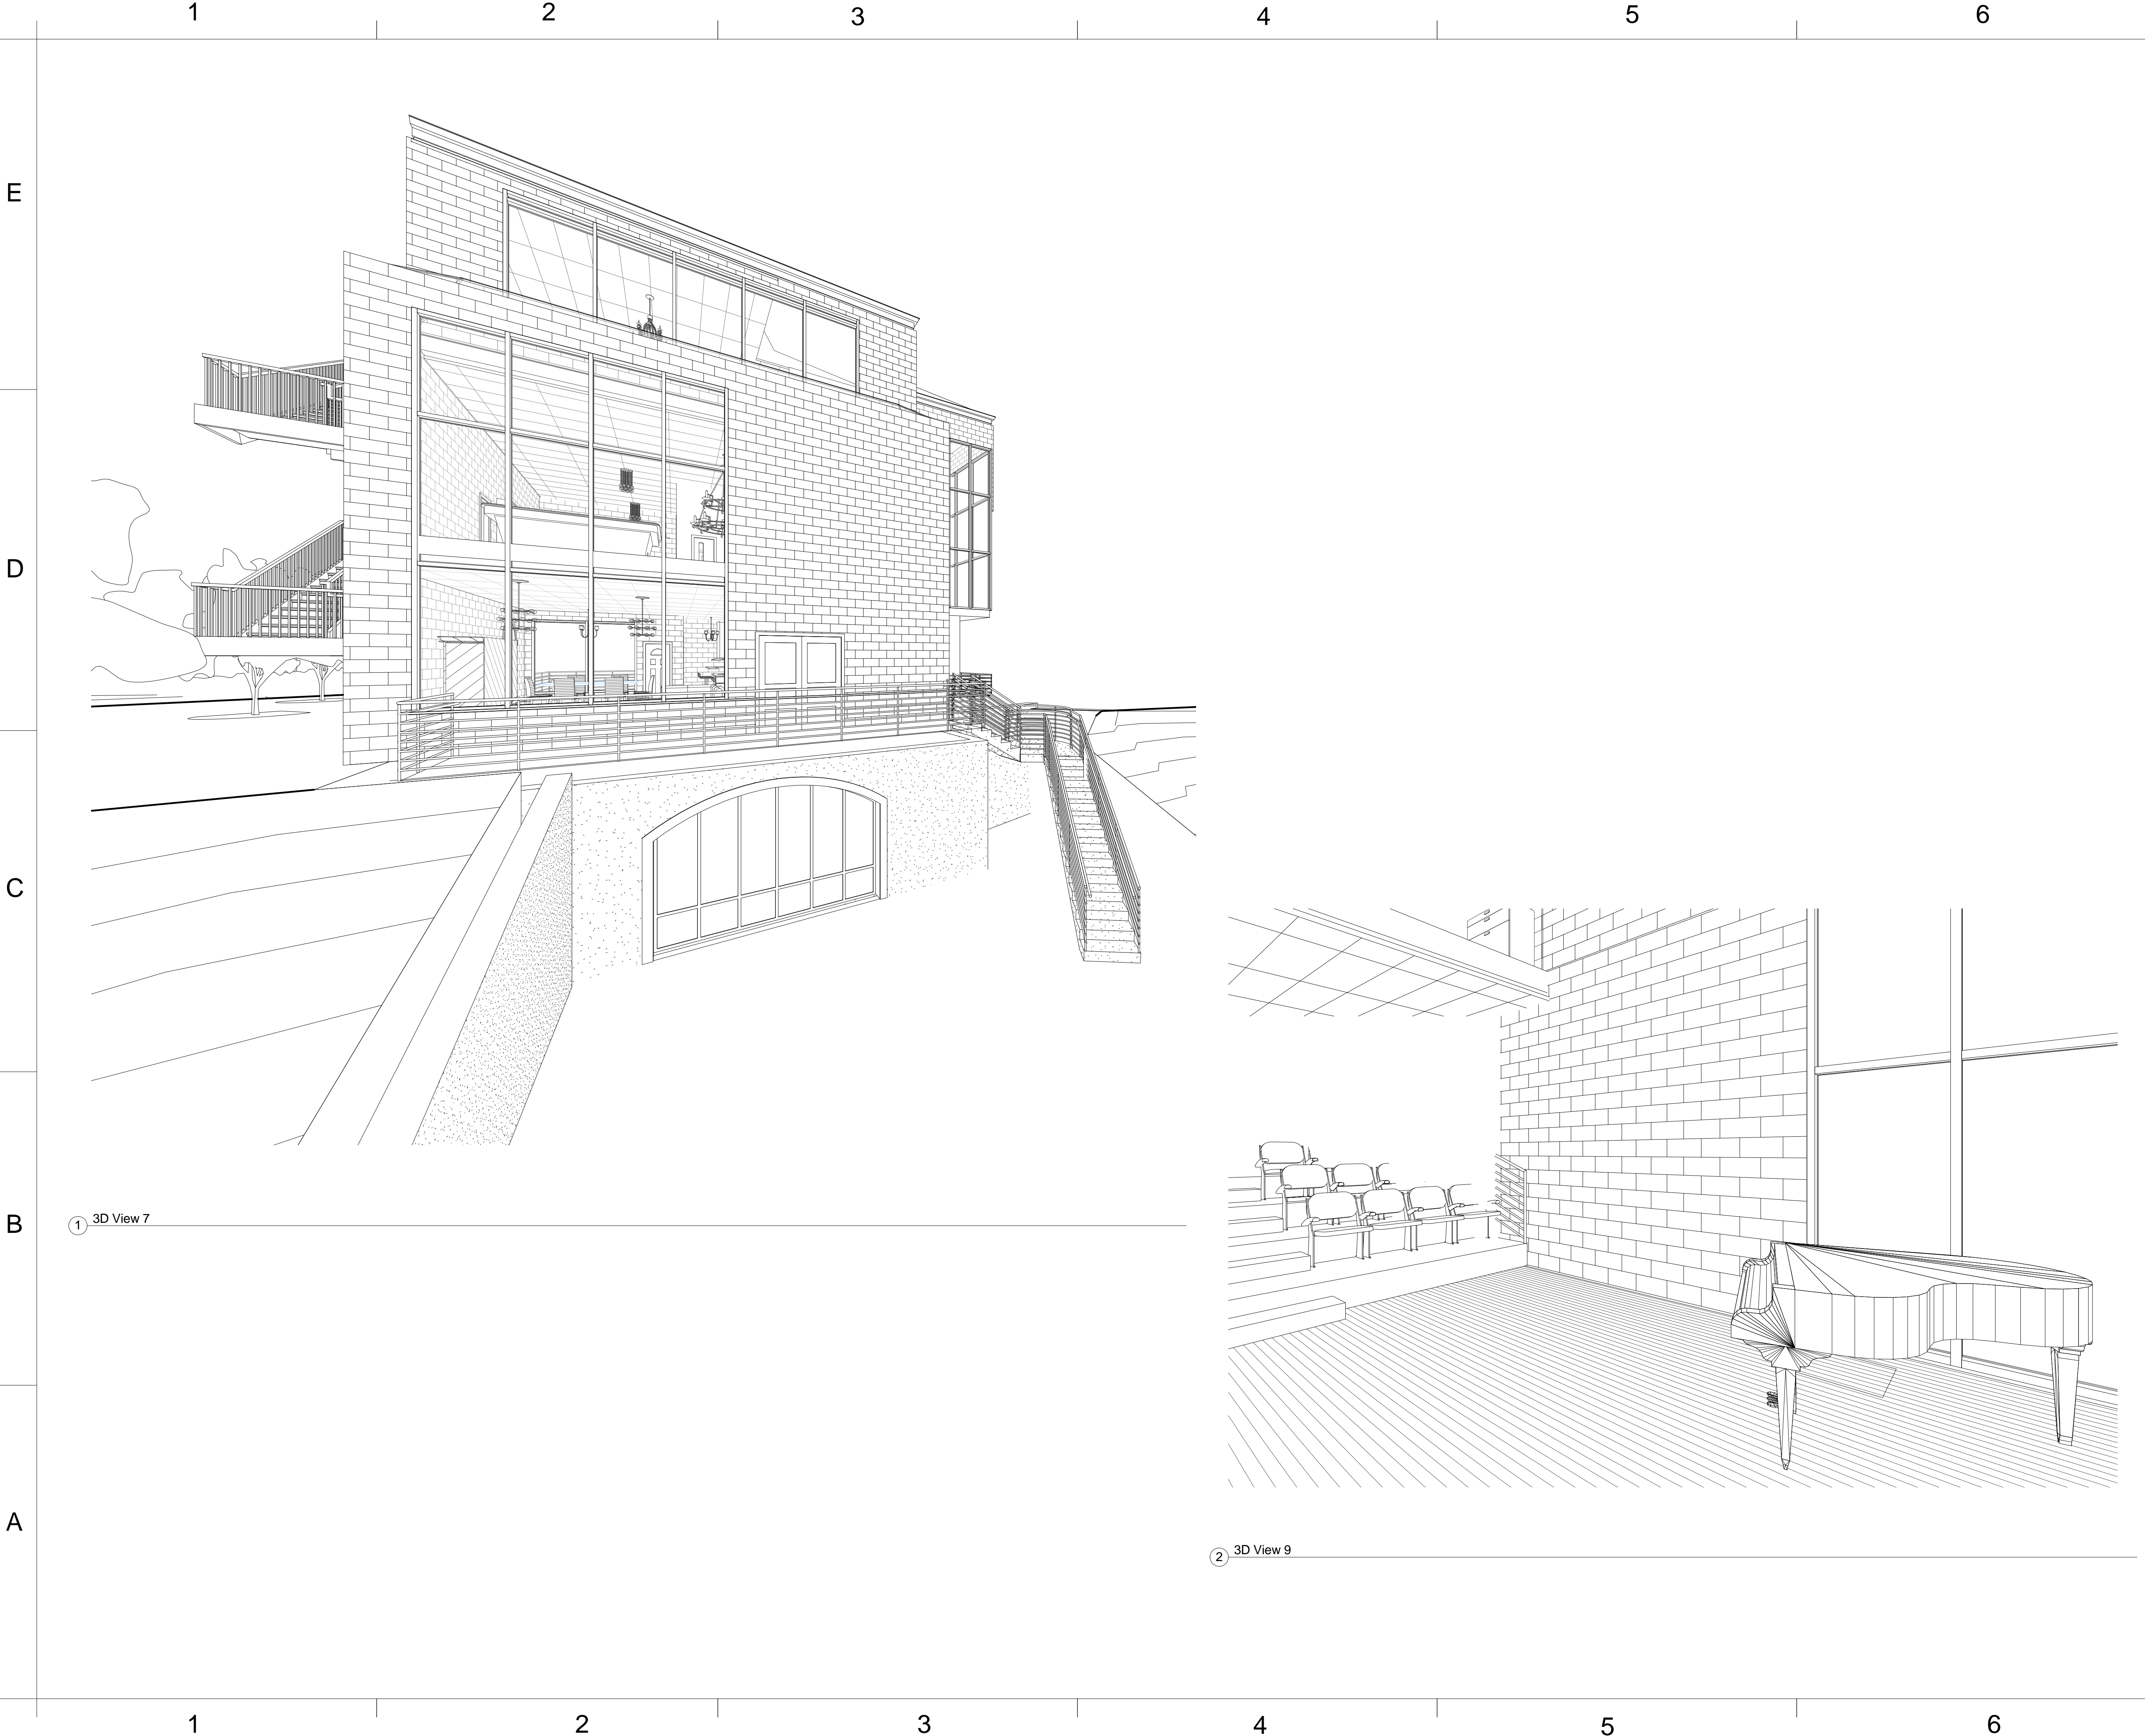

**YH DESIGN**

www.yhdesign.com

Consultant Prof. Christine Wacta  
Address Eichberg Hall  
Phone 912-228-2696

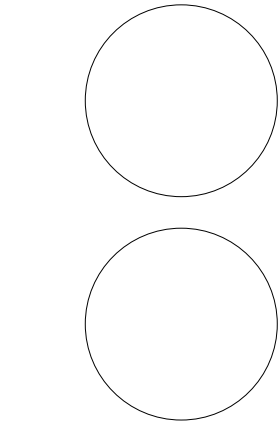

**SCAD  
ELDS - 225-07  
FINAL**

No.	Description	Date
HW 2B	house by the water	04/15/2013
HW 3	Pre-Final	04/24/2013
HW 4	Pre-Final	05/06/2013
HW 5	Pre- Final	05/13/2013

House by Water

USER DEFINED

Project Number	Project Number
Date	May 1st, 2013
Drawn By	Yun Huang
Checked By	Prof. Wacta

**A 700**

Scale



E

D

C

B

A



③ 3D View 10\_1  
12" = 1'-0"



② Rendering 00 Living Area  
12" = 1'-0"



① Rendering 01 Concert Area  
12" = 1'-0"




④ 3D View 11\_1  
12" = 1'-0"

**YH DESIGN**

www.yhdesign.com

Consultant Prof. Christine Wacta  
Address Eichberg Hall  
Phone 912-228-2696

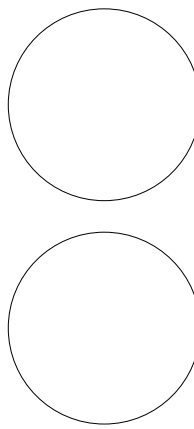

**SCAD  
ELDS - 225-07  
FINAL**

No.	Description	Date
HW 2B	house by the water	04/15/2013
HW 3	Pre-Final	04/24/2013
HW 4	Pre-Final	05/06/2013
HW 5	Pre-Final	05/13/2013

**House by Water**


**RENDERINGS**

Project Number	Project Number
Date	May 1st, 2013
Drawn By	Yun Huang
Checked By	Prof. Wacta

**A 800**

Scale	12" = 1'-0"
-------	-------------




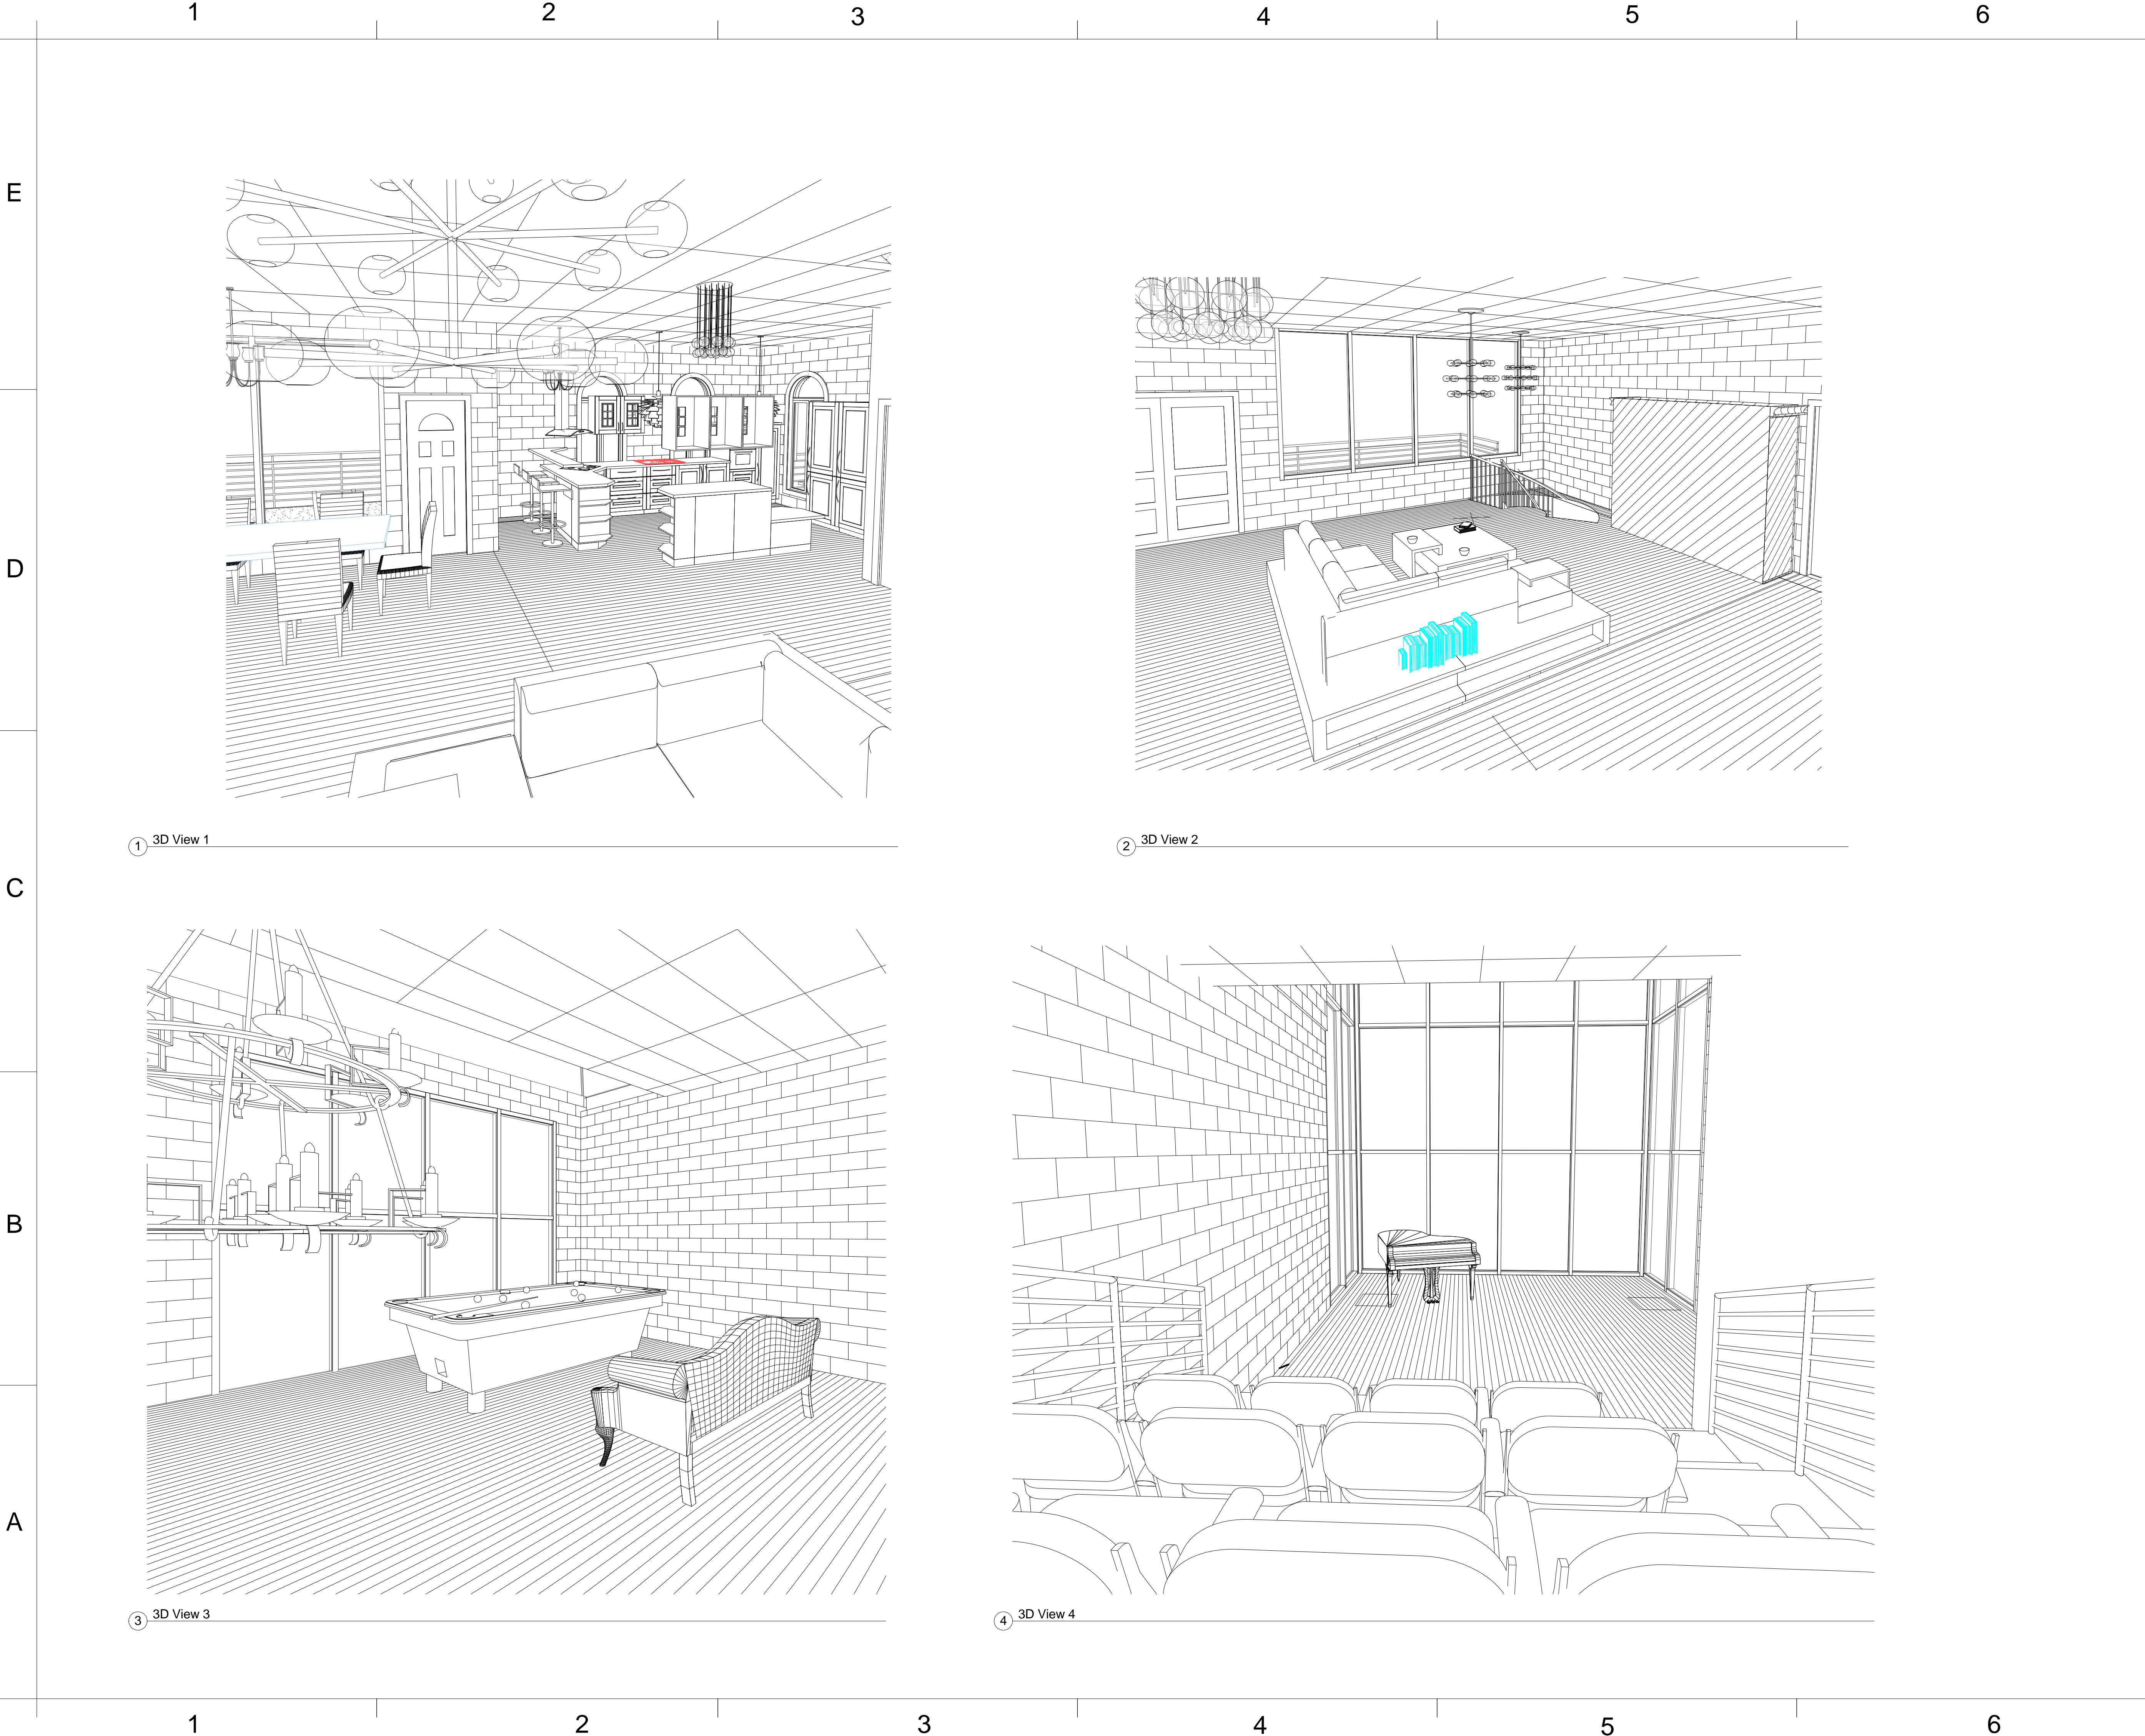

**YH DESIGN**

www.yhdesign.com

Consultant Prof. Christine Wacta  
Address Eichberg Hall  
Phone 912-228-2696

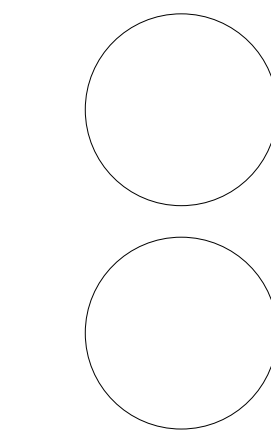

**SCAD  
ELDS - 225-07  
FINAL**

No.	Description	Date
HW 2B	house by the water	04/15/2013
HW 3	Pre-Final	04/24/2013
HW 4	Pre-Final	05/06/2013
HW 5	Pre- Final	05/13/2013

House by Water


**INTERIOR  
CAMERA**

Project Number	Project Number
Date	May 1st, 2013
Drawn By	Yun Huang
Checked By	Prof. Wacta

**A 901**

Scale




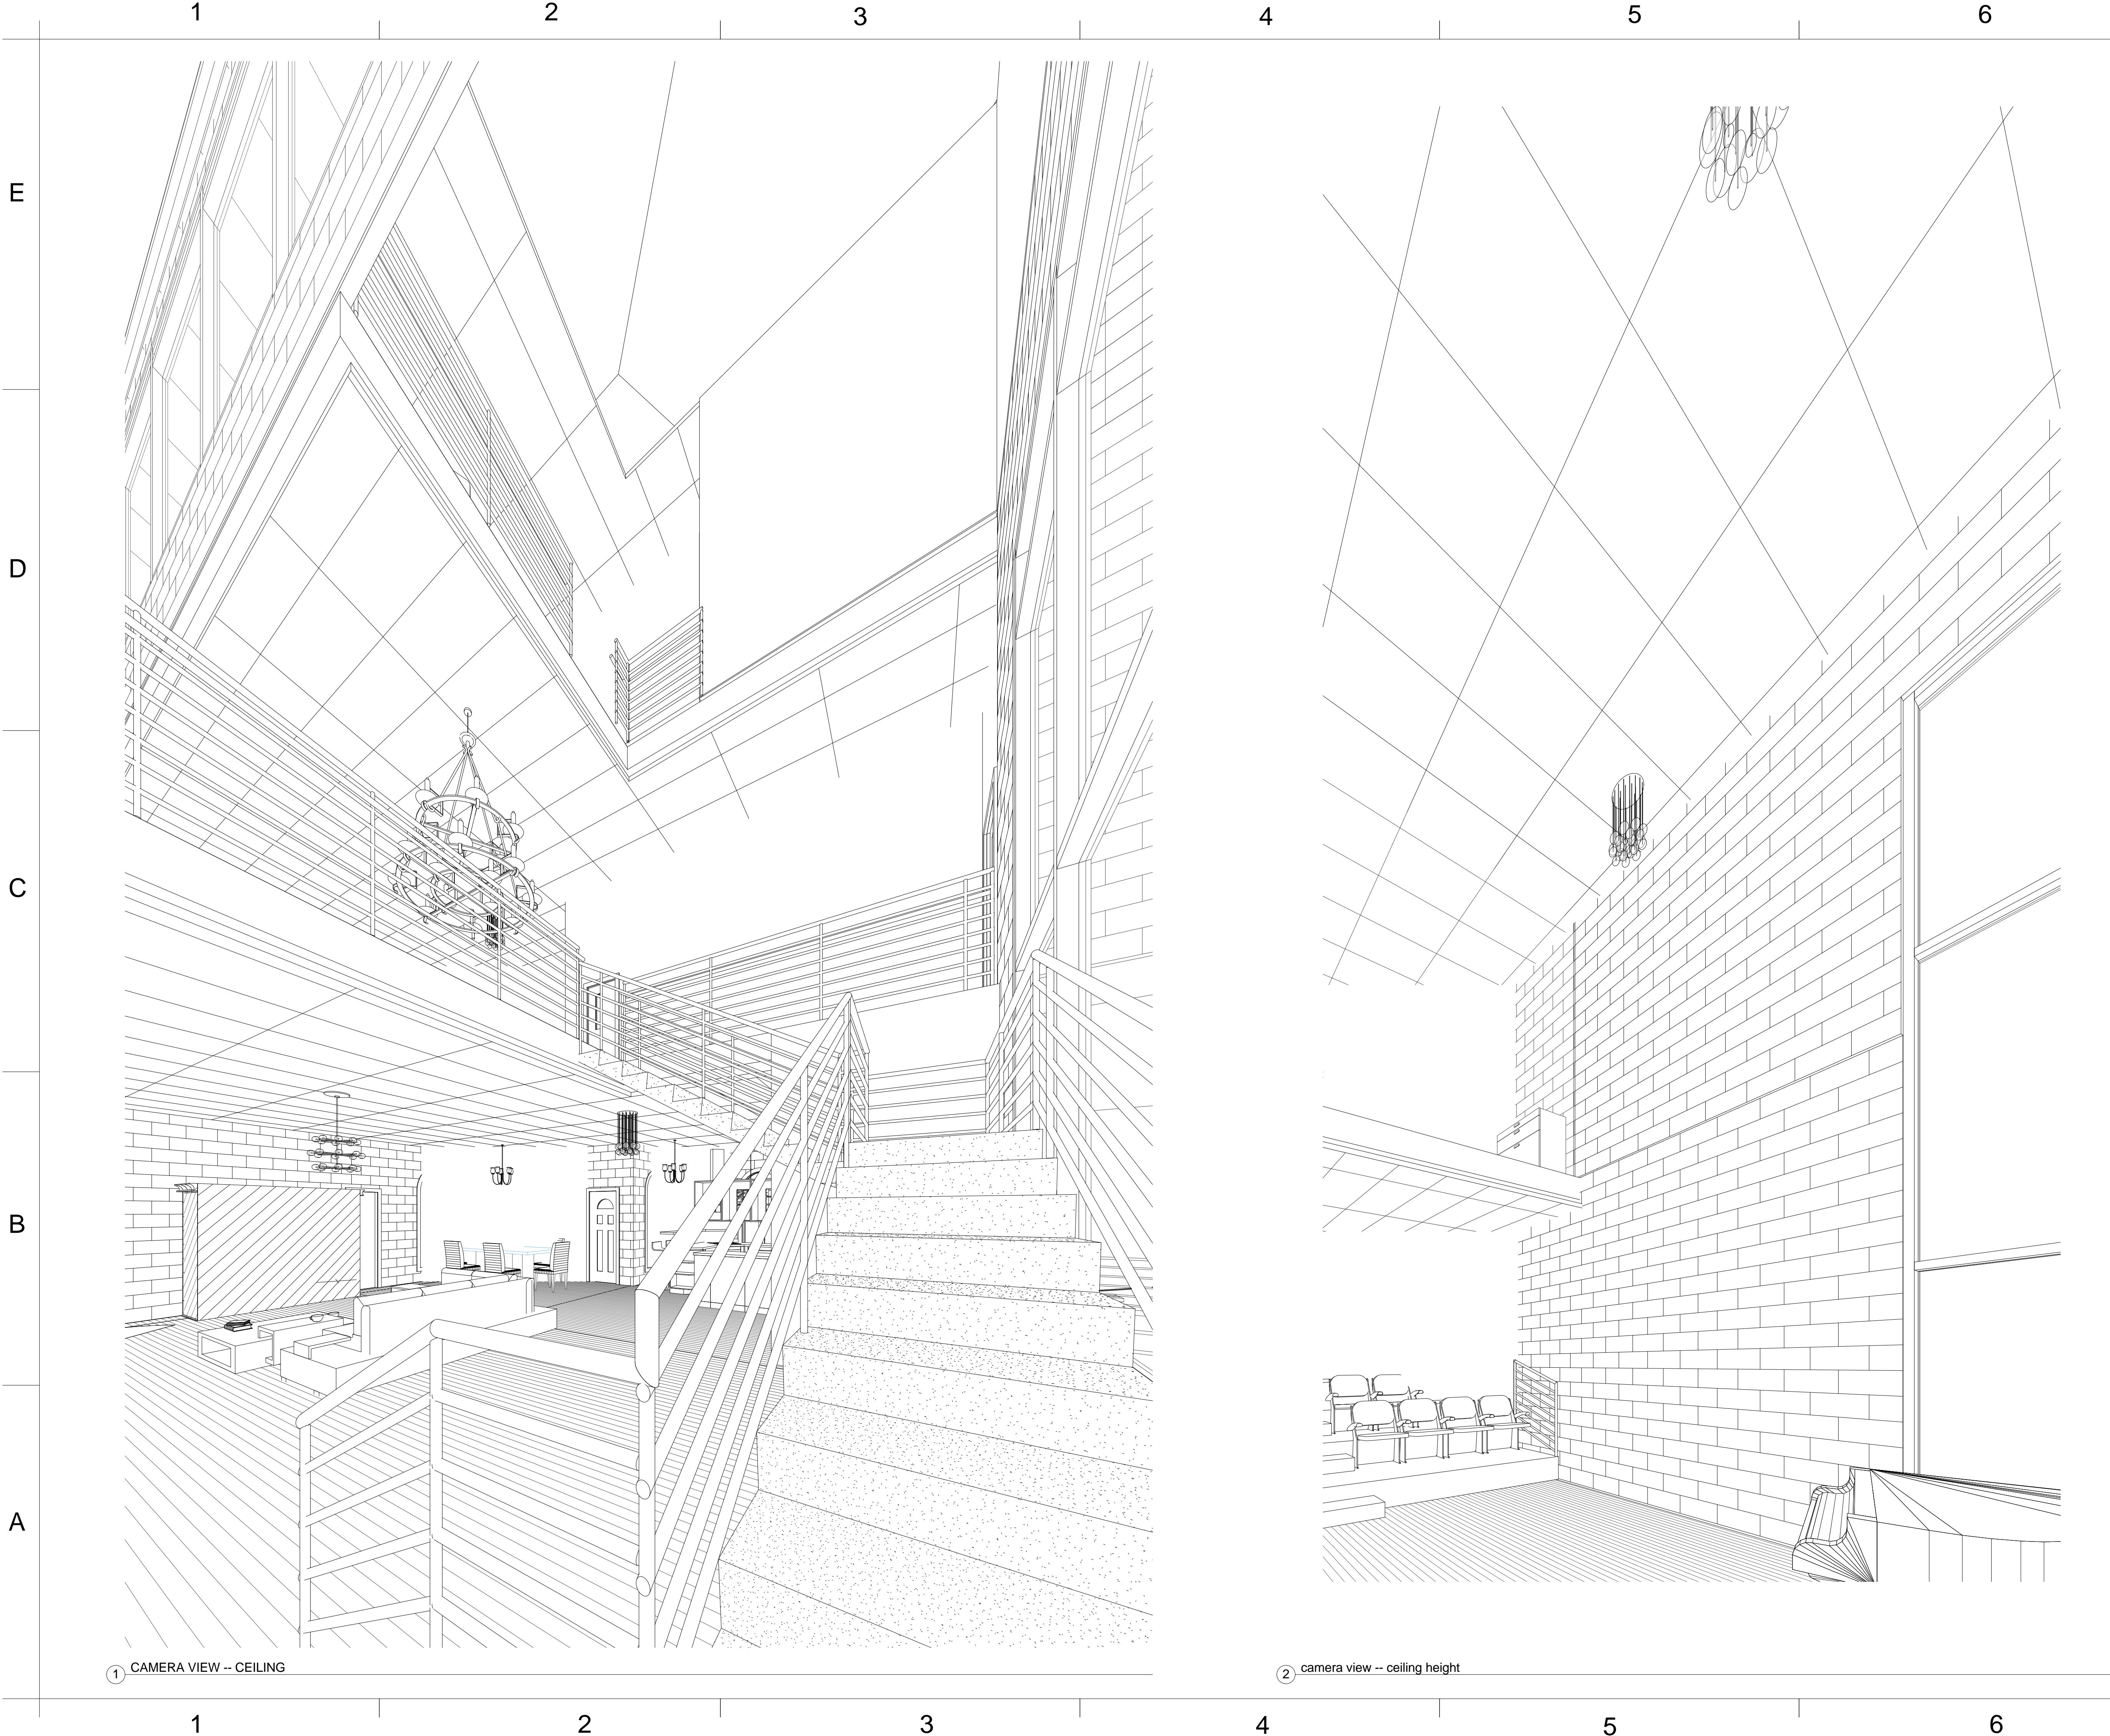

**YH DESIGN**

www.yhdesign.com

Consultant Prof. Christine Wacta  
Address Eichberg Hall  
Phone 912-228-2696

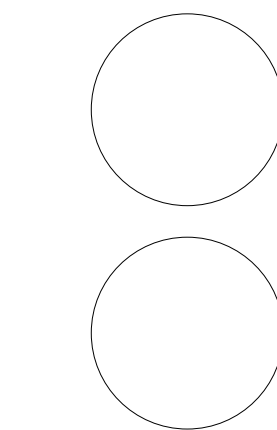

**SCAD**  
**ELDS - 225-07**  
**FINAL**

No.	Description	Date
HW 2B	house by the water	04/15/2013
HW 3	Pre-Final	04/24/2013
HW 4	Pre-Final	05/06/2013
HW 5	Pre- Final	05/13/2013

House by Water

**INTERIOR**  
**CAMERA-CEILING**  
**HEIGHT**

Project Number	Project Number
Date	May 1st, 2013
Drawn By	Yun Huang
Checked By	Prof. Wacta


**A 902**

Scale








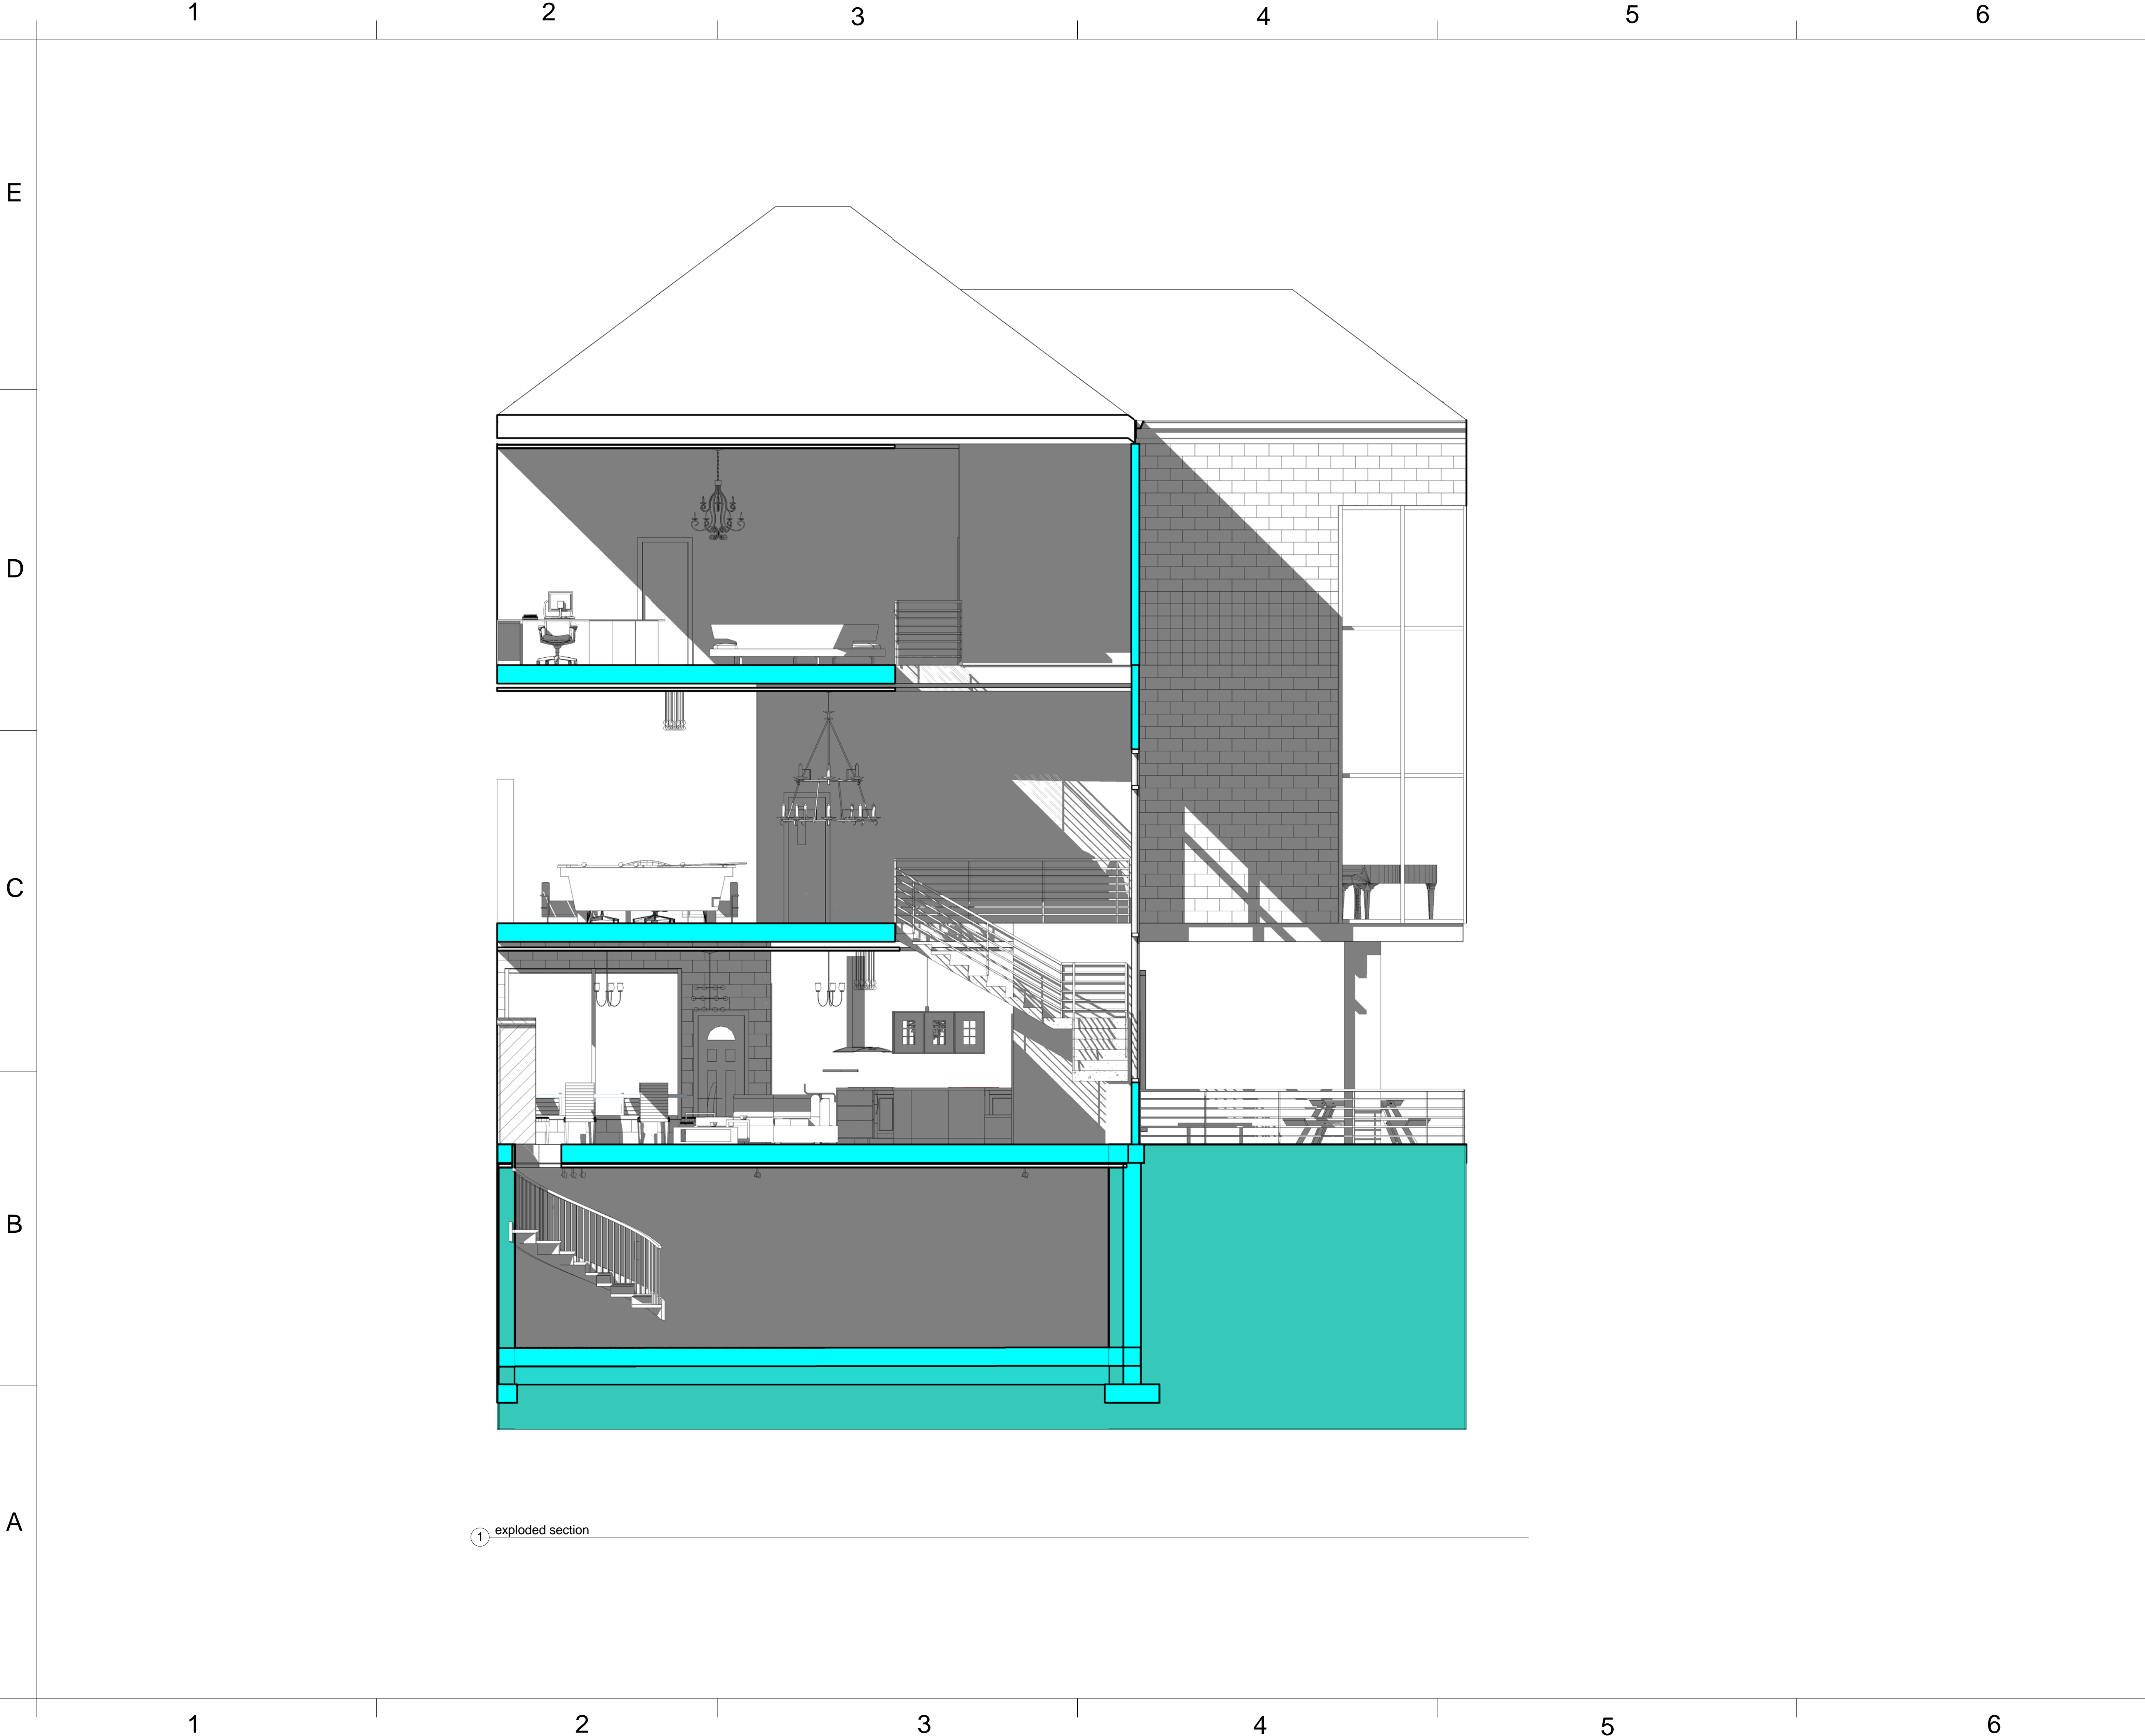

**YH DESIGN**

www.yhdesign.com

Consultant Prof. Christine Wacta  
Address Eichberg Hall  
Phone 912-228-2696

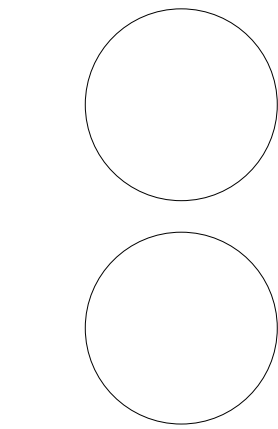

SCAD  
ELDS - 225-07  
FINAL

No.	Description	Date
HW 2B	house by the water	04/15/2013
HW 3	Pre-Final	04/24/2013
HW 4	Pre-Final	05/06/2013
HW 5	Pre- Final	05/13/2013

House by Water

EXPLODED  
SECTION

Project Number	Project Number
Date	May 1st, 2013
Drawn By	Yun Huang
Checked By	Prof. Wacta

A 905

Scale